
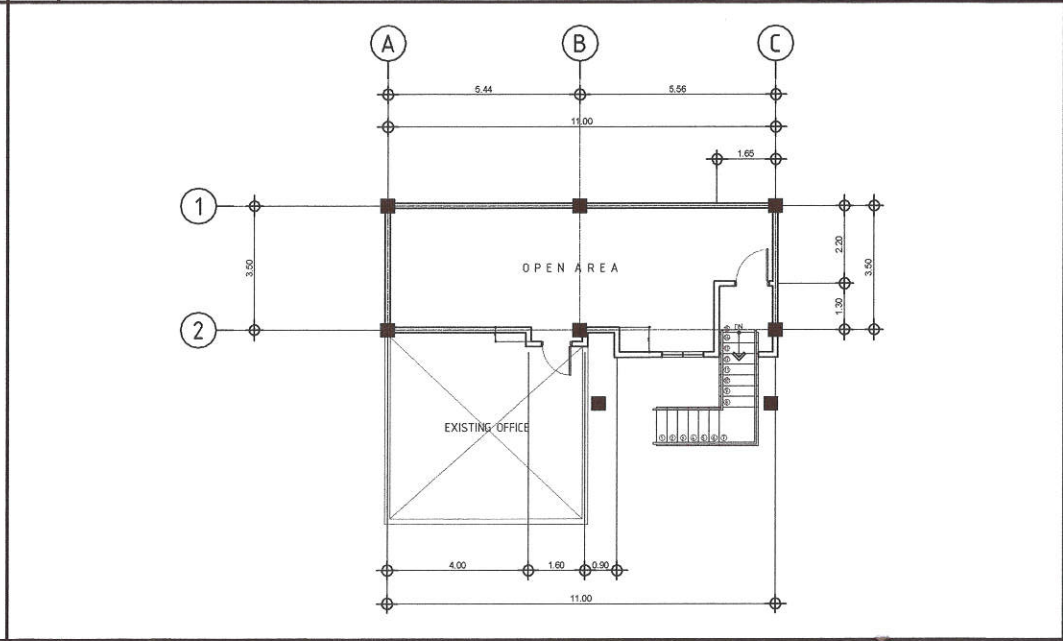


1 VICINITY MAP SCALE : N T S

2 FRONT ELEVATION SCALE : 1:15m


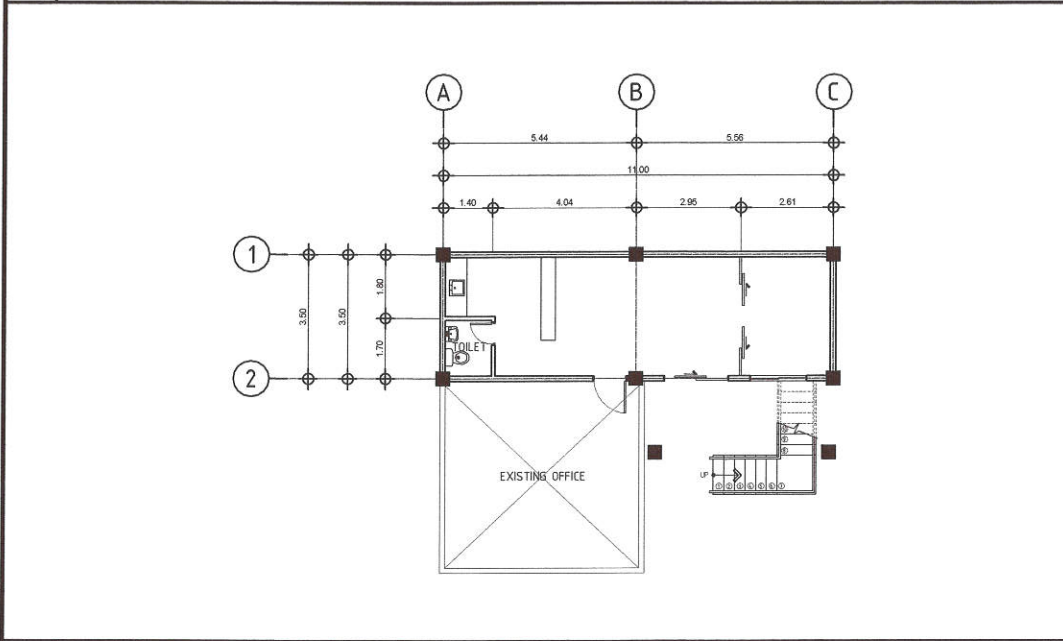


3 EXISTING GROUND FLOOR PLAN SCALE : 1:15m

4 EXISTING SECOND FLOOR PLAN SCALE : 1:15m

<p>Republika ng Pilipinas Lungsod ng Quezon CITY ENGINEERING DEPARTMENT</p>	PROJECT TITLE:	DRAWN BY:	SUBMITTED BY:	RECOMMENDING APPROVAL:	APPROVED BY:	SHEET CONTENT	SHEET NO.
	PROPOSED REHABILITATION OF TWO (2) STOREY SUNTAY MULTI-PURPOSE HALL	DATE: 11/10/2020	 ENGR. LEO S. DEL ROSARIO HEAD, PLANNING & PROGRAMMING DIVISION	 ENGR. SABANI R. VERZOSA, JR. C.E. CITY ENGINEERING DEPARTMENT	HON. MA. JOSEFINA G. BELMONTE CITY MAYOR, QUEZON CITY	VICINITY MAP FRONT ELEVATION EXISTING GROUND FLOOR PLAN EXISTING SECOND FLOOR PLAN	AR 01
	LOCATION: BARANGAY KAMUNING, DISTRICT 4, QUEZON CITY	CHECKED BY:				REVISION NO.:	

20-00128

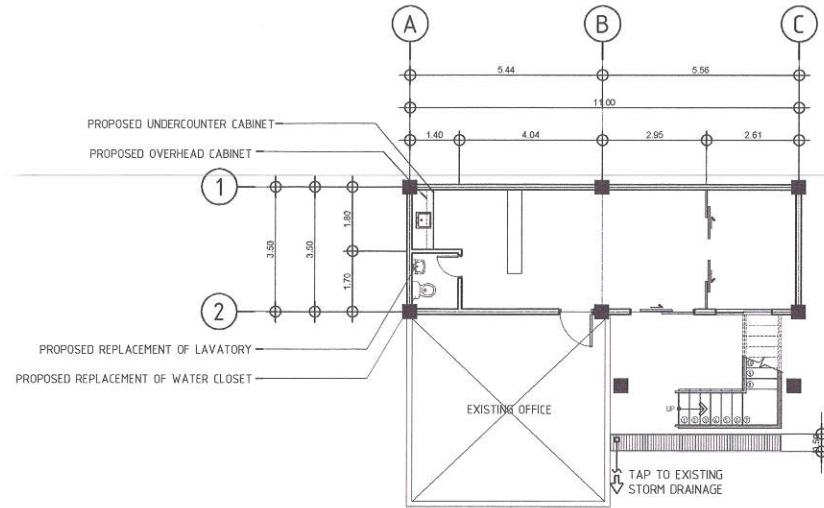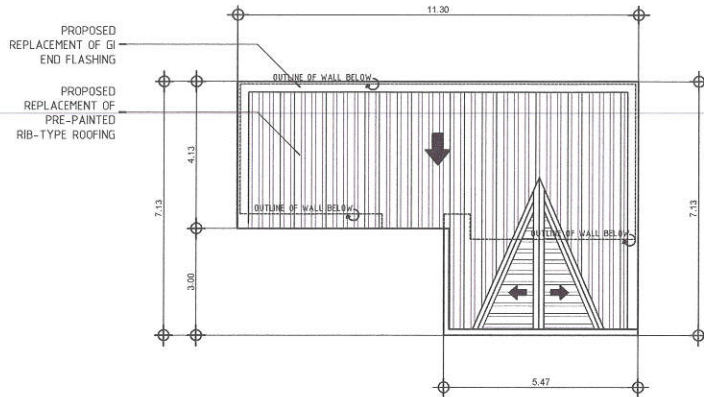


1 ROOF PLAN



SCALE : 1:15m

2 PROPOSED GROUND FLOOR PLAN

SCALE : 1:15m

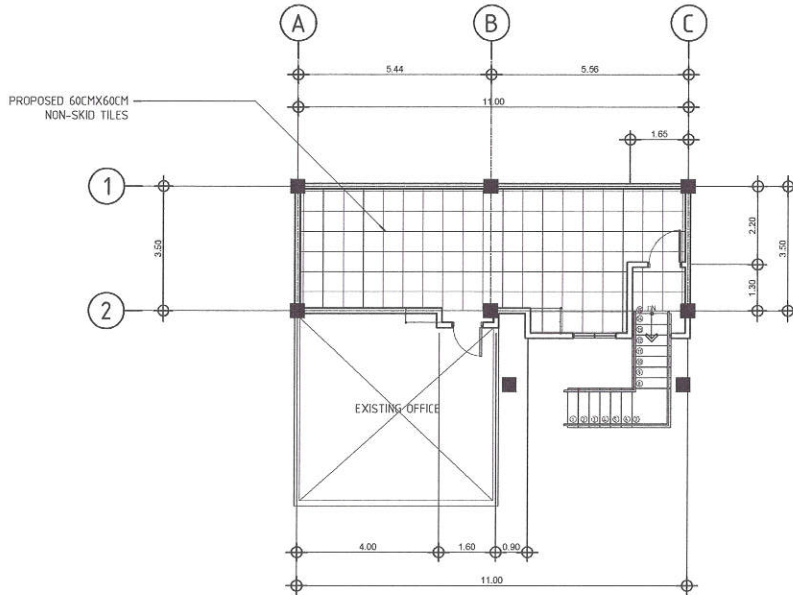

 NOTE:
 PROPOSED REPLACEMENT OF LIGHTING FIXTURES

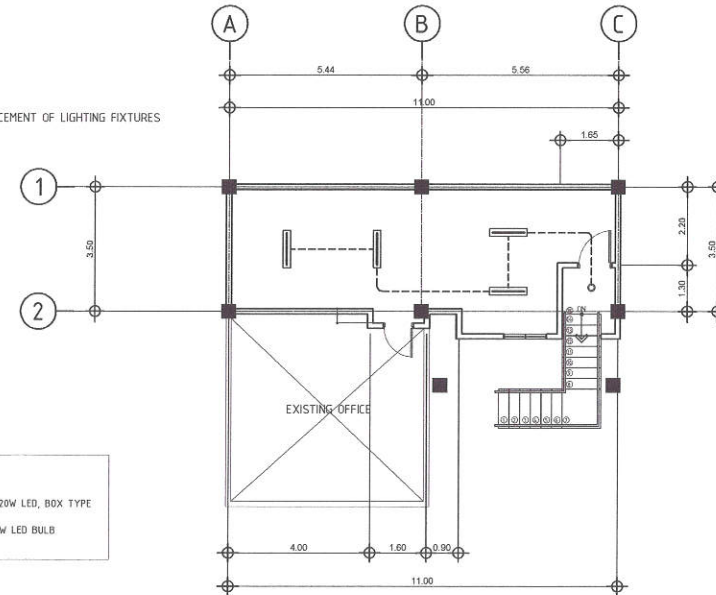

3 PROPOSED SECOND FLOOR PLAN

SCALE : 1:15m

4 LIGHTING LAYOUT

SCALE : 1:15m



Republika ng Pilipinas
 Lungsod ng Quezon
CITY ENGINEERING DEPARTMENT

PROJECT TITLE :
**PROPOSED REHABILITATION OF TWO (2) STOREY
 SUNTAY MULTI-PURPOSE HALL**

LOCATION: BARANGAY KAMUNING, DISTRICT 4, QUEZON CITY

DRAWN BY: *[Signature]*
 DATE: 11/10/2020
 CHECKED BY: *[Signature]*
 REVISION NO.:

SUBMITTED BY:
[Signature]
ENGR. LEO S. DEL ROSARIO
 HEAD, PLANNING & PROGRAMMING DIVISION


RECOMMENDING APPROVAL:
[Signature]
ENGR. ISACANI R. VERZOSA, JR.
 CITY ENGINEERING DEPARTMENT

APPROVED BY:
[Signature]
HON. MA. JOSEFINA G. BELMONTE
 CITY MAYOR, QUEZON CITY


SHEET CONTENT
 ROOF PLAN
 PROPOSED GROUND
 FLOOR PLAN
 PROPOSED SECOND
 FLOOR PLAN
 LIGHTING LAYOUT

SHEET NO.
**AR
 02**

20-00128

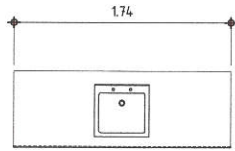


PLAN

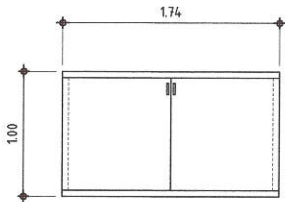


FRONT


D1	LOC: COUNTER
	UNIT: 1
	18mm THK MARINE PLYWOOD, 6mmTHK, BACKBOARD DUCCO PAINT FIN.

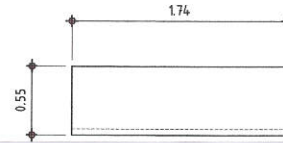

PLAN

 

SIDE

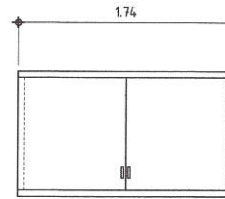

FRONT



D2	LOC: COUNTER
	UNIT: 1
	18mm THK MARINE PLYWOOD, 6mmTHK, BACKBOARD DUCCO PAINT FIN.

1 UNDERCOUNTER CABINET DETAIL

SCALE : N T S

2 OVERHEAD CABINET DETAIL

SCALE : N T S

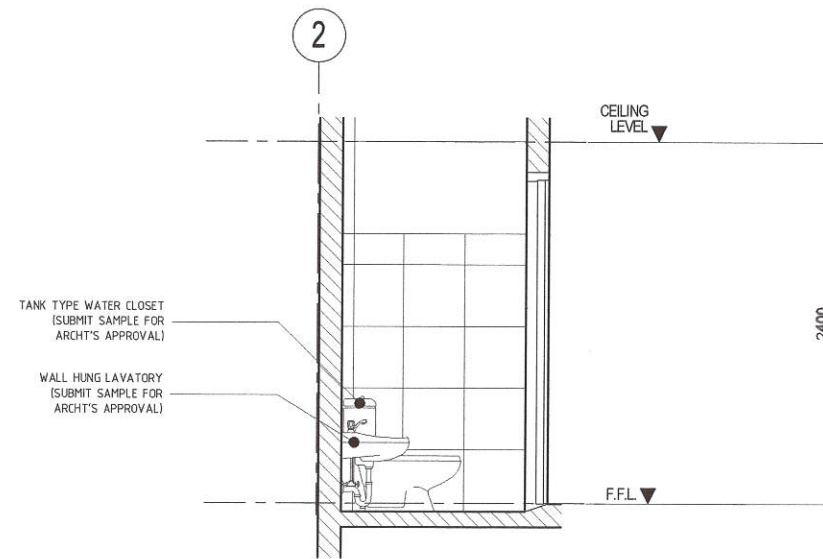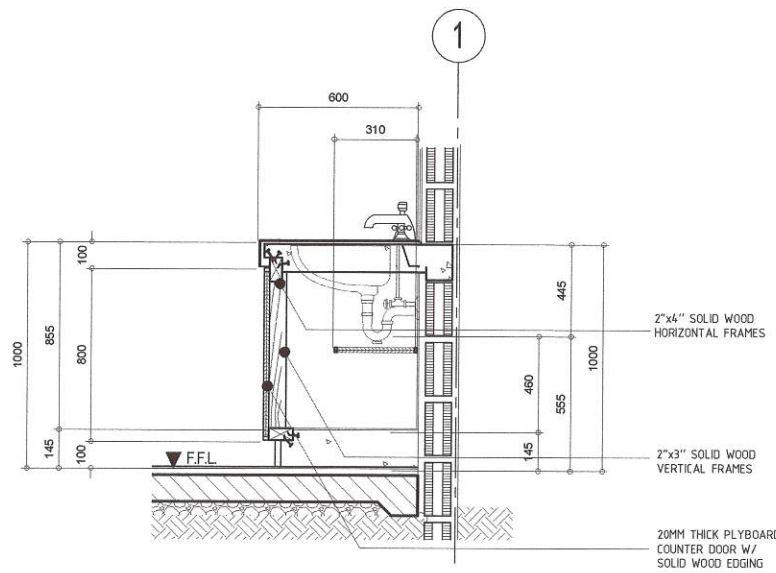

3 SECTION

SCALE : N T S

4 SECTION

SCALE : N T S



Republika ng Pilipinas
Lungsod ng Quezon
CITY ENGINEERING DEPARTMENT

PROJECT TITLE:

PROPOSED REHABILITATION OF TWO (2) STOREY
SUNTAY MULTI-PURPOSE HALL

LOCATION: BARANGAY KAMUNING, DISTRICT 4, QUEZON CITY

DRAWN BY: *Adh*

DATE: 11/10/2020

CHECKED BY: *[Signature]*

REVISION NO.:

SUBMITTED BY:

ENGR. LEO S. DEL ROSARIO
HEAD, PLANNING & PROGRAMMING DIVISION

RECOMMENDING APPROVAL:

ENGR. ISABANI R. VERZOSA, JR.
CIC, CITY ENGINEERING DEPARTMENT

APPROVED BY:

HON. MA. JOSEFINA G. BELMONTE
CITY MAYOR, QUEZON CITY

SHEET CONTENT

UNDERCOUNTER
CABINET DETAIL
OVERHEAD CABINET
DETAIL
SECTION

SHEET NO.

**AR
03**