


1 VICINITY MAP

SCALE: NOT TO SCALE



2 LOCATION MAP

SCALE: NOT TO SCALE

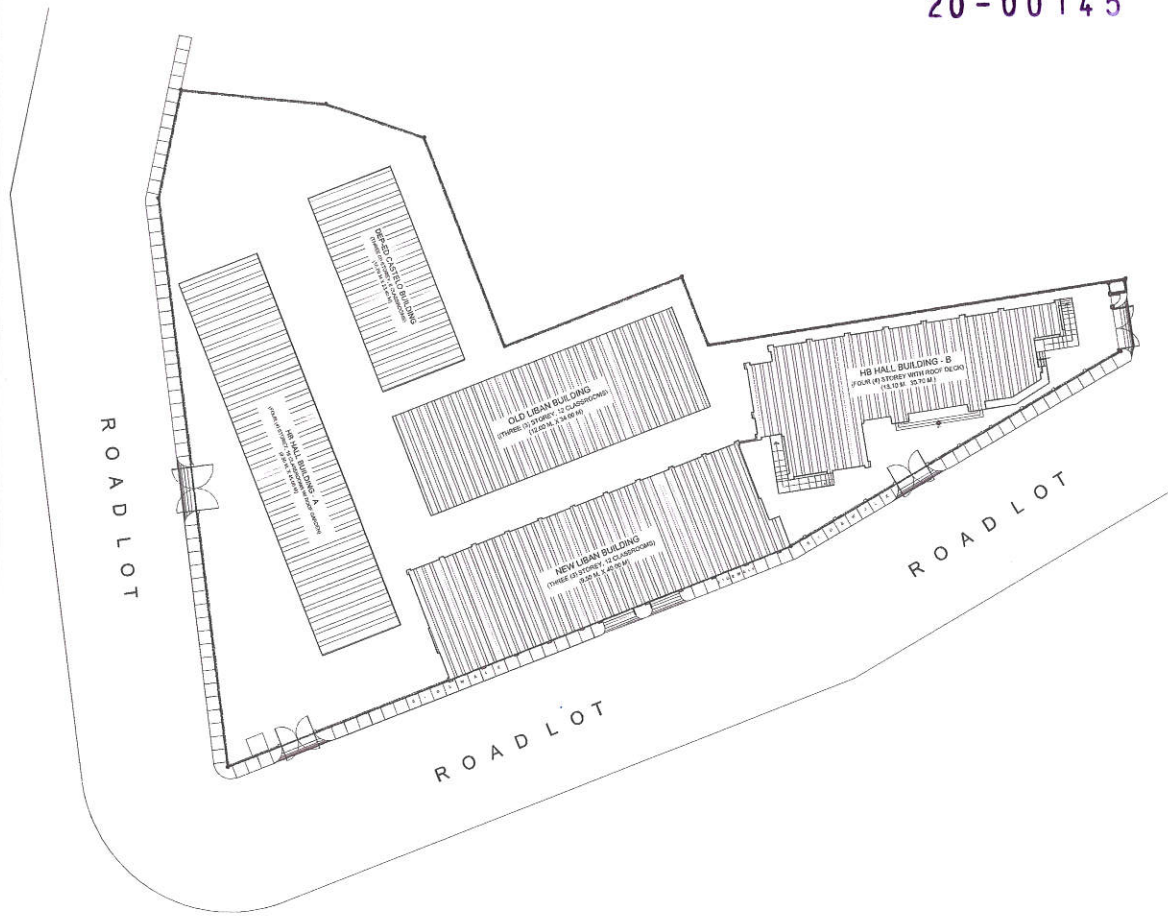

20-00145

3 SITE DEVELOPMENT PLAN

SCALE: NOT TO SCALE

Republika ng Pilipinas
Lungsod ng Quezon
CITY ENGINEERING DEPARTMENT

PROJECT TITLE :	DRAWN BY : DEXTER
PROPOSED REHABILITATION OF PAYATAS B ELEMENTARY SCHOOL	DATE : NOV. 17, 2020
	CHECKED BY : <i>[Signature]</i>
BARANGAY PAYATAS, DISTRICT-2, QUEZON CITY	REVISION NO.:

SUBMITTED BY :

[Signature]

ENGR. VEO S. DEL ROSARIO
HEAD, PLANNING & PROGRAMMING DIVISION

RECOMMENDING APPROVAL :

[Signature]


ENGR. ISAGANI R. VERZOSA, JR.
OIC, CITY ENGINEERING DEPARTMENT

APPROVED BY :

[Signature]

HON. MA. JOSEFINA G. BELMONTE
CITY MAYOR, QUEZON CITY


SHEET CONTENT	SHEET NO.
VICINITY MAP, LOCATION MAP AND SITE DEVELOPMENT PLAN (PAYATAS B ELEMENTARY SCHOOL)	AR 1

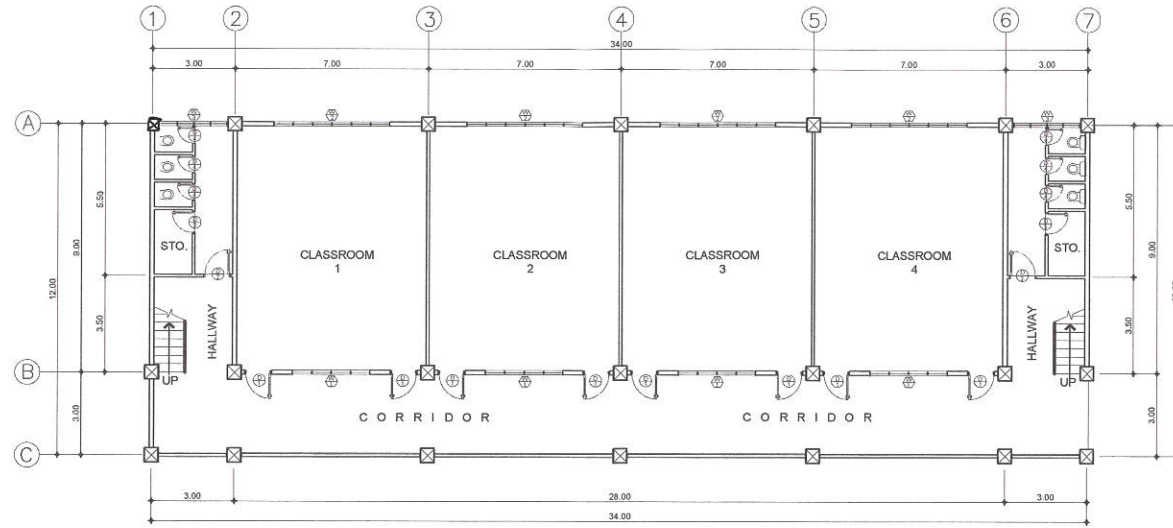

20-00145


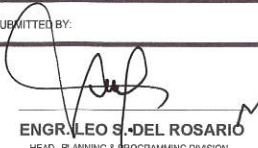


1 GROUND FLOOR PLAN (OLD LIBAN BUILDING)

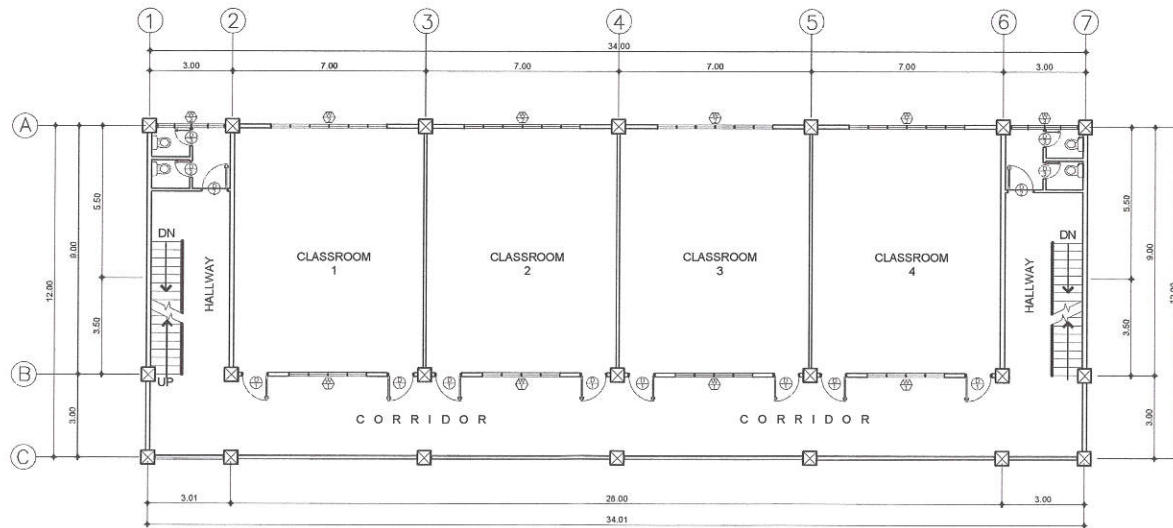SCALE: 1:200 METERS




2 SECOND FLOOR PLAN (OLD LIBAN BUILDING)

SCALE: 1:200 METERS


 <p>Republika ng Pilipinas Lungsod ng Quezon CITY ENGINEERING DEPARTMENT</p>	PROJECT TITLE :	DRAWN BY : DEXTER	SUBMITTED BY :	RECOMMENDING APPROVAL :	APPROVED BY :	SHEET CONTENT	SHEET NO.
	<p>PROPOSED REHABILITATION OF PAYATAS B ELEMENTARY SCHOOL</p> <p>BARANGAY PAYATAS, DISTRICT-2, QUEZON CITY</p>	DATE : NOV. 17, 2020	 <p>ENGR. LEO S. DEL ROSARIO HEAD, PLANNING & PROGRAMMING DIVISION</p>	 <p>ENGR. ISAGANI R. VERZOSA, JR. OIC, CITY ENGINEERING DEPARTMENT</p>	<p>HON. MA. JOSEFINA G. BELMONTE CITY MAYOR, QUEZON CITY</p>	<p>GROUND FLOOR PLAN & SECOND FLOOR PLAN (OLD LIBAN BUILDING)</p>	
		CHECKED BY :					

20-00145

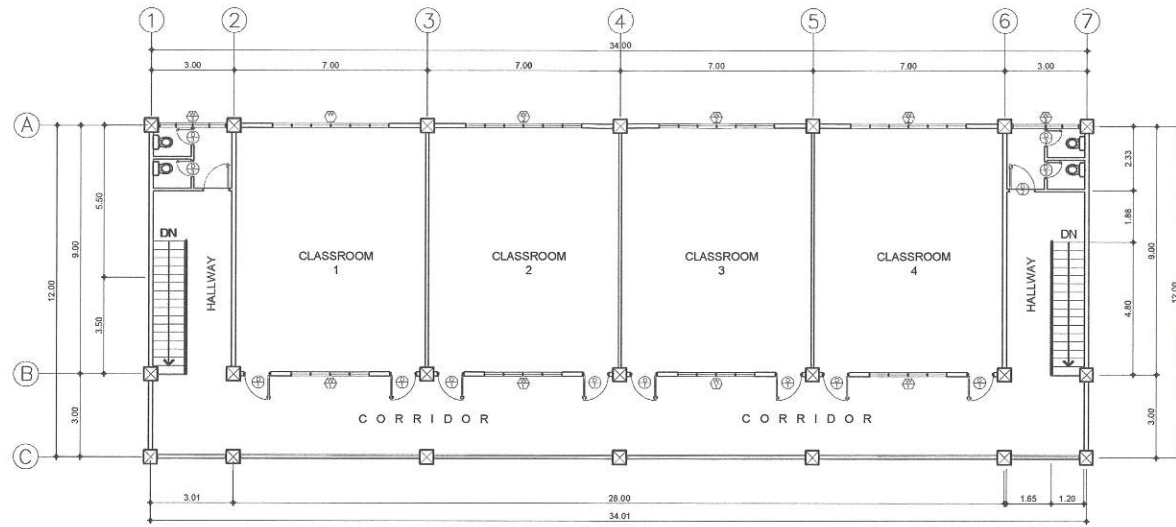

1 THIRD FLOOR PLAN (OLD LIBAN BUILDING)

SCALE: 1:200 METERS

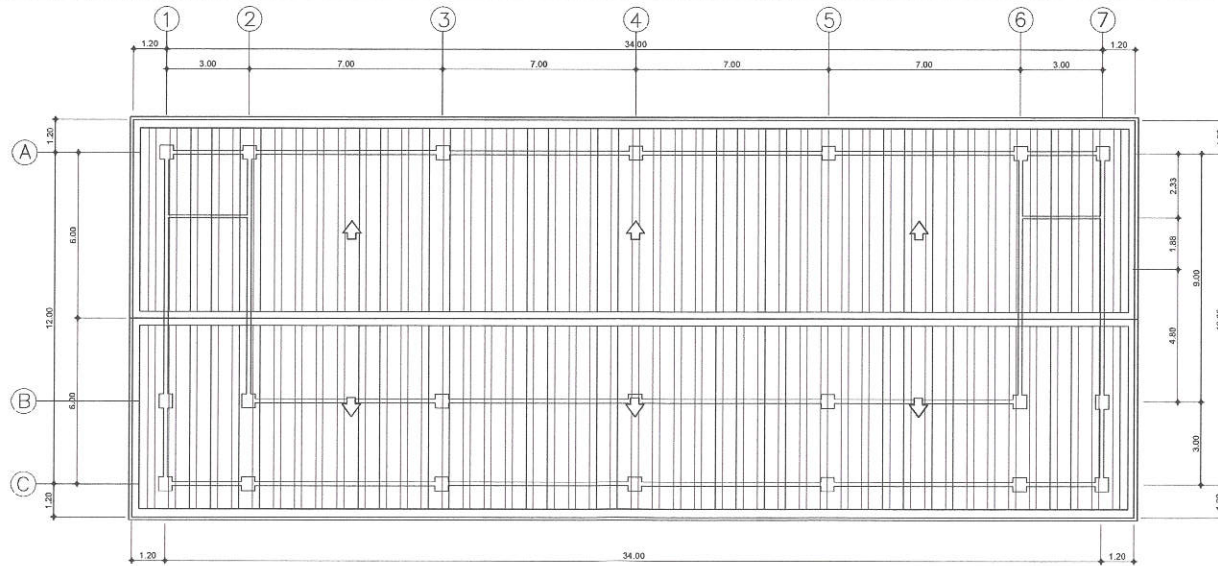

2 ROOF PLAN (OLD LIBAN BUILDING)


SCALE: 1:200 METERS



Republika ng Pilipinas
Lungsod ng Quezon
CITY ENGINEERING DEPARTMENT


PROJECT TITLE :	DRAWN BY : DEXTER	SUBMITTED BY :	RECOMMENDING APPROVAL :	APPROVED BY :	SHEET CONTENT	SHEET NO.
PROPOSED REHABILITATION OF PAYATAS B ELEMENTARY SCHOOL	DATE : NOV. 17, 2020	 ENGR. LEO S. DEL ROSARIO HEAD, PLANNING & PROGRAMMING DIVISION	 ENGR. ISAGANI R. VERZOSA, JR. OIC, CITY ENGINEERING DEPARTMENT	HON. MA. JOSEFINA G. BELMONTE CITY MAYOR, QUEZON CITY	THIRD FLOOR PLAN AND ROOF PLAN (OLD LIBAN BUILDING)	
	CHECKED BY :					
BARANGAY PAYATAS, DISTRICT-2, QUEZON CITY						

20-00145

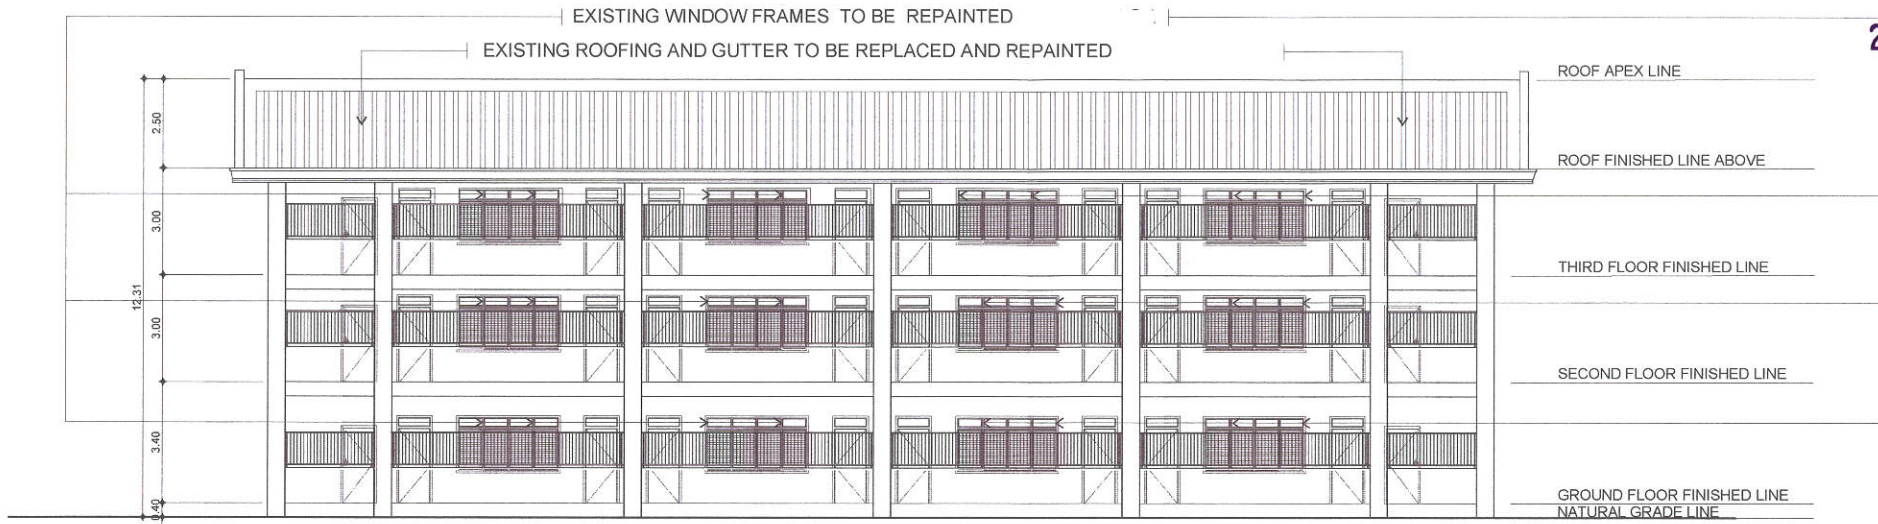



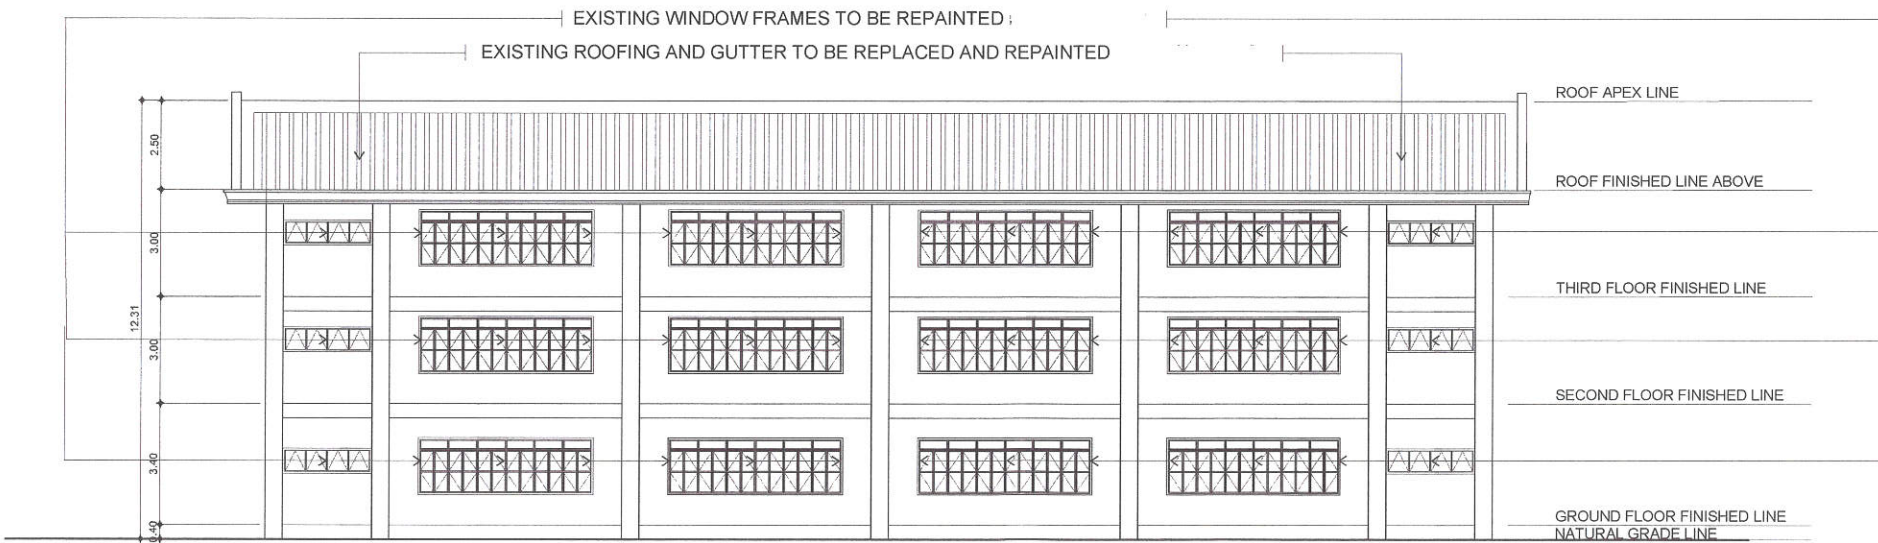


1 FRONT ELEVATION (OLD LIBAN BUILDING)

SCALE: 1:150 METERS




2 REAR ELEVATION (OLD LIBAN BUILDING)

SCALE: 1:150 METERS


 <p>Republika ng Pilipinas Lungsod ng Quezon CITY ENGINEERING DEPARTMENT</p>	PROJECT TITLE :	DRAWN BY : DEXTER	SUBMITTED BY :	RECOMMENDING APPROVAL :	APPROVED BY :	SHEET CONTENT	SHEET NO.
	<p>PROPOSED REHABILITATION OF PAYATAS B ELEMENTARY SCHOOL</p> <p>BARANGAY PAYATAS, DISTRICT-2, QUEZON CITY</p>	DATE : NOV. 17, 2020	 <p>ENGR. LEO S. DEL ROSARIO HEAD, PLANNING & PROGRAMMING DIVISION</p>	 <p>ENGR. ISAGANI R. VERZOSA, JR. OIC, CITY ENGINEERING DEPARTMENT</p>	<p>HON. MA. JOSEFINA G. BELMONTE CITY MAYOR, QUEZON CITY</p>	<p>FRONT ELEVATION REAR ELEVATION (OLD LIBAN BUILDING)</p>	
		CHECKED BY : 					

20-00145

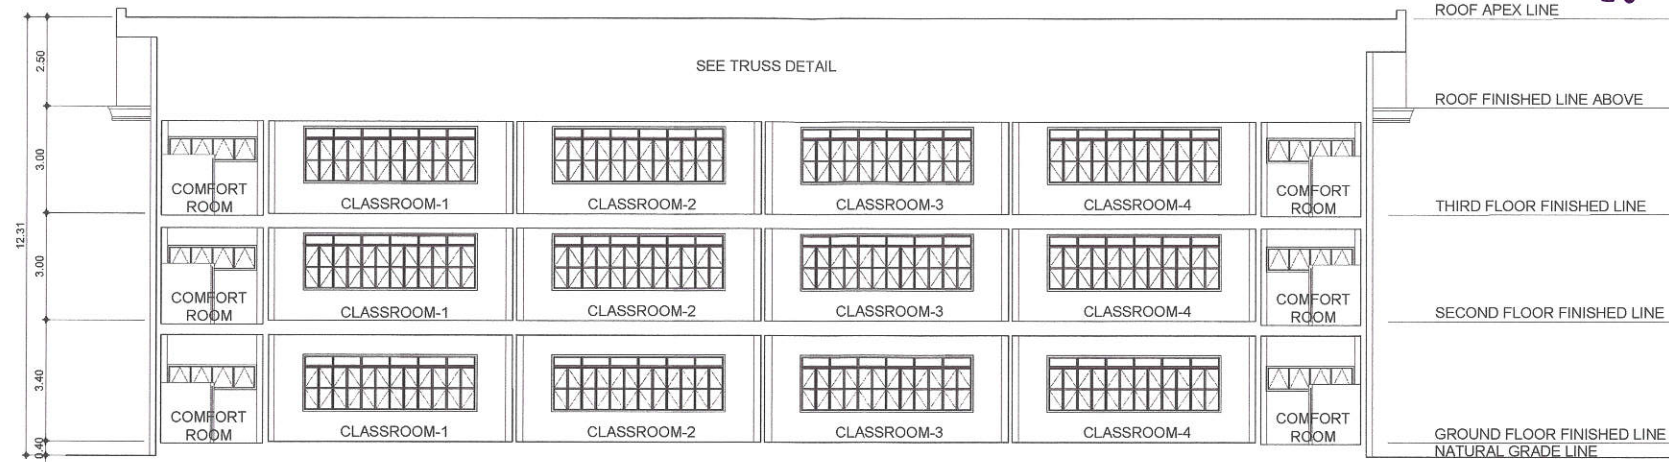


1 LONGITUDINAL SECTION (OLD LIBAN BUILDING)

SCALE : 1 : 150 METERS

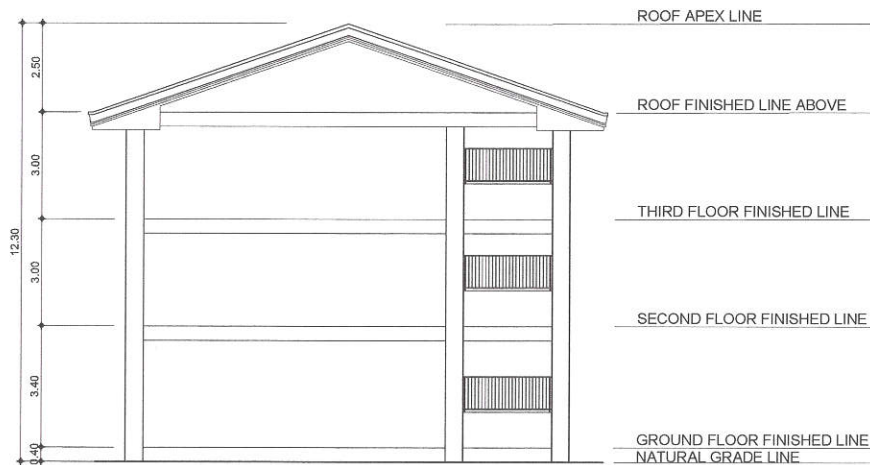


2 SIDE ELEVATION (OLD LIBAN BUILDING)

SCALE : 1 : 150 METERS

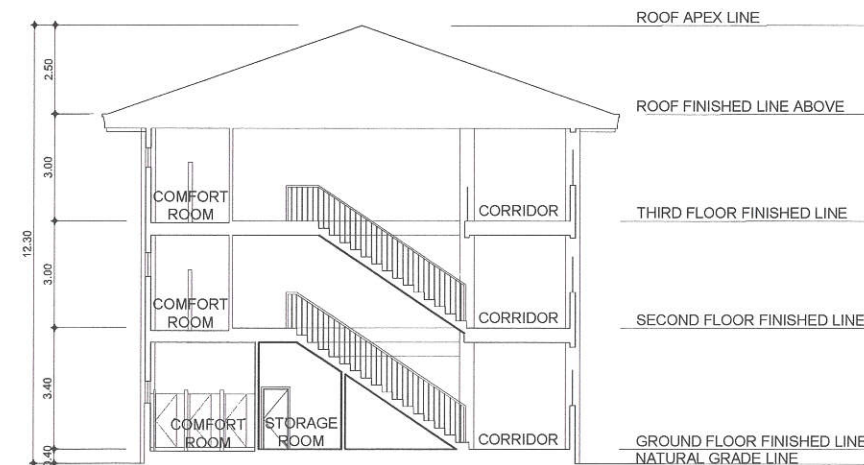

3 CROSS SECTION (OLD LIBAN BUILDING)

 SCALE : 1 : 150 METERS



Republika ng Pilipinas
Lungsod ng Quezon
CITY ENGINEERING DEPARTMENT

PROJECT TITLE :	DRAWN BY : DEXTER
PROPOSED REHABILITATION OF PAYATAS B ELEMENTARY SCHOOL	DATE : NOV. 17, 2020
	CHECKED BY:
BARANGAY PAYATAS, DISTRICT-2, QUEZON CITY	REVISION NO.:


SUBMITTED BY:
ENGR. LEO S. DEL ROSARIO HEAD, PLANNING & PROGRAMMING DIVISION

RECOMMENDING APPROVAL :
ENGR. ISAGANI R. VERZOSA, JR. OIC, CITY ENGINEERING DEPARTMENT


APPROVED BY :
HON. MA. JOSEFINA G. BELMONTE CITY MAYOR, QUEZON CITY

SHEET CONTENT
LONGITUDINAL SECTION, REAR ELEVATION CROSS SECTION (OLD LIBAN BUILDING)


SHEET NO.
AR 5

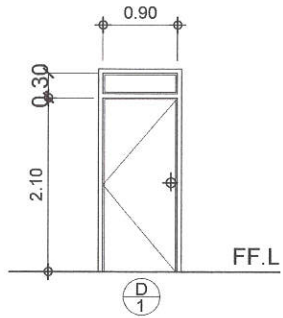

TYPE : PANEL DOOR W/ TRANSOM
 LOCATION: CLASSROOMS
 DOOR KNOB TO BE REPLACED

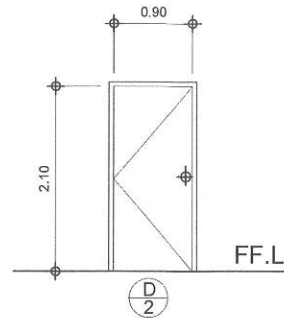

TYPE : FLUSH DOOR
 LOCATION : COMFORT ROOMS

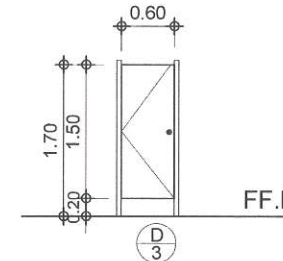


TYPE : FLUSH DOOR (SWING TYPE)
 LOCATION : COMFORT ROOMS


20-00145

1 SCHEDULE OF DOORS (OLD LIBAN BUILDING)


SCALE : 1 : 60 METERS

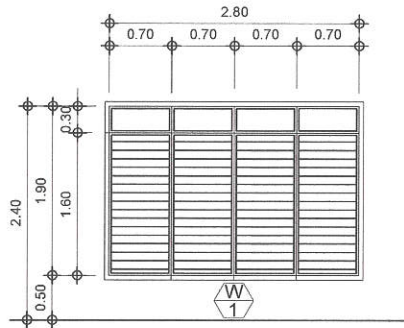

TYPE : JALOUSIE WINDOW W/ TRANSOM
 LOCATION: CLASSROOMS
 REPLACE BROKEN GLASSES :

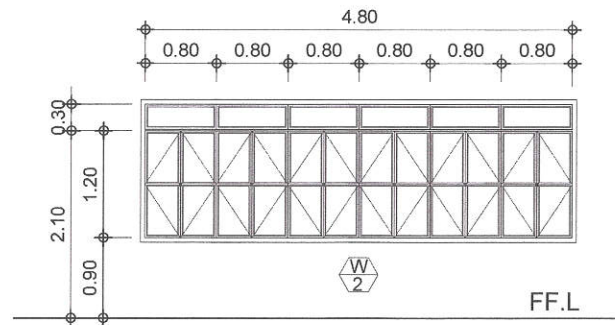



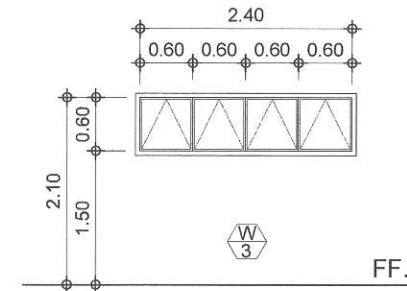


TYPE : STEEL CASEMENT W/ TRANSOM
 LOCATION: CLASSROOMS
 REPLACE BROKEN GLASSES



TYPE : AWNING WITH GRILLES
 LOCATION: COMFORT ROOMS

 
2 SCHEDULE OF WINDOWS (OLD LIBAN BUILDING)

SCALE : 1 : 60 METERS

 <p>Republika ng Pilipinas Lungsod ng Quezon CITY ENGINEERING DEPARTMENT</p>	PROJECT TITLE :	DRAWN BY : DEXTER	SUBMITTED BY :	RECOMMENDING APPROVAL :	APPROVED BY :	SHEET CONTENT	SHEET NO.
	PROPOSED REHABILITATION OF PAYATAS B ELEMENTARY SCHOOL BARANGAY PAYATAS, DISTRICT-2, QUEZON CITY	DATE : NOV. 17, 2020	 ENGR. LEO S. DEL ROSARIO HEAD, PLANNING & PROGRAMMING DIVISION	 ENGR. ISAGANI R. VERZOSA, JR. OIC, CITY ENGINEERING DEPARTMENT	 HON. MA. JOSEFINA G. BELMONTE CITY MAYOR, QUEZON CITY	SCHEDULE OF DOORS (OLD LIBAN BUILDING) AND SCHEDULE OF WINDOWS (OLD LIBAN BUILDING)	
		CHECKED BY :					

EXISTING DOORS TO BE REPAINTED,
REPLACED DOOR KNOBS AT BOLTS

EXISTING WALLS TO BE
REPAINTED



REPLACEMENT
OF FLOOR TILES




EXISTING STAIR STEEL
GRILLES TO BE REPAINTED

EXISTING WINDOW FRAMES TO BE
REPLACED, REPAINTED

EXISTING ELECTRICAL
FIXTURES TO BE REPLACED

20-00145




EXISTING WALLS TO BE
REPAINTED

1 OLD LIBAN BUILDING (HALLWAY)

2 OLD LIBAN BUILDING (STAIRS)

3 OLD LIBAN BUILDING (CLASSROOM)

EXISTING PLUMBING
FIXTURES TO BE REPLACED




REPLACEMENT
OF FLOOR TILES

EXISTING PLUMBING
FIXTURES TO BE REPLACED

EXISTING DOORS TO BE REPAINTED,
REPLACED DOOR KNOBS AT BOLTS






EXISTING WINDOW AND FRAMES TO BE
REPLACED, REPAINTED




4 OLD LIBAN BLDG. (COMFORT ROOM)

5 OLD LIBAN BLDG. (COMFORT ROOM)


6 OLD LIBAN BLDG. (COMFORT ROOM)

 <p>Republika ng Pilipinas Lungsod ng Quezon CITY ENGINEERING DEPARTMENT</p>	PROJECT TITLE :	DRAWN BY : DEXTER	SUBMITTED BY :	RECOMMENDING APPROVAL :	APPROVED BY :	SHEET CONTENT	SHEET NO.	
	<p>PROPOSED REHABILITATION OF PAYATAS B ELEMENTARY SCHOOL</p> <p>BARANGAY PAYATAS, DISTRICT-2, QUEZON CITY</p>	DATE : NOV. 17, 2020	 <p>ENGR. LEO S. DEL ROSARIO HEAD, PLANNING & PROGRAMMING DIVISION</p>	 <p>ENGR. SAGANI R. VERZOSA, JR. OIC, CITY ENGINEERING DEPARTMENT</p>	<p>HON. MA. JOSEFINA G. BELMONTE CITY MAYOR, QUEZON CITY</p>	<p>OLD LIBAN BLDG. (HALLWAY), OLD LIBAN BLDG. (STAIRS), OLD LIBAN BLDG. (CLASSRM), OLD LIBAN BUILDING (CR), OLD LIBAN BUILDING (CR), & OLD LIBAN BUILDING (CR)</p>		
		CHECKED BY :						REVISION NO.:

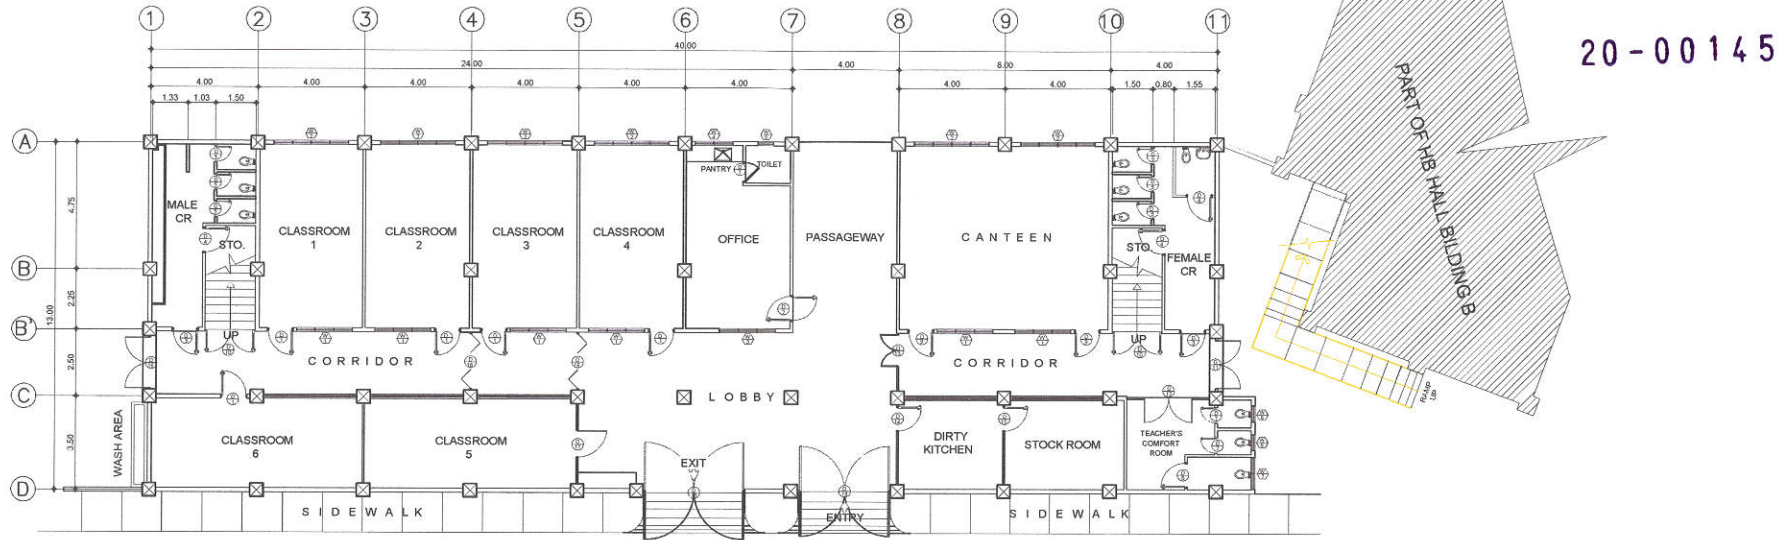

1 GROUND FLOOR PLAN (NEW LIBAN BUILDING)

SCALE: 1:200 METERS

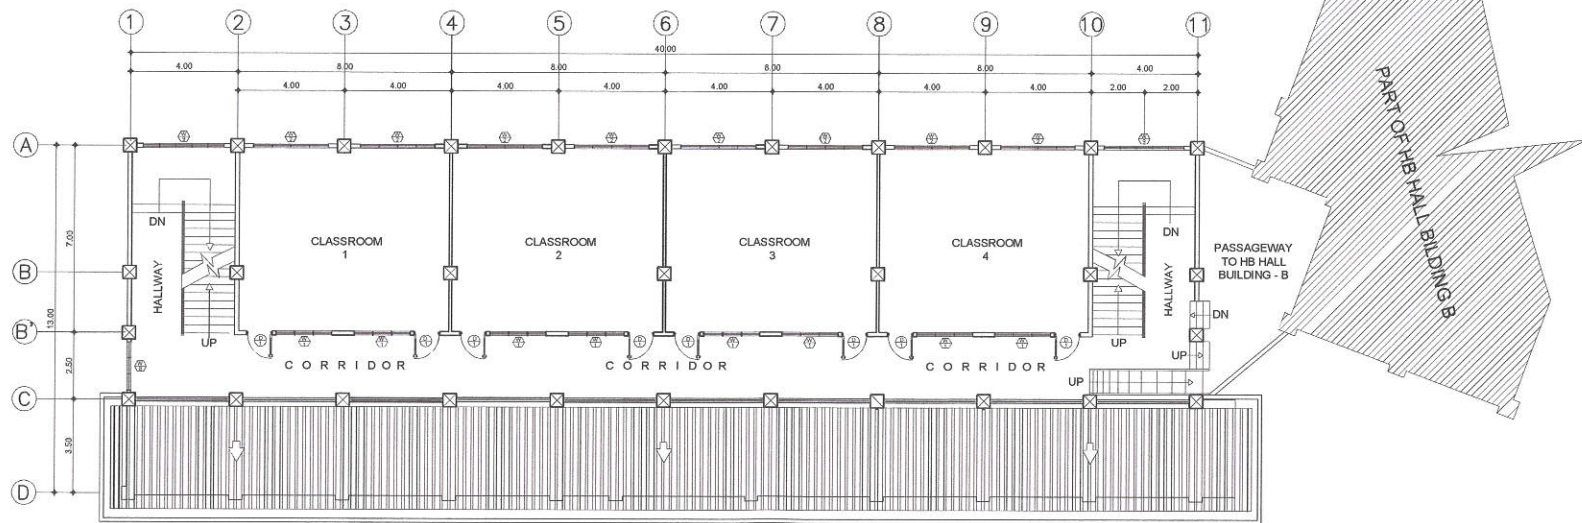

2 SECOND FLOOR PLAN (NEW LIBAN BUILDING)

SCALE : 1 : 200 MTS



Republika ng Pilipinas
Lungsod ng Quezon
CITY ENGINEERING DEPARTMENT

PROJECT TITLE :
**PROPOSED REHABILITATION OF
PAYATAS B ELEMENTARY SCHOOL**
BARANGAY PAYATAS, DISTRICT-2, QUEZON CITY

DRAWN BY : DEXTER
DATE : NOV. 17, 2020
CHECKED BY :
REVISION NO.:

SUBMITTED BY:

ENGR. LEO S. DEL ROSARIO
HEAD, PLANNING & PROGRAMMING DIVISION

RECOMMENDING APPROVAL :

ENGR. SABANI R. VERZOSA, JR.
OIC, CITY ENGINEERING DEPARTMENT

APPROVED BY :


HON. MA. JOSEFINA G. BELMONTE
CITY MAYOR, QUEZON CITY

SHEET CONTENT
GROUND FLOOR PLAN &
SECOND FLOOR PLAN
(NEW LIBAN BUILDING)

SHEET NO.


AR
8

20-00145

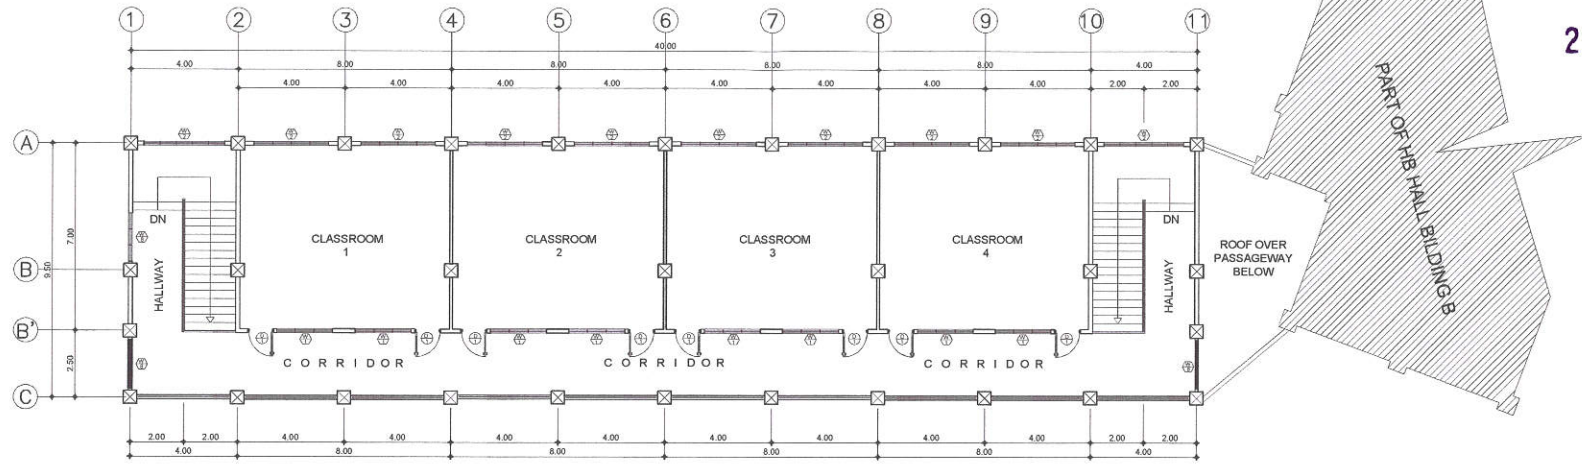

1 THIRD FLOOR PLAN (NEW LIBAN BUILDING)

SCALE: 1:200 METERS

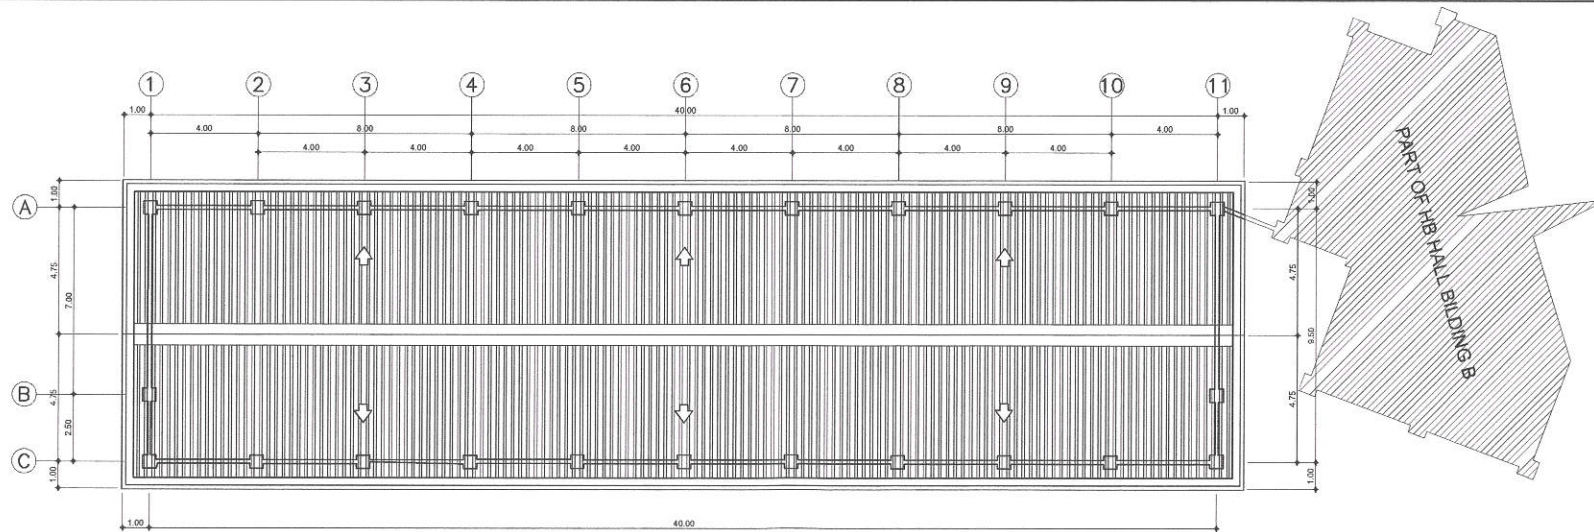


2 ROOF PLAN (NEW LIBAN BUILDING)

SCALE : 1 : 200 MTS



Republika ng Pilipinas
Lungsod ng Quezon
CITY ENGINEERING DEPARTMENT


PROJECT TITLE :	DRAWN BY : DEXTER	SUBMITTED BY :	RECOMMENDING APPROVAL :	APPROVED BY :	SHEET CONTENT	SHEET NO.
PROPOSED REHABILITATION OF PAYATAS B ELEMENTARY SCHOOL	DATE : NOV. 17, 2020	 ENGR. LEO S. DEL ROSARIO HEAD, PLANNING & PROGRAMMING DIVISION	 ENGR. ISAGANI R. VERZOSA, JR. OIC, CITY ENGINEERING DEPARTMENT	 HON. MA. JOSEFINA G. BELMONTE CITY MAYOR, QUEZON CITY	THIRD FLOOR PLAN AND ROOF PLAN (NEW LIBAN BUILDING)	AR 9
	CHECKED BY : 					

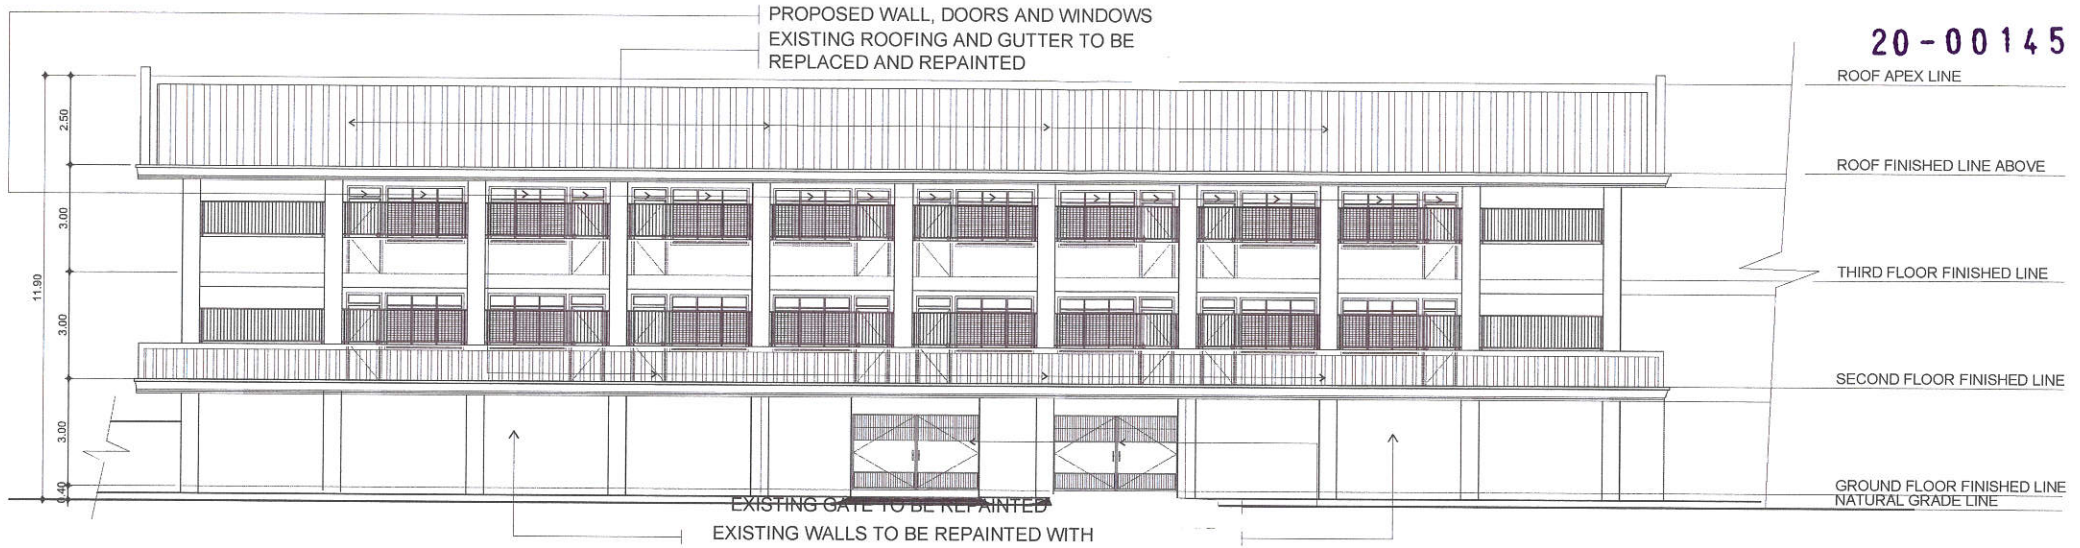

20-00145


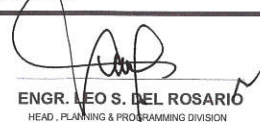
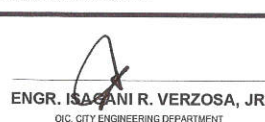

1 FRONT ELEVATION (NEW LIBAN BUILDING)

SCALE: 1:150 METERS

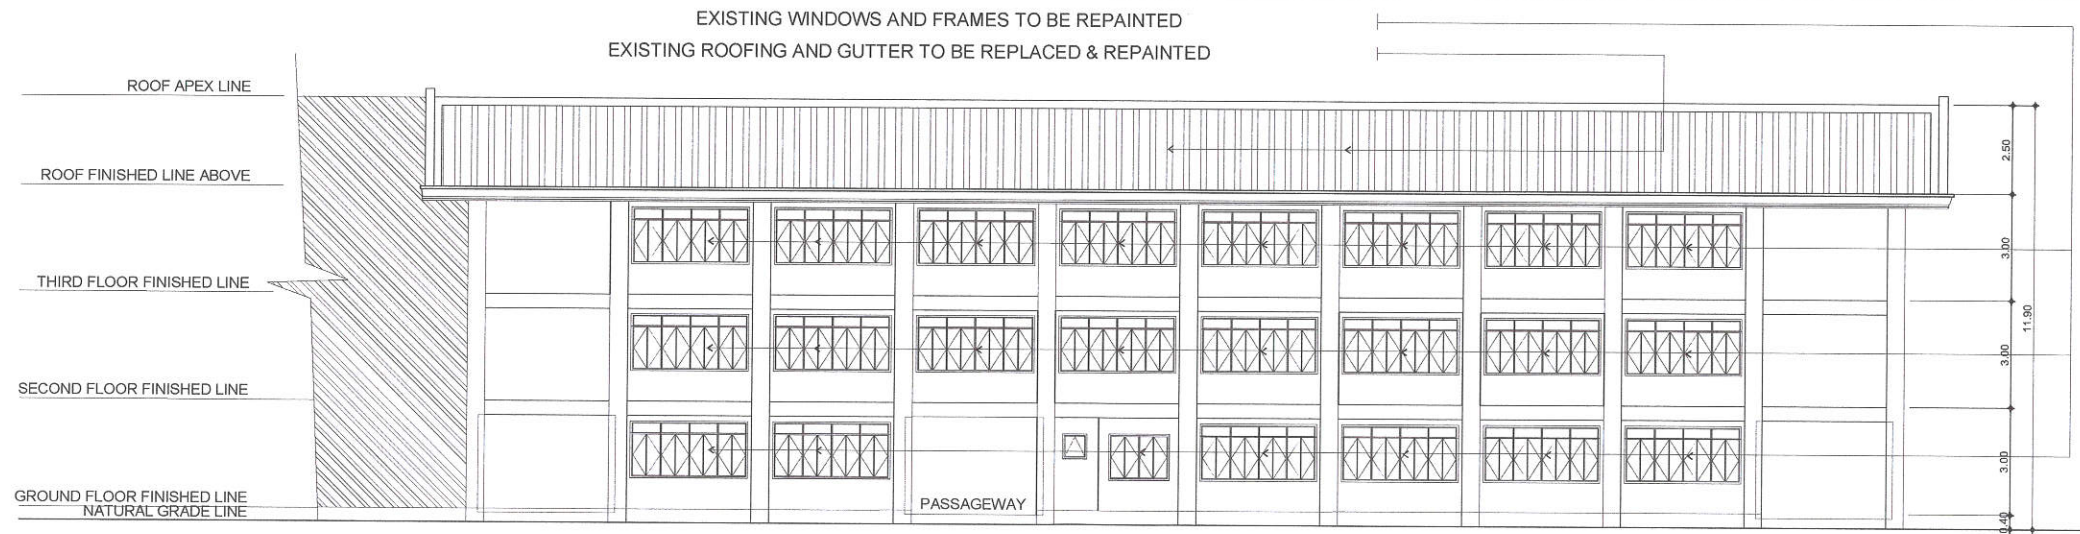


2 REAR ELEVATION (NEW LIBAN BUILDING)

SCALE: 1:150 METERS


 <p>Republika ng Pilipinas Lungsod ng Quezon CITY ENGINEERING DEPARTMENT</p>	PROJECT TITLE :	DRAWN BY : DEXTER	SUBMITTED BY :	RECOMMENDING APPROVAL :	APPROVED BY :	SHEET CONTENT	SHEET NO.
	<p>PROPOSED REHABILITATION OF PAYATAS B ELEMENTARY SCHOOL</p> <p>BARANGAY PAYATAS, DISTRICT-2, QUEZON CITY</p>	DATE : NOV. 17, 2020	 <p>ENGR. LEO S. DEL ROSARIO HEAD, PLANNING & PROGRAMMING DIVISION</p>	 <p>ENGR. ISAGANI R. VERZOSA, JR. CIC, CITY ENGINEERING DEPARTMENT</p>	<p>HON. MA. JOSEFINA G. BELMONTE CITY MAYOR, QUEZON CITY</p>	<p>FRONT ELEVATION AND REAR ELEVATION (NEW LIBAN BUILDING)</p>	
		CHECKED BY : ✓					

20-00145

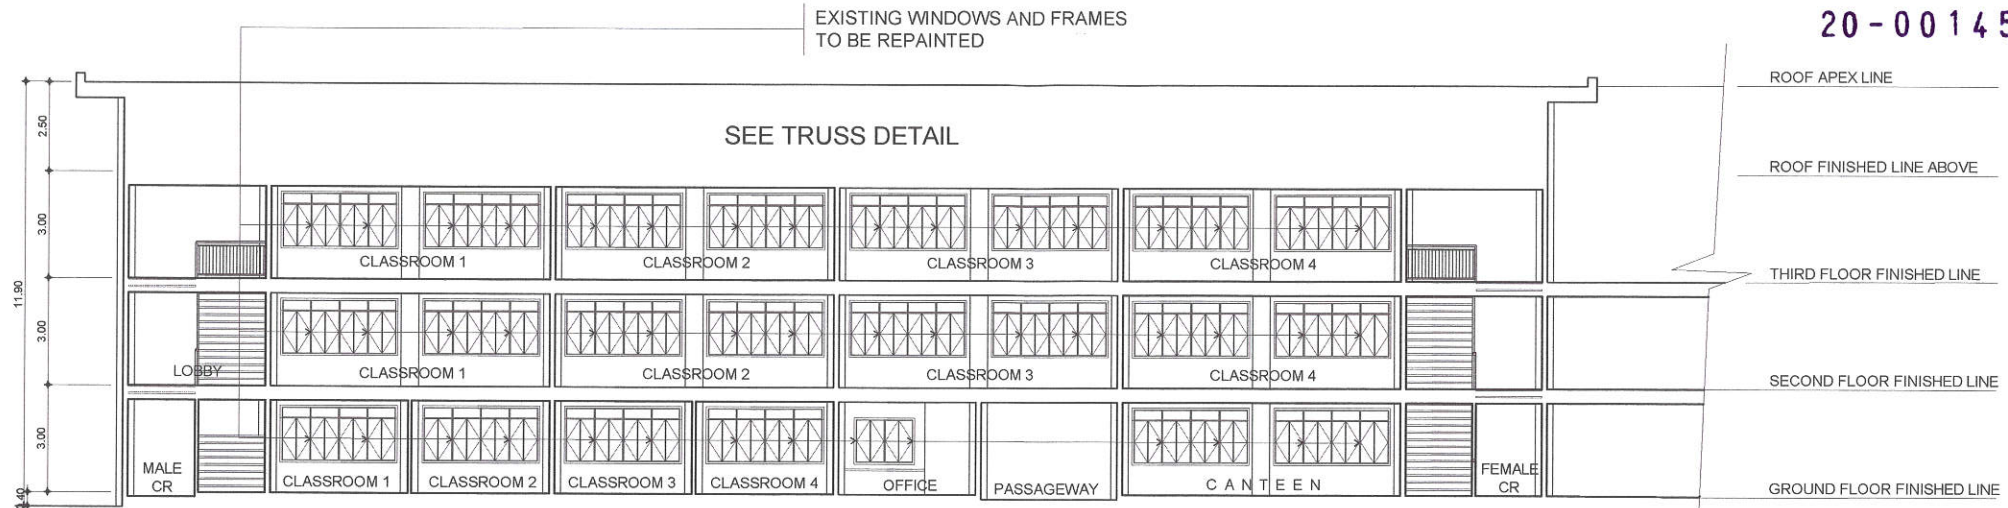


1 LONGITUDINAL SECTION (NEW LIBAN BUILDING)

SCALE: 1:150 METERS

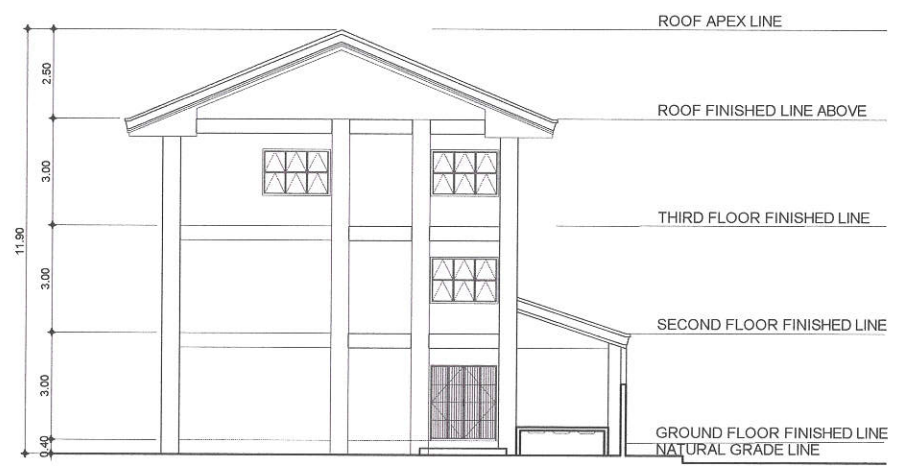


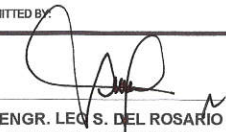


2 SIDE ELEVATION (NEW LIBAN BUILDING)

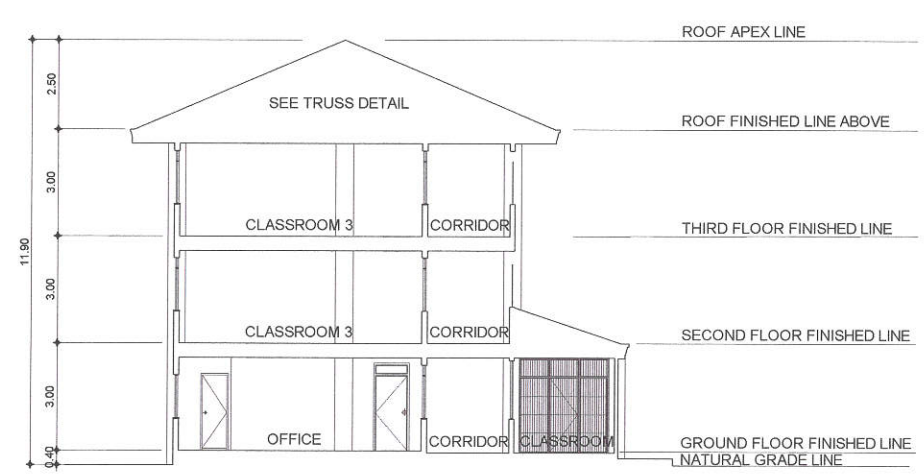SCALE: 1:150 METERS




3 CROSS SECTION (NEW LIBAN BUILDING)

SCALE: 1:150 METERS


 <p>Republika ng Pilipinas Lungsod ng Quezon CITY ENGINEERING DEPARTMENT</p>	PROJECT TITLE :	DRAWN BY : DEXTER	SUBMITTED BY :	RECOMMENDING APPROVAL :	APPROVED BY :	SHEET CONTENT	SHEET NO.
	<p>PROPOSED REHABILITATION OF PAYATAS B ELEMENTARY SCHOOL</p> <p>BARANGAY PAYATAS, DISTRICT-2, QUEZON CITY</p>	DATE : NOV. 17, 2020	 ENGR. LEO S. DEL ROSARIO HEAD, PLANNING & PROGRAMMING DIVISION	 ENGR. ISAGANI R. VERZOSA, JR. OIC, CITY ENGINEERING DEPARTMENT	HON. MA. JOSEFINA G. BELMONTE CITY MAYOR, QUEZON CITY	LONGITUDINAL SECTION, SIDE ELEVATION AND CROSS SECTION (NEW LIBAN BUILDING)	
		CHECKED BY : ✓					

20-00145

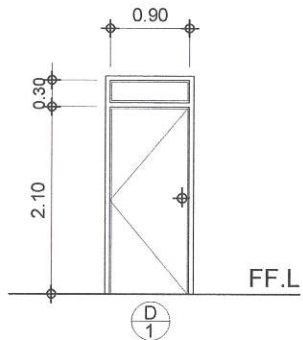


TYPE : PANEL DOOR W/ TRANSOM
LOCATION : CLASSROOMS

DOOR KNOB TO BE REPLACED

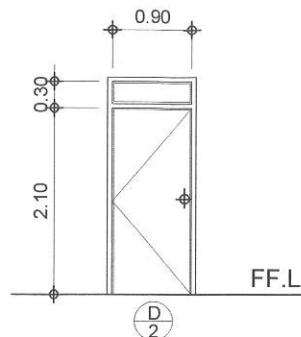

TYPE : FLUSH DOOR W/ TRANSOM
LOCATION : OFFICE


DOOR KNOB TO BE REPLACED

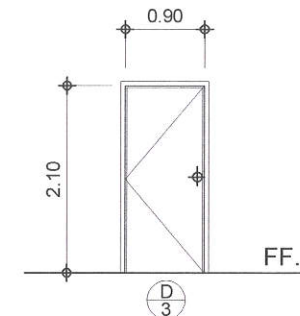


TYPE : FLUSH DOOR
LOCATION : COMFORT ROOMS

1 SCHEDULE OF DOORS (NEW LIBAN BUILDING)


SCALE :1 : 60 METERS

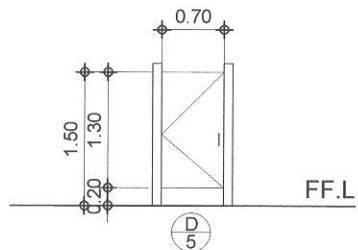


TYPE : FLUSH DOOR
LOCATION : COMFORT ROOMS (CUBICLE)

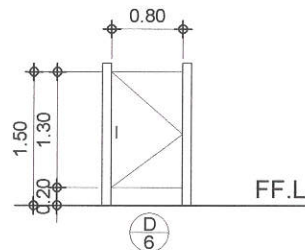

TYPE : FLUSH DOOR
LOCATION : COMFORT ROOMS (PWD-CUBICLE)

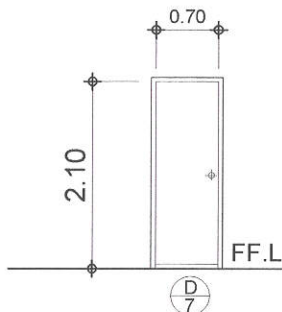

TYPE : FLUSH DOOR
LOCATION : TEACHER'S COMFORT ROOM

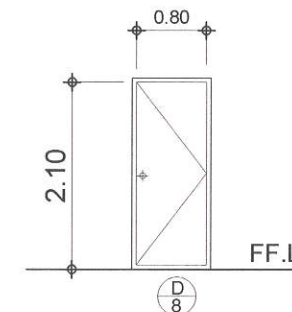

TYPE : FLUSH DOOR
LOCATION : TEACHER'S COMFORT ROOM

2 SCHEDULE OF WINDOWS (NEW LIBAN BUILDING)


SCALE :1 : 60 METERS




Republika ng Pilipinas
Lungsod ng Quezon
CITY ENGINEERING DEPARTMENT

PROJECT TITLE :	DRAWN BY : DEXTER	SUBMITTED BY :	RECOMMENDING APPROVAL :	APPROVED BY :	SHEET CONTENT	SHEET NO.
PROPOSED REHABILITATION OF PAYATAS B ELEMENTARY SCHOOL	DATE : NOV. 17, 2020	 ENGR. LEO S. DEL ROSARIO HEAD, PLANNING & PROGRAMMING DIVISION	 ENGR. ISAGANI R. VERZOSA, JR. OIC, CITY ENGINEERING DEPARTMENT	HON. MA. JOSEFINA G. BELMONTE CITY MAYOR, QUEZON CITY	SCHEDULE OF DOORS (NEW LIBAN BUILDING)	
	CHECKED BY :					
BARANGAY PAYATAS, DISTRICT-2, QUEZON CITY						


20-00145

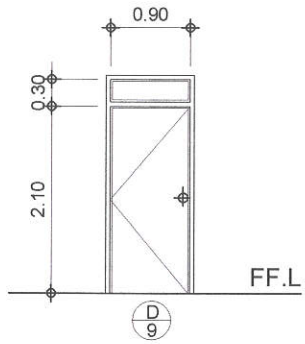


TYPE : GLASS DOOR W/ TRANSM (ALUMINUM FRAME)
 LOCATION : CANTEEN
 DOOR KNOB TO BE REPLACED

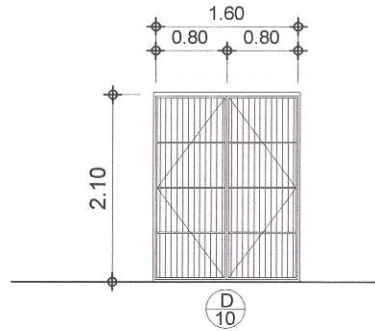

TYPE : IRON STEEL DOOR
 LOCATION : STAIRS TO SECOND FLOOR
 TO BE REPAINTED

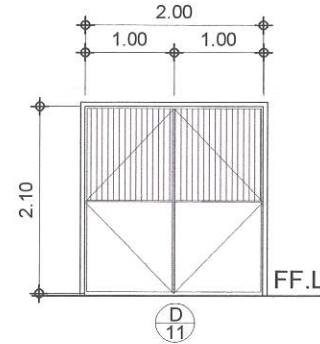


TYPE : IRON STEEL DOOR
 LOCATION : GATE TO HB HALL BUILDING B
 TO BE REPAINTED

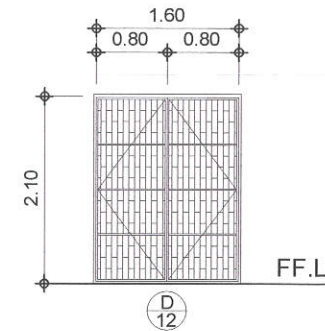


TYPE : IRON STEEL DOOR
 LOCATION : TEACHER'S COMFORT ROOM
 TO BE REPAINTED

1 SCHEDULE OF DOORS (NEW LIBAN BUILDING)


SCALE: 1:60 METERS

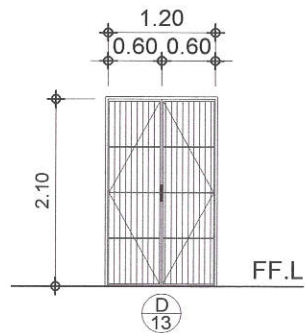

TYPE : IRON STEEL DOOR
 LOCATION : CORRIDOR NEAR CANTEEN
 TO BE REPAINTED

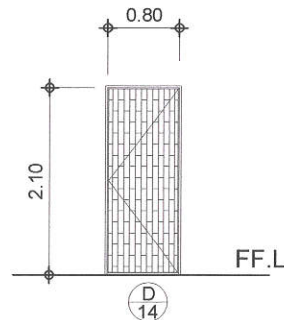


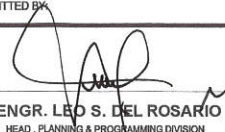


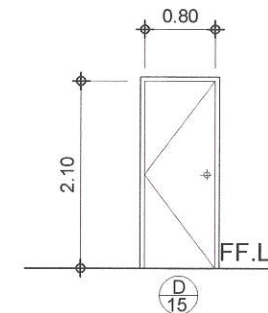TYPE : IRON STEEL DOOR
 LOCATION : DIRTY KITCHEN
 TO BE REPAINTED




TYPE : FLUSH DOOR
 LOCATION : STOCK ROOM
 NEAR DIRTY KITCHEN
 DOOR KNOB TO BE REPLACED


2 SCHEDULE OF DOORS (NEW LIBAN BUILDING)

SCALE: 1:60 METERS

 <p>Republika ng Pilipinas Lungsod ng Quezon CITY ENGINEERING DEPARTMENT</p>	PROJECT TITLE :	DRAWN BY : DEXTER	SUBMITTED BY :	RECOMMENDING APPROVAL :	APPROVED BY :	SHEET CONTENT	SHEET NO.
	<p>PROPOSED REHABILITATION OF PAYATAS B ELEMENTARY SCHOOL</p> <p>BARANGAY PAYATAS, DISTRICT-2, QUEZON CITY</p>	DATE : NOV. 17, 2020	 ENGR. LED S. DEL ROSARIO HEAD, PLANNING & PROGRAMMING DIVISION	 ENGR. ISAGANI R. VERZOSA, JR. OIC, CITY ENGINEERING DEPARTMENT	HON. MA. JOSEFINA G. BELMONTE CITY MAYOR, QUEZON CITY	SCHEDULE OF DOORS (NEW LIBAN BUILDING)	
		CHECKED BY :					

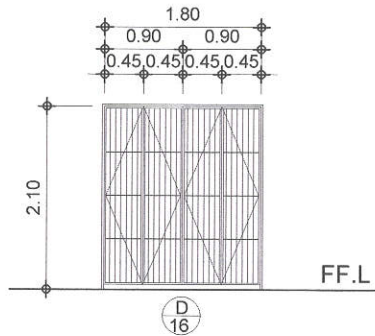

TYPE : IRON STEEL (FOLDING DOOR)
 LOCATION : CORRIDOR
 TO BE REPAINTED

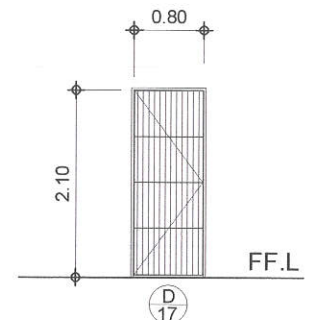


TYPE : IRON STEEL DOOR
 LOCATION : CLASSROOM (NEAR GATE)
 TO BE REPAINTED


20-00145

1 SCHEDULE OF DOORS (NEW LIBAN BUILDING)

SCALE: 1:60 METERS

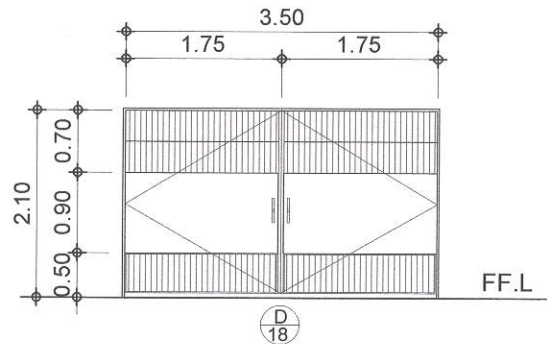


 


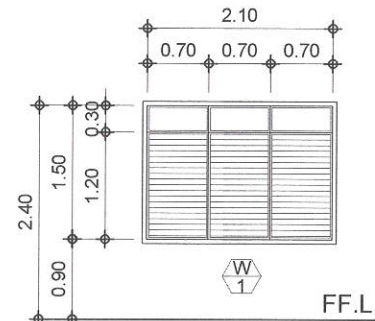TYPE : IRON STEEL DOOR
 LOCATION : MAIN GATE (ENTRANCE/EXIT)
 TO BE REPAINTED



TYPE : JALOUSIE WITH TRANSOM
 LOCATION : CLASSROOM, CANTEEN

2 SCHEDULE OF DOORS AND WINDOWS (NEW LIBAN BUILDING)

SCALE: 1:60 METERS

 <p>Republika ng Pilipinas Lungsod ng Quezon CITY ENGINEERING DEPARTMENT</p>	PROJECT TITLE :	DRAWN BY : DEXTER	SUBMITTED BY :	RECOMMENDING APPROVAL :	APPROVED BY :	SHEET CONTENT	SHEET NO.
	<p>PROPOSED REHABILITATION OF PAYATAS B ELEMENTARY SCHOOL</p> <p>BARANGAY PAYATAS, DISTRICT-2, QUEZON CITY</p>	DATE : NOV. 17, 2020	 ENGR. LEO S. DEL ROSARIO HEAD, PLANNING & PROGRAMMING DIVISION	 ENGR. ISAGANI R. VERZOSA, JR. OIC, CITY ENGINEERING DEPARTMENT	HON. MA. JOSEFINA G. BELMONTE CITY MAYOR, QUEZON CITY	SCHEDULE OF DOORS & (NEW LIBAN BUILDING)	
		CHECKED BY :					

20-00145

REPLACEMENT OF EXISTING ROOFING
REPLACEMENT OF EXISTING GUTTER



EXISTING WALLS TO BE REPAINTED
REPAINTING OF WINDOW GRILLES



EXISTING DOORS TO BE REPAINTED,
REPLACED DOOR KNOBS AT BOLTS
EXISTING WINDOW FRAMES TO BE
REPLACED, REPAINTED



1 NEW LIBAN BUILDING (FACADE)

2 NEW LIBAN BUILDING (CLASSROOM)

3 NEW LIBAN BUILDING (2ND FLOOR CORRIDOR)


PROPOSED WALL, DOORS AND WINDOWS
EXISTING ELECTRICAL FIXTURES TO BE REPLACED



REPLACEMENT AND REPAINTING OF EXISTING CEILING
EXISTING ELECTRICAL FIXTURES TO BE REPLACED



EXISTING WINDOW GRILLES TO BE REPAINTED
EXISTING WALLS TO BE REPAINTED

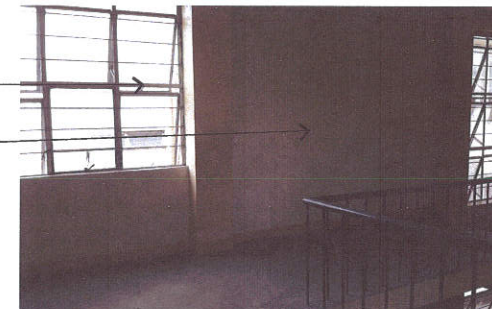

4 NEW LIBAN BUILDING (3RD FLOOR CORRIDOR)

5 NEW LIBAN BUILDING (GROUND FLR. LOBBY)

6 NEW LIBAN BUILDING (STAIR LOBBY)



Republika ng Pilipinas
Lungsod ng Quezon
CITY ENGINEERING DEPARTMENT

PROJECT TITLE :
**PROPOSED REHABILITATION OF
PAYATAS B ELEMENTARY SCHOOL**
BARANGAY PAYATAS, DISTRICT-2, QUEZON CITY

DRAWN BY : DEXTER
DATE : NOV. 17, 2020
CHECKED BY :
REVISION NO.:

SUBMITTED BY :
[Signature]
ENGR. LEY S. DEL ROSARIO
HEAD, PLANNING & PROGRAMMING DIVISION

RECOMMENDING APPROVAL :
[Signature]
ENGR. ISAGANI R. VERZOSA, JR.
OIC, CITY ENGINEERING DEPARTMENT


APPROVED BY :
[Signature]
HON. MA. JOSEFINA G. BELMONTE
CITY MAYOR, QUEZON CITY

SHEET CONTENT
NEW LIBAN BLDG. (FACADE),
NEW LIBAN BUILDING
(CLASSROOM),
NEW LIBAN BUILDING
(SECOND FLOOR CORRIDOR),
NEW LIBAN BUILDING
(THIRD FLOOR CORRIDOR),
NEW LIBAN BUILDING
(GROUND FLOOR LOBBY),
NEW LIBAN BUILDING
(STAIRS LOBBY)

SHEET NO.
**AR
15**

20-00145


EXISTING WALLS TO BE REPAINTED
EXISTING GATE TO BE REPAINTED

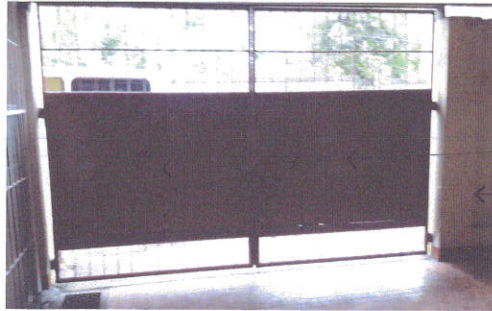

EXISTING WALLS TO BE REPAINTED
EXISTING ELECTRICAL FIXTURES TO BE REPLACED
EXISTING CEILING TO BE REPLACED, REPAINTED



EXISTING DOORS TO BE REPAINTED, REPLACED DOOR KNOBS AT BOLTS
EXISTING WINDOW FRAMES TO BE REPLACED, REPAINTED

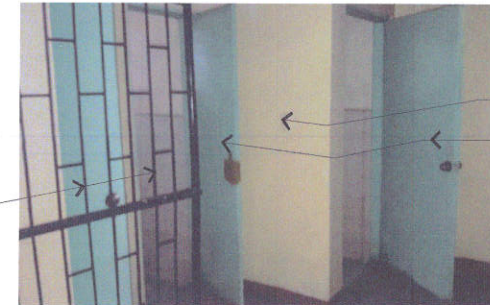

EXISTING GRILL DOOR TO BE REPAINTED WITH NEW COLOR

1 NEW LIBAN BUILDING (MAIN GATE)

2 NEW LIBAN BUILDING (TEACHER'S COMFORT RM.)

3 NEW LIBAN BUILDING (TEACHER'S COMFORT RM.)

EXISTING DOORS TO BE REPAINTED, REPLACED DOOR KNOBS AT BOLTS
EXISTING WALLS TO BE REPAINTED



EXISTING DOORS TO BE REPAINTED, REPLACED DOOR KNOBS AT BOLTS
EXISTING WALLS TO BE REPAINTED



EXISTING PLUMBING FIXTURES TO BE REPLACED
EXISTING WINDOW FRAME TO BE REPLACED



EXISTING FLOOR TILES TO BE REPLACED

4 NEW LIBAN BUILDING (MALE COMFORT ROOM)

5 NEW LIBAN BUILDING (FEMALE COMFORT ROOM)

6 NEW LIBAN BUILDING (STAIR LOBBY)



Republika ng Pilipinas
Lungsod ng Quezon
CITY ENGINEERING DEPARTMENT

PROJECT TITLE :

**PROPOSED REHABILITATION OF
PAYATAS B ELEMENTARY SCHOOL**

BARANGAY PAYATAS, DISTRICT-2, QUEZON CITY

DRAWN BY : DEXTER

DATE : NOV. 17, 2020

CHECKED BY: *[Signature]*

REVISION NO.:

SUBMITTED BY:

ENGR. LEO S. DEL ROSARIO
HEAD, PLANNING & PROGRAMMING DIVISION

RECOMMENDING APPROVAL :

ENGR. ISAGANI R. VERZOSA, JR.
OIC, CITY ENGINEERING DEPARTMENT

APPROVED BY :

HON. MA. JOSEFINA G. BELMONTE
CITY MAYOR, QUEZON CITY


SHEET CONTENT

NEW LIBAN BLDG. (MAIN GATE),
NEW LIBAN BUILDING
(TEACHER'S COMFORT ROOM),
NEW LIBAN BUILDING
(TEACHER'S COMFORT ROOM),
NEW LIBAN BLDG. (MALE CR),
NEW LIBAN BLDG. (FEMALE CR),
NEW LIBAN BUILDING
(TEACHER'S COMFORT ROOM)

SHEET NO.


**AR
16**

20-00145

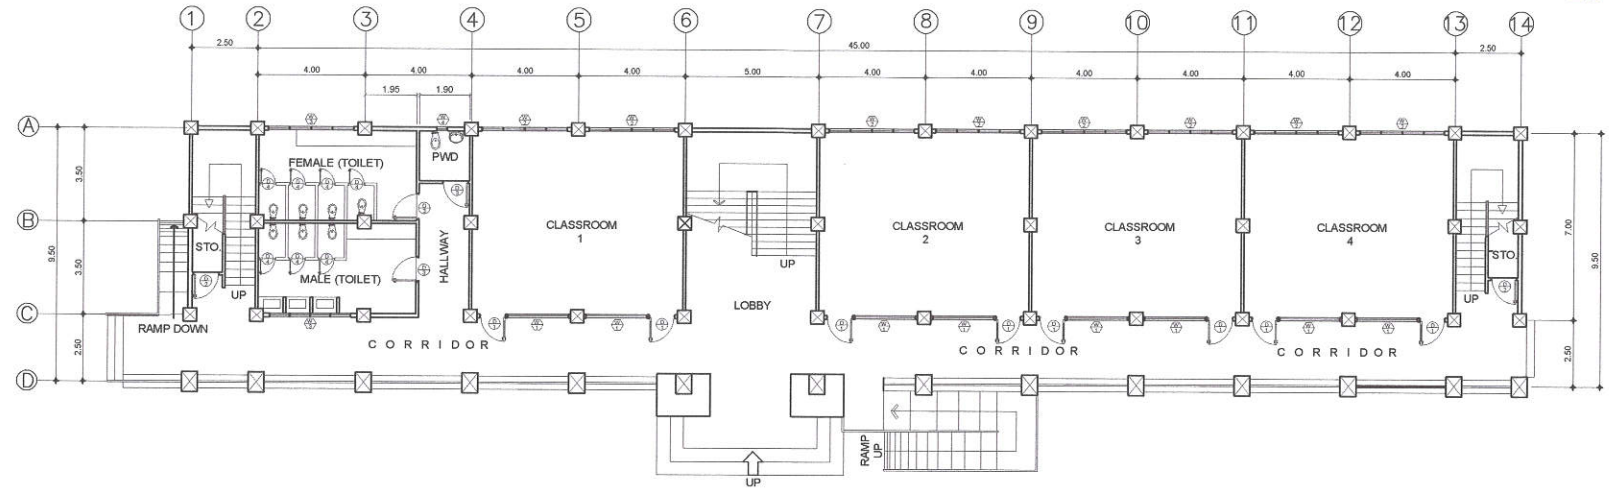




 


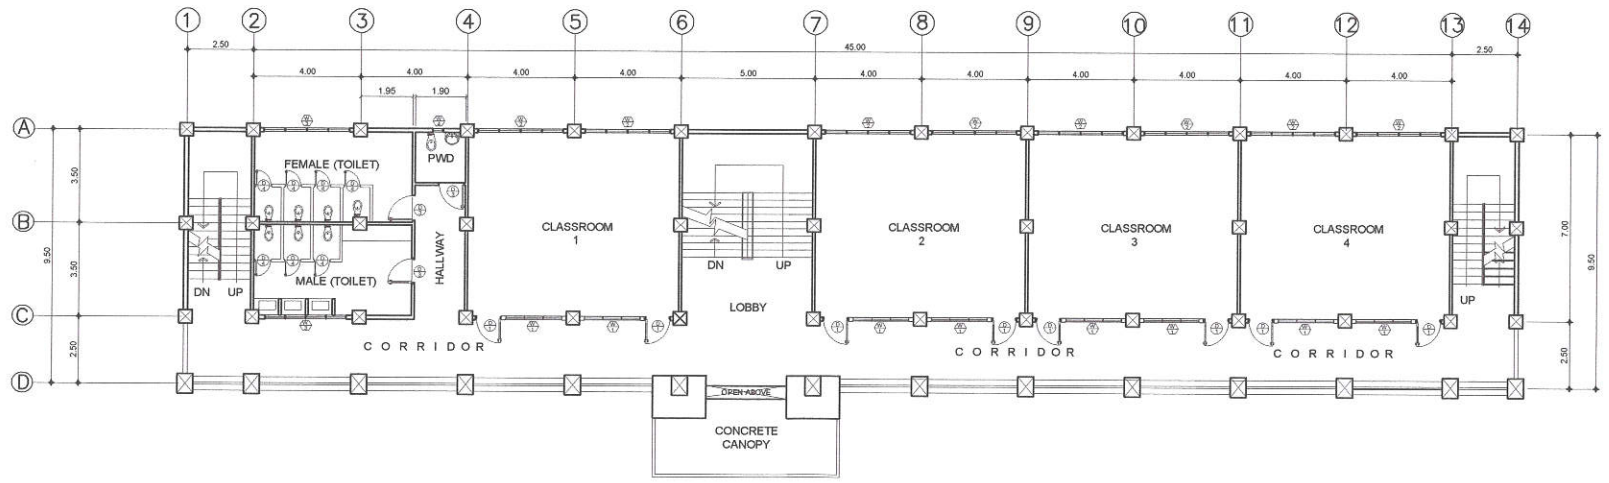1 GROUND FLOOR PLAN (HB HALL BUILDING A)

SCALE : 1 : 200 MTS




2 SECOND FLOOR PLAN (HB HALL BUILDING A)

SCALE : 1 : 200 MTS


 <p>Republika ng Pilipinas Lungsod ng Quezon CITY ENGINEERING DEPARTMENT</p>	PROJECT TITLE :	DRAWN BY : DEXTER	SUBMITTED BY :	RECOMMENDING APPROVAL :	APPROVED BY :	SHEET CONTENT	SHEET NO.
	PROPOSED REHABILITATION OF PAYATAS B ELEMENTARY SCHOOL	DATE : NOV. 17, 2020				GROUND FLOOR PLAN AND SECOND FLOOR PLAN (HB HALL BUILDING A)	
	BARANGAY PAYATAS, DISTRICT-2, QUEZON CITY	CHECKED BY : 	ENGR. LEO S. DEL ROSARIO HEAD, PLANNING & PROGRAMMING DIVISION	ENGR. ISAGANI R. VERZOSA, JR. OIC, CITY ENGINEERING DEPARTMENT	HON. MA. JOSEFINA G. BELMONTE CITY MAYOR, QUEZON CITY		
REVISION NO.:							

20-00145

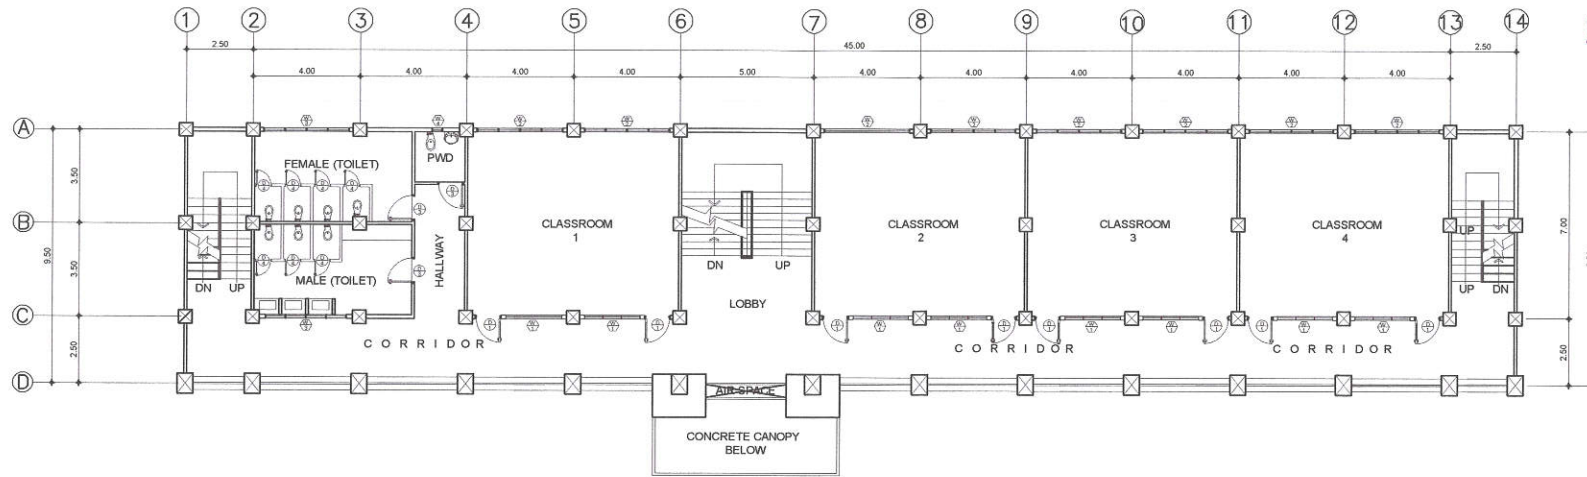

1 THIRD FLOOR PLAN (HB HALL BUILDING A)

SCALE : 1 : 200 MTS

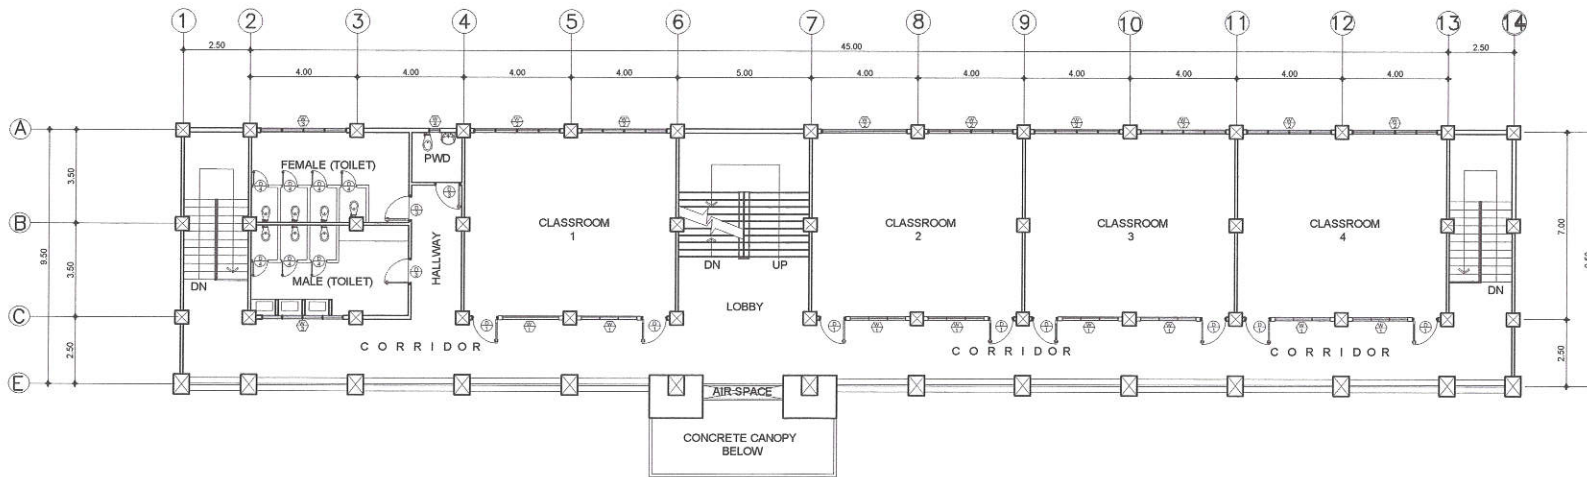
 
 
 


2 FOURTH FLOOR PLAN (HB HALL BUILDING A)


SCALE : 1 : 200 MTS



Republika ng Pilipinas
Lungsod ng Quezon
CITY ENGINEERING DEPARTMENT

PROJECT TITLE :	DRAWN BY : DEXTER	SUBMITTED BY :	RECOMMENDING APPROVAL :	APPROVED BY :	SHEET CONTENT	SHEET NO.
PROPOSED REHABILITATION OF PAYATAS B ELEMENTARY SCHOOL	DATE : NOV. 17, 2020	 ENGR. LEO S. DEL ROSARIO HEAD, PLANNING & PROGRAMMING DIVISION	 ENGR. ISABANI R. VERZOSA, JR. OIC, CITY ENGINEERING DEPARTMENT	 HON. MA. JOSEFINA G. BELMONTE CITY MAYOR, QUEZON CITY	THIRD FLOOR PLAN AND FOURTH FLOOR PLAN (HB HALL BUILDING A)	AR 18
	CHECKED BY : 					
BARANGAY PAYATAS, DISTRICT-2, QUEZON CITY						

20-00145

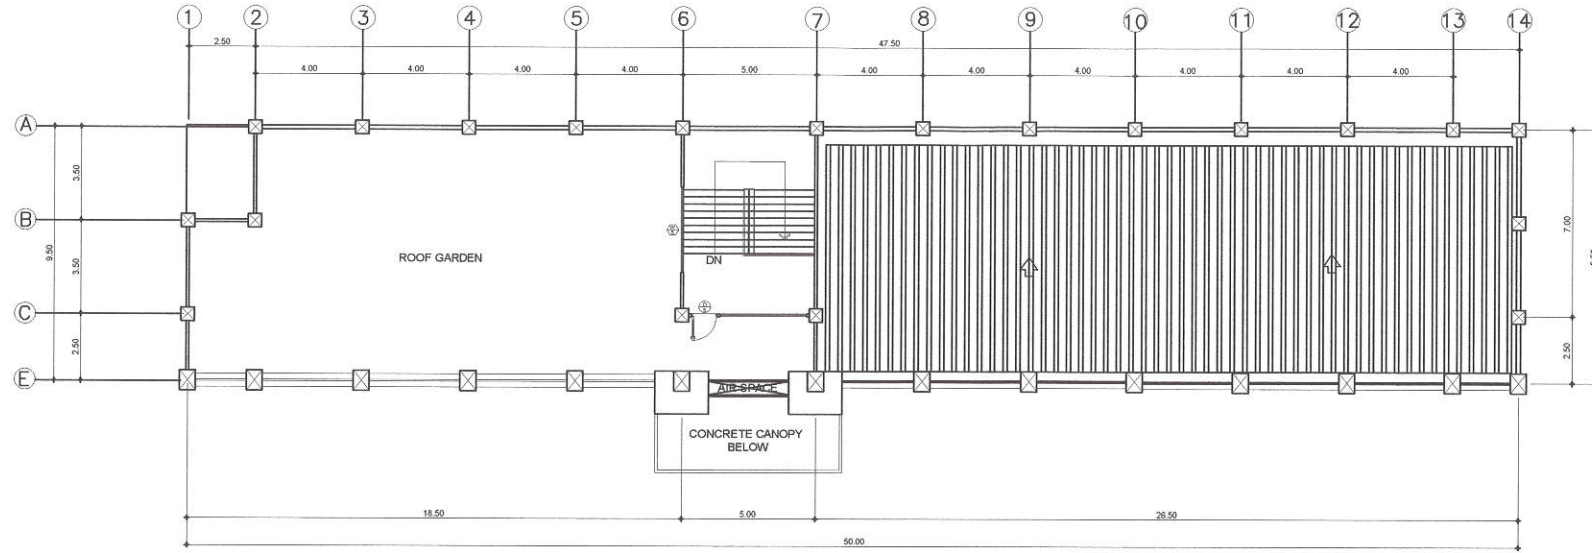


 


1 ROOF GARDEN FLOOR PLAN (HB HALL BUILDING A)

SCALE :1 : 200 MTS



2 FRONT ELEVATION (HB HALL BUILDING A)


SCALE :1 : 200 MTS

 <p>Republika ng Pilipinas Lungsod ng Quezon CITY ENGINEERING DEPARTMENT</p>	PROJECT TITLE :	DRAWN BY : DEXTER	SUBMITTED BY :	RECOMMENDING APPROVAL :	APPROVED BY :	SHEET CONTENT	SHEET NO.
	<p>PROPOSED REHABILITATION OF PAYATAS B ELEMENTARY SCHOOL</p> <p>BARANGAY PAYATAS, DISTRICT-2, QUEZON CITY</p>	DATE : NOV. 17, 2020	 <p>ENGR. LEO S. DEL ROSARIO HEAD, PLANNING & PROGRAMMING DIVISION</p>	 <p>ENGR. ISAGANI R. VERZOSA, JR. OIC, CITY ENGINEERING DEPARTMENT</p>	<p>HON. MA. JOSEFINA G. BELMONTE CITY MAYOR, QUEZON CITY</p>	<p>ROOF DECK FLOOR PLAN AND FRONT ELEVATION (HB HALL BUILDING B)</p>	
		CHECKED BY :					





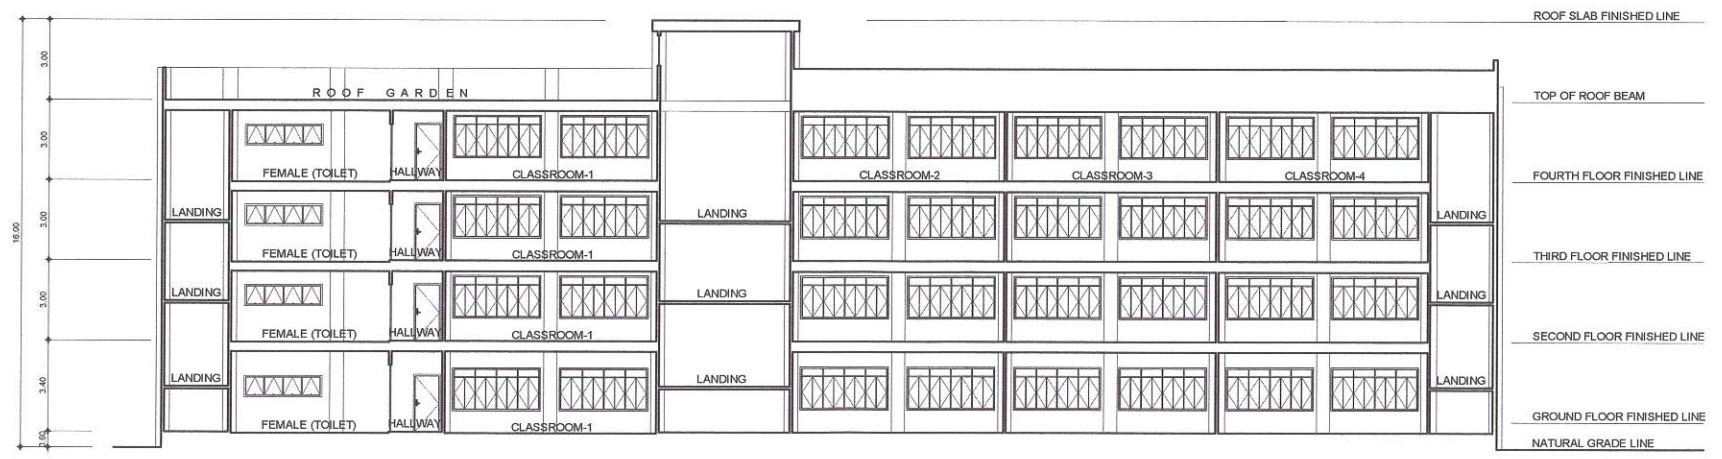


1 REAR ELEVATION (HB HALL BUILDING A)


SCALE : 1 : 200 MTS




2 LONGITUDINAL SETION (HB HALL BUILDING A)

SCALE : 1 : 200 MTS

 <p>Republika ng Pilipinas Lungsod ng Quezon CITY ENGINEERING DEPARTMENT</p>	PROJECT TITLE :	DRAWN BY : DEXTER	SUBMITTED BY :	RECOMMENDING APPROVAL :	APPROVED BY :	SHEET CONTENT	SHEET NO.
	<p>PROPOSED REHABILITATION OF PAYATAS B ELEMENTARY SCHOOL</p> <p>BARANGAY PAYATAS, DISTRICT-2, QUEZON CITY</p>	DATE : NOV. 17, 2020	 <p>ENGR. LEO S. DEL ROSARIO HEAD, PLANNING & PROGRAMMING DIVISION</p>	 <p>ENGR. ISAGANI R. VERZOSA, JR. OIC, CITY ENGINEERING DEPARTMENT</p>	<p>HON. MA. JOSEFINA G. BELMONTE CITY MAYOR, QUEZON CITY</p>	<p>HB HALL BLDG. B (FACADE) HB HALL BLDG. (CORRIDOR) HB HALL BLDG. (GR) (HB HALL BUILDING A)</p>	
		CHECKED BY : 					

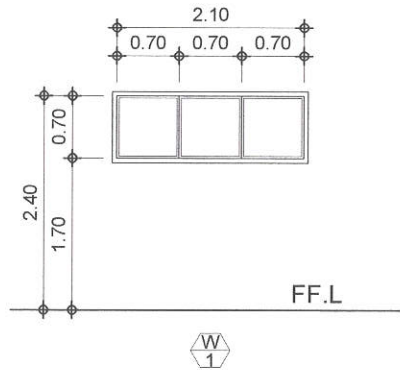


TYPE : JALOUSIE
 LOCATION : CLASSROOMS
 REPLACE BROKEN GLASS

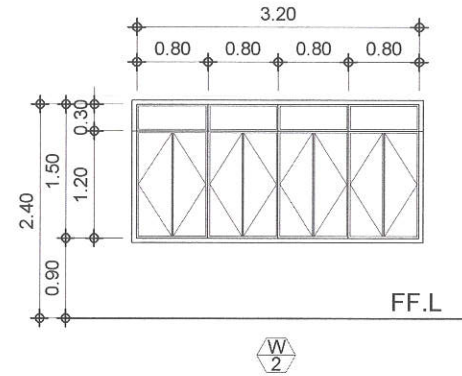


20-00145

TYPE : STEEL CASEMENT WITH TRANSOM
 LOCATION : CLASSROOMS
 REPLACE BROKEN GLASS

1 SCHEDULE OF WINDOWS (HB HALL BUILDING A)

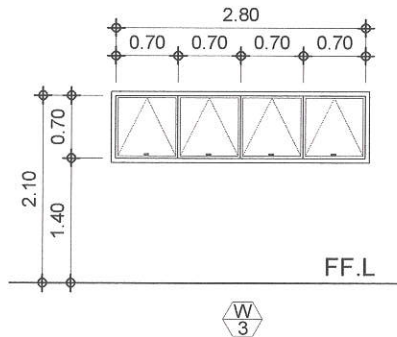


 


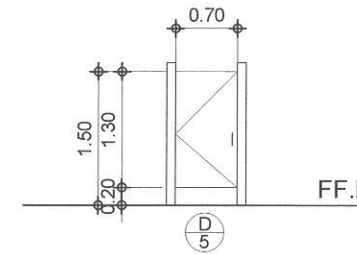
TYPE : AWNING WINDOW
 LOCATION : MALE AND FEMALE
 COMFORT ROOMS
 REPLACE BROKEN GLASS



TYPE : FLUSH DOOR
 LOCATION : COMFORT ROOMS (CUBICLE)

2 SCHEDULE OF WINDOW AND DOOR (HB HALL BUILDING A)

SCALE : 1 : 60 METERS

 <p>Republika ng Pilipinas Lungsod ng Quezon CITY ENGINEERING DEPARTMENT</p>	PROJECT TITLE :	DRAWN BY : DEXTER	SUBMITTED BY :	RECOMMENDING APPROVAL :	APPROVED BY :	SHEET CONTENT	SHEET NO.
	PROPOSED REHABILITATION OF PAYATAS B ELEMENTARY SCHOOL BARANGAY PAYATAS, DISTRICT-2, QUEZON CITY	DATE : NOV. 17, 2020	 ENGR. LEO S. DEL ROSARIO HEAD, PLANNING & PROGRAMMING DIVISION	 ENGR. ISAGANI R. VERZOSA, JR. OIC, CITY ENGINEERING DEPARTMENT	 HON. MA. JOSEFINA G. BELMONTE CITY MAYOR, QUEZON CITY	SCHEDULE OF WINDOWS (HB HALL BUILDING A)	
		CHECKED BY :					



EXISTING PLUMBING
FIXTURES TO BE REPLACED

20-00145



1 HB HALL BUILDING A (GROUND FLOOR-CORRIDOR)

2 HB HALL BUILDING A (PWD-COMFORT ROOM)

EXISTING DOORS TO BE REPAINTED,
REPLACED DOOR KNOBS AT BOLTS



EXISTING PLUMBING
FIXTURES TO BE REPLACED






3 HB HALL BUILDING A (COMFORT ROOM-PWD)


4 HB HALL BUILDING A (COMFORT ROOM-CUBICLE)




Republika ng Pilipinas
Lungsod ng Quezon
CITY ENGINEERING DEPARTMENT

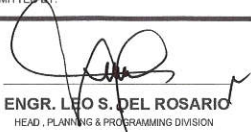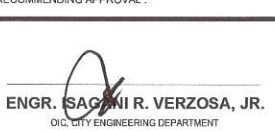PROJECT TITLE :	DRAWN BY : DEXTER	SUBMITTED BY :	RECOMMENDING APPROVAL :	APPROVED BY :	SHEET CONTENT	SHEET NO.
PROPOSED REHABILITATION OF PAYATAS B ELEMENTARY SCHOOL	DATE : NOV. 17, 2020	 ENGR. LEO S. DEL ROSARIO HEAD, PLANNING & PROGRAMMING DIVISION	 ENGR. SAGANI R. VERZOSA, JR. OIC, CITY ENGINEERING DEPARTMENT	HON. MA. JOSEFINA G. BELMONTE CITY MAYOR, QUEZON CITY	HB HALL BLDG. B (FACADE) HB HALL BLDG. (CORRIDOR) HB HALL BLDG. (CR) HB HALL BUILDING A)	AR 22
	CHECKED BY : 					
BARANGAY PAYATAS, DISTRICT-2, QUEZON CITY						

20-00145

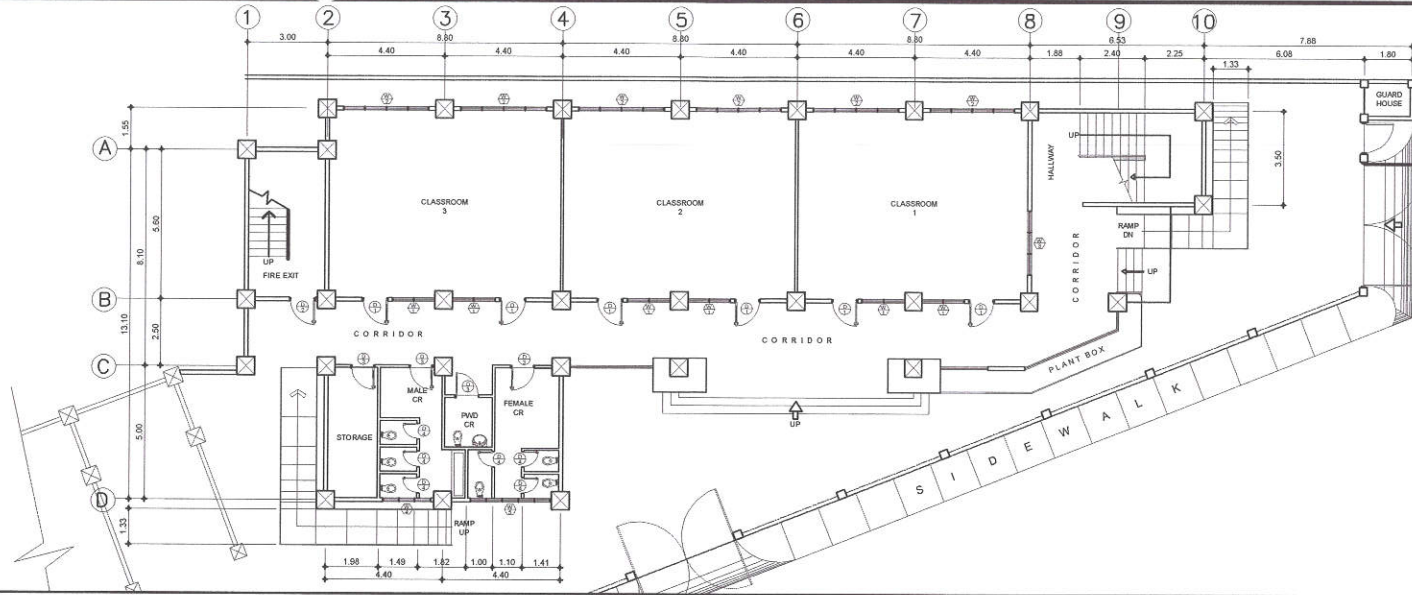
 


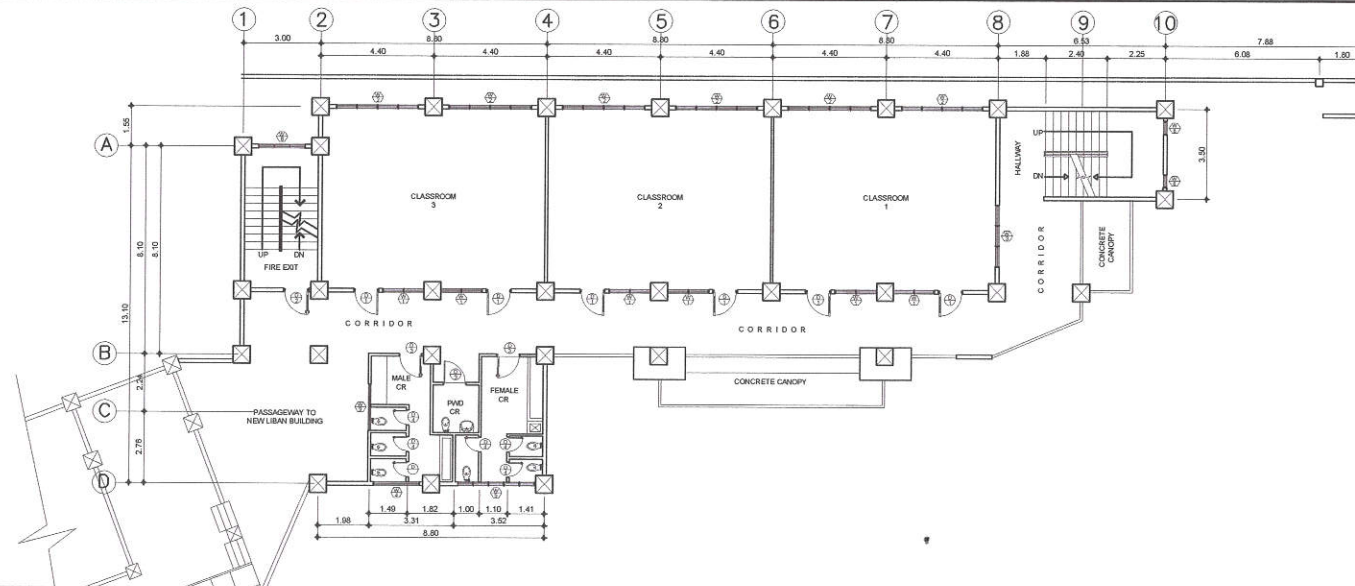

1 GROUND FLOOR PLAN (HB HALL BUILDING B)




2 SECOND FLOOR PLAN (HB HALL BUILDING B)

SCALE : 1 : 200 MTS


 <p>Republika ng Pilipinas Lungsod ng Quezon CITY ENGINEERING DEPARTMENT</p>	PROJECT TITLE :	DRAWN BY : DEXTER	SUBMITTED BY :	RECOMMENDING APPROVAL :	APPROVED BY :	SHEET CONTENT	SHEET NO.
	<p>PROPOSED REHABILITATION OF PAYATAS B ELEMENTARY SCHOOL</p> <p>BARANGAY PAYATAS, DISTRICT-2, QUEZON CITY</p>	DATE : NOV. 17, 2020	 <p>ENGR. LEO S. DEL ROSARIO HEAD, PLANNING & PROGRAMMING DIVISION</p>	 <p>ENGR. ISAGANI R. VERZOSA, JR. OIC, CITY ENGINEERING DEPARTMENT</p>	<p>HON. MA. JOSEFINA G. BELMONTE CITY MAYOR, QUEZON CITY</p>	<p>GROUND FLOOR PLAN AND SECOND FLOOR PLAN (HB HALL BUILDING B)</p>	
		CHECKED BY :					

20-00145

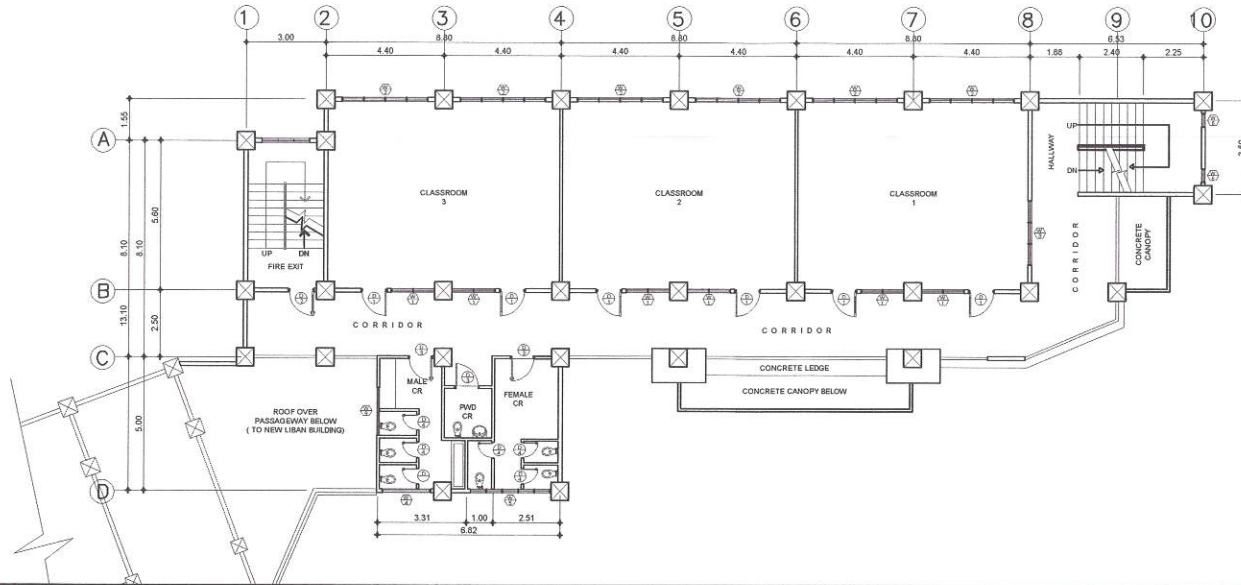



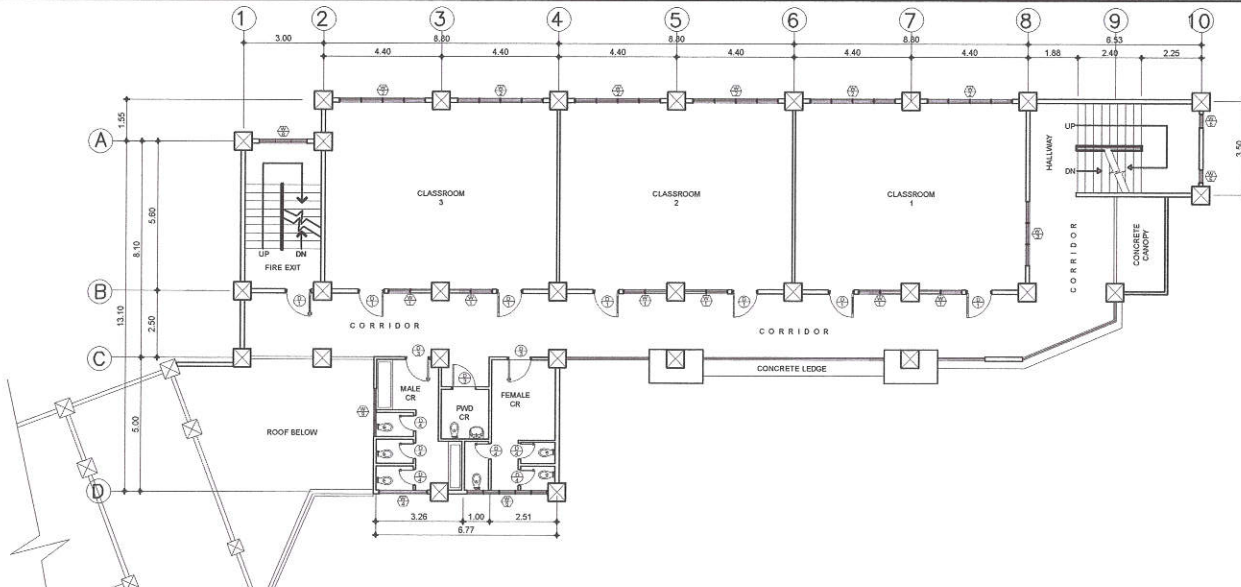

1 THIRD FLOOR PLAN (HB HALL BUILDING B)


SCALE : 1 : 200 MTS



2 FOURTH FLOOR PLAN (HB HALL BUILDING B)

SCALE : 1 : 200 MTS


 <p>Republika ng Pilipinas Lungsod ng Quezon CITY ENGINEERING DEPARTMENT</p>	PROJECT TITLE :	DRAWN BY : DEXTER	SUBMITTED BY :	RECOMMENDING APPROVAL :	APPROVED BY :	SHEET CONTENT	SHEET NO.
	<p>PROPOSED REHABILITATION OF PAYATAS B ELEMENTARY SCHOOL</p> <p>BARANGAY PAYATAS, DISTRICT-2, QUEZON CITY</p>	DATE : NOV. 17, 2020	 ENGR. LEO S. DEL ROSARIO HEAD, PLANNING & PROGRAMMING DIVISION	 ENGR. ISAGANI R. VERZOSA, JR. OIC, CITY ENGINEERING DEPARTMENT	HON. MA. JOSEFINA G. BELMONTE CITY MAYOR, QUEZON CITY	THIRD FLOOR PLAN AND FOURTH FLOOR PLAN (HB HALL BUILDING B)	
		CHECKED BY :					

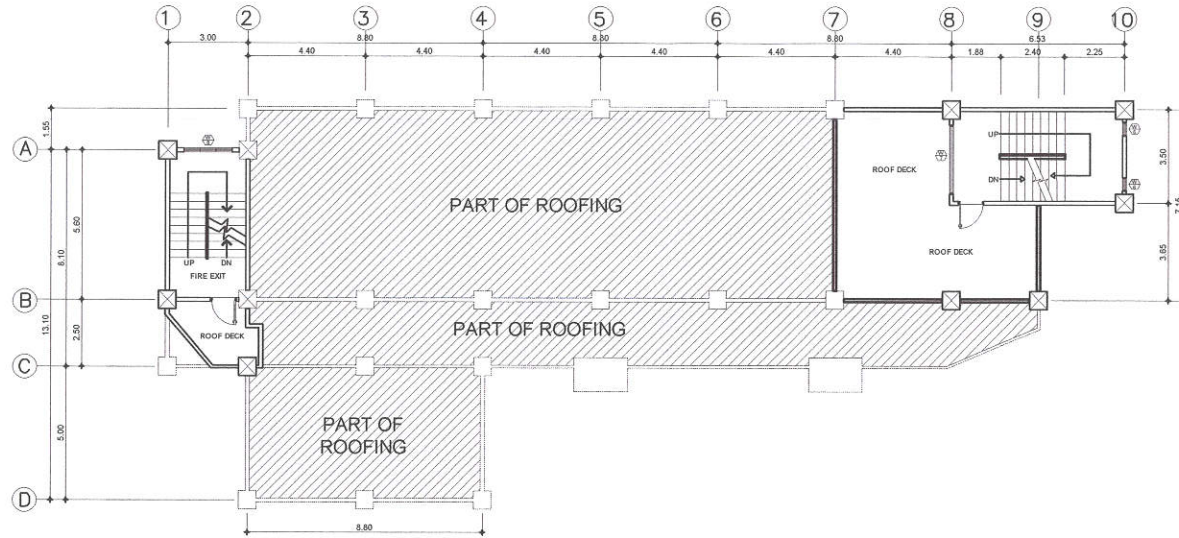

20-00145



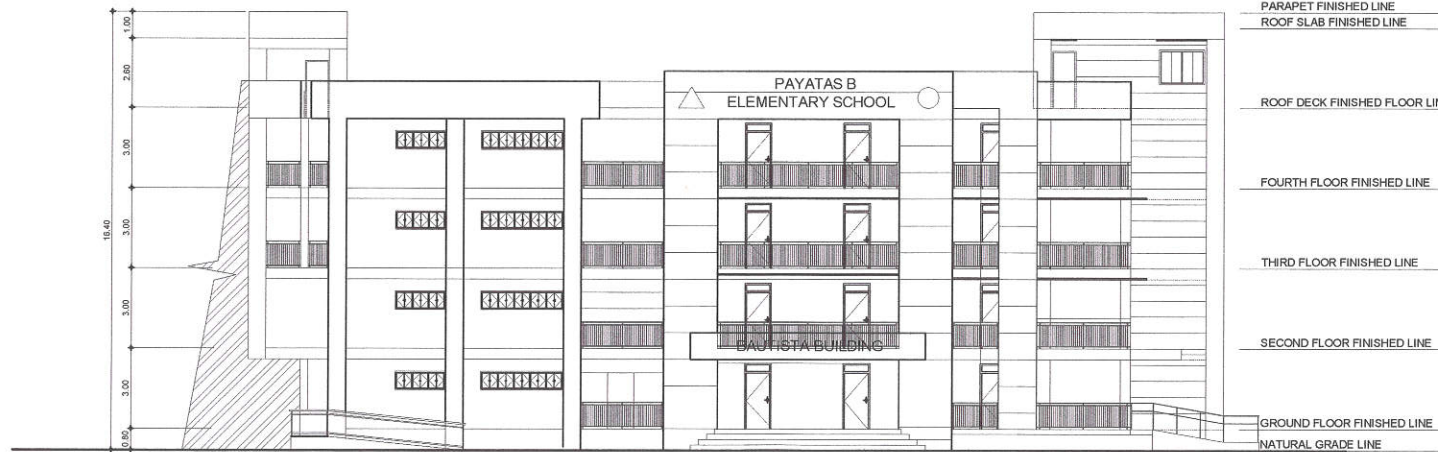


1 ROOF DECK FLOOR PLAN (HB HALL BUILDING B)

SCALE : 1 : 200 MTS



2 FRONT ELEVATION (HB HALL BUILDING B)

SCALE : 1 : 200 MTS

 <p>Republika ng Pilipinas Lungsod ng Quezon CITY ENGINEERING DEPARTMENT</p>	PROJECT TITLE :	DRAWN BY : DEXTER	SUBMITTED BY :	RECOMMENDING APPROVAL :	APPROVED BY :	SHEET CONTENT	SHEET NO.
	PROPOSED REHABILITATION OF PAYATAS B ELEMENTARY SCHOOL	DATE : NOV. 17, 2020	 ENGR. LEO S. DEL ROSARIO HEAD, PLANNING & PROGRAMMING DIVISION	 ENGR. ISAGANI R. VERZOSA, JR. OIC, CITY ENGINEERING DEPARTMENT	HON. MA. JOSEFINA G. BELMONTE CITY MAYOR, QUEZON CITY	ROOF DECK FLOOR PLAN AND FRONT ELEVATION (HB HALL BUILDING B)	
	BARANGAY PAYATAS, DISTRICT-2, QUEZON CITY	CHECKED BY : 					

20-00145



1 HB HALL BUILDING B (FACADE)

2 HB HALL BUILDING B (CORRIDOR)


 




EXISTING WALL TILES TO BE REPLACED (0.40M X 0.40 M)




3 HB HALL BUILDING B (COMFORT ROOM)

4 HB HALL BUILDING B (THIRD FLOOR-COMFORT ROOM)


 <p>Republika ng Pilipinas Lungsod ng Quezon CITY ENGINEERING DEPARTMENT</p>	PROJECT TITLE :	DRAWN BY : DEXTER	SUBMITTED BY :	RECOMMENDING APPROVAL :	APPROVED BY :	SHEET CONTENT	SHEET NO.
	<p>PROPOSED REHABILITATION OF PAYATAS B ELEMENTARY SCHOOL</p> <p>BARANGAY PAYATAS, DISTRICT-2, QUEZON CITY</p>	DATE : NOV. 17, 2020	 <p>ENGR. LEW S. DEL ROSARIO HEAD, PLANNING & PROGRAMMING DIVISION</p>	 <p>ENGR. ISAGANI R. VERZOSA, JR. OIC, CITY ENGINEERING DEPARTMENT</p>	<p>HON. MA. JOSEFINA G. BELMONTE CITY MAYOR, QUEZON CITY</p>	<p>HB HALL BLDG. B (FACADE) HB HALL BLDG. (CORRIDOR) HB HALL BLDG. (CR) (HB HALL BUILDING B)</p>	
		CHECKED BY :					

20-00145

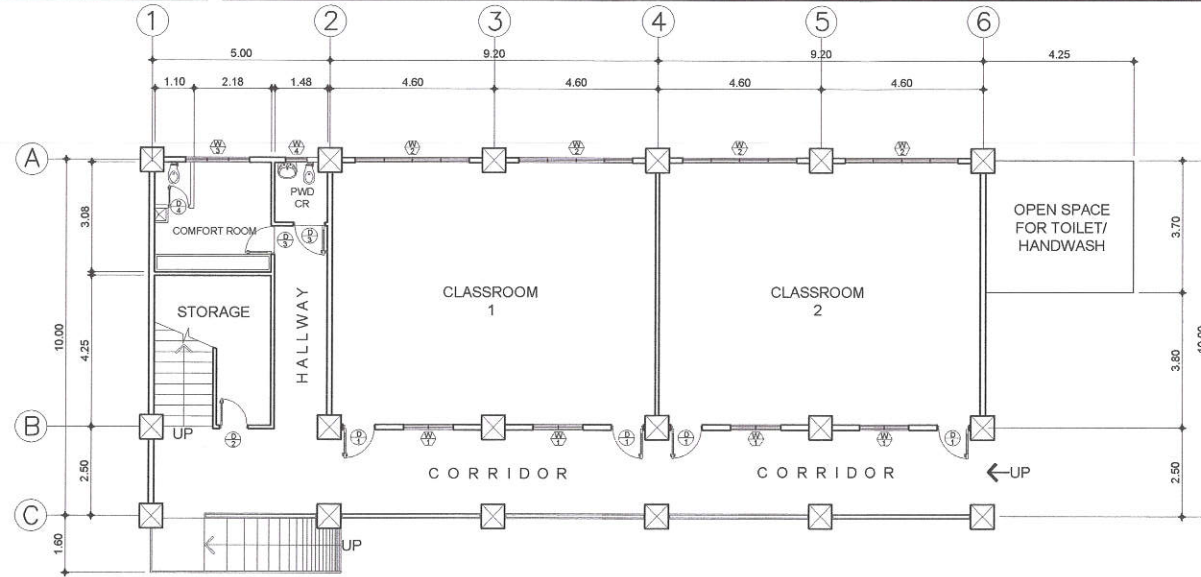

1 GROUND FLOOR PLAN (DEP ED CASTELO BUILDING)

SCALE : 1 : 150 METERS

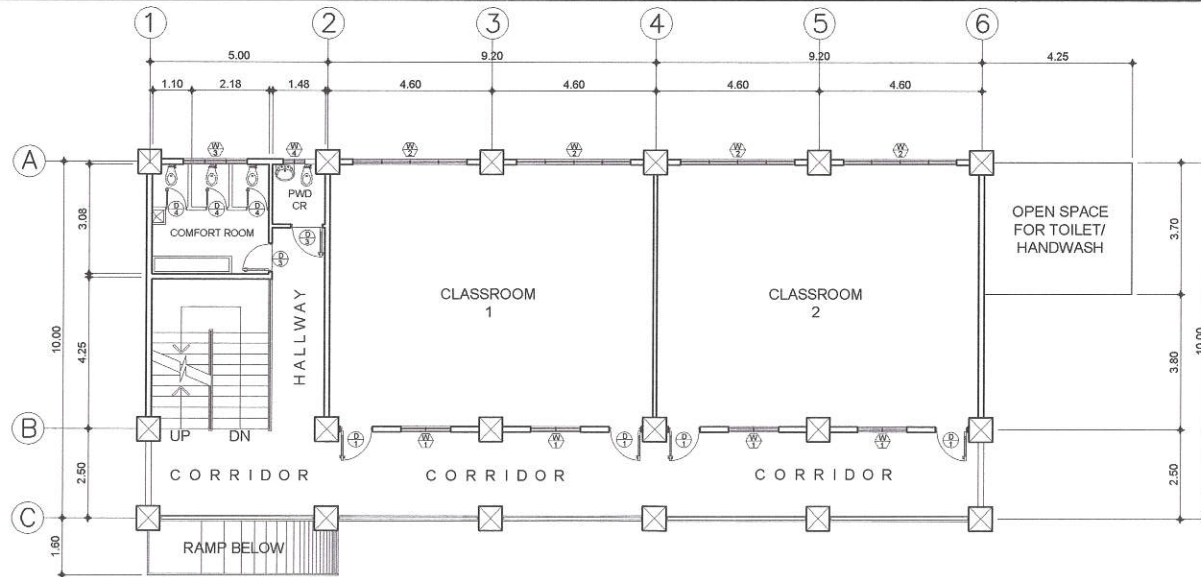


2 SECOND FLOOR PLAN (DEP ED CASTELO BUILDING)

SCALE : 1 : 150 METERS



Republika ng Pilipinas
Lungsod ng Quezon
CITY ENGINEERING DEPARTMENT


PROJECT TITLE :	DRAWN BY : DEXTER	SUBMITTED BY :	RECOMMENDING APPROVAL :	APPROVED BY :	SHEET CONTENT	SHEET NO.
PROPOSED REHABILITATION OF PAYATAS B ELEMENTARY SCHOOL	DATE : NOV. 17, 2020				GROUND FLOOR PLAN AND SECOND FLOOR PLAN (DEP ED CASTELO BLDG.)	AR 27
	CHECKED BY :					
BARANGAY PAYATAS, DISTRICT-2, QUEZON CITY	REVISION NO.:					

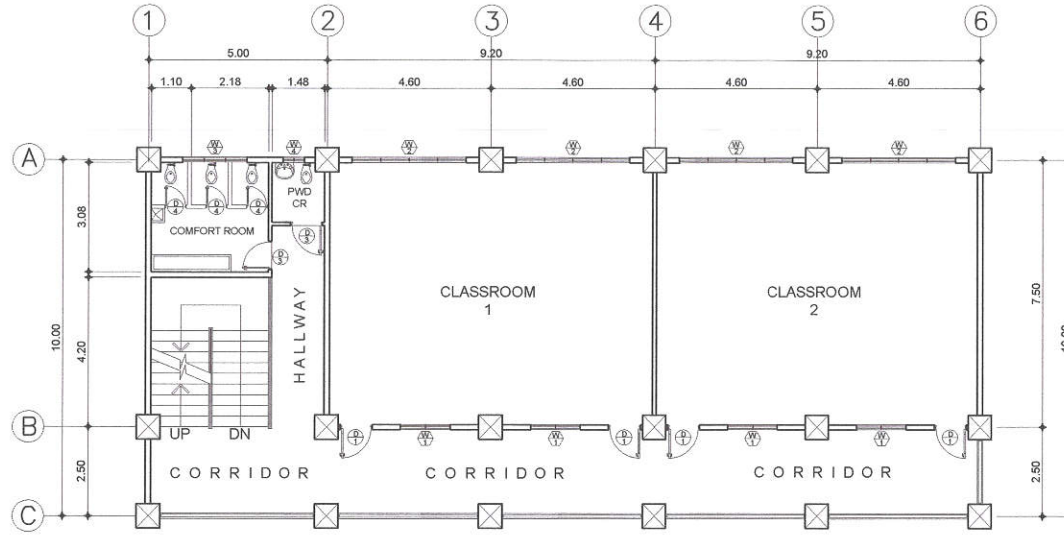

20-00145

1 THIRD FLOOR PLAN (DEP ED CASTELO BUILDING)

SCALE : 1 : 150 METERS

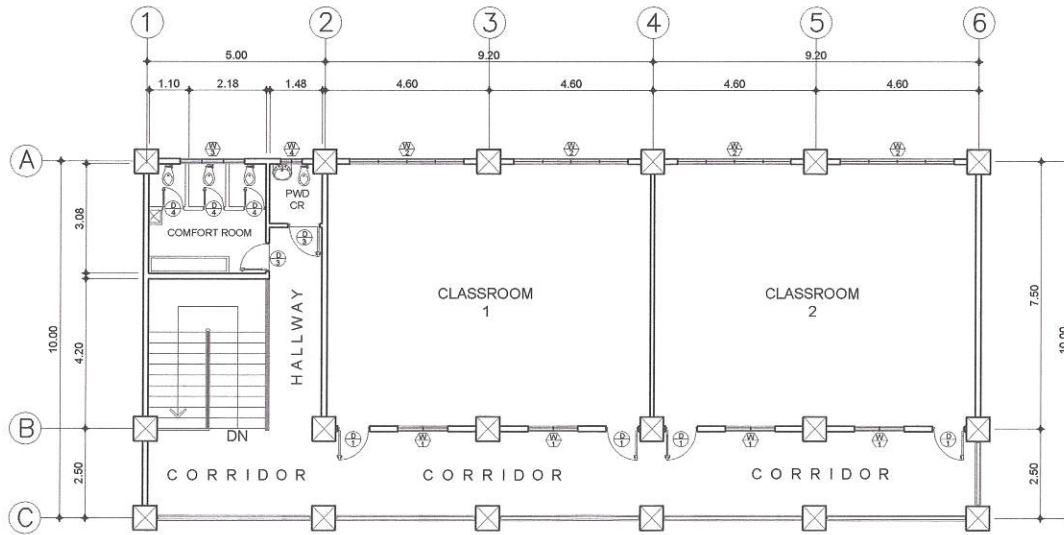

2 FOURTH FLOOR PLAN (DEP ED CASTELO BUILDING)

SCALE : 1 : 150 METERS



Republika ng Pilipinas
Lungsod ng Quezon
CITY ENGINEERING DEPARTMENT

PROJECT TITLE :
**PROPOSED REHABILITATION OF
PAYATAS B ELEMENTARY SCHOOL**
BARANGAY PAYATAS, DISTRICT-2, QUEZON CITY

DRAWN BY : DEXTER
DATE : NOV. 17, 2020
CHECKED BY :
REVISION NO.:

SUBMITTED BY:

ENGR. LEO S. DEL ROSARIO
HEAD, PLANNING & PROGRAMMING DIVISION

RECOMMENDING APPROVAL :


ENGR. ISAGANI R. VERZOSA, JR.
OIC, CITY ENGINEERING DEPARTMENT

APPROVED BY :

HON. MA. JOSEFINA G. BELMONTE
CITY MAYOR, QUEZON CITY

SHEET CONTENT
THIRD FLOOR PLAN AND
FOURTH FLOOR PLAN
(DEP ED CASTELO BLDG.)

SHEET NO.
**AR
28**

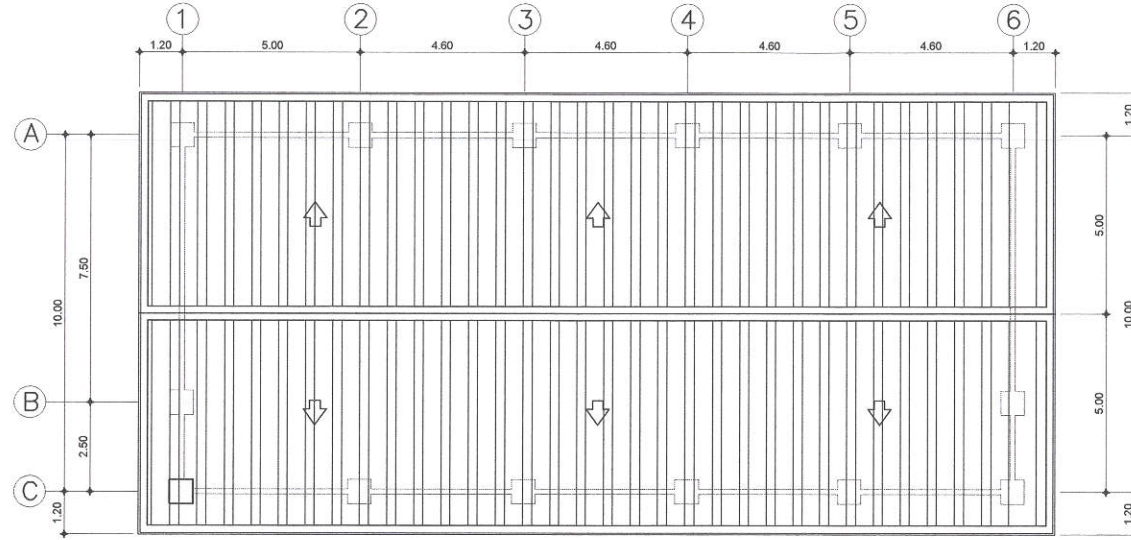

20-00145

1 ROOF PLAN (DEP-ED CASTELO BUILDING)

SCALE : 1 : 150 METERS



2 FRONT ELEVATION (DEP-ED CASTELO BUILDING)



SCALE : 1 : 150 METERS



Republika ng Pilipinas
Lungsod ng Quezon
CITY ENGINEERING DEPARTMENT



PROJECT TITLE :	DRAWN BY : DEXTER	SUBMITTED BY :	RECOMMENDING APPROVAL :	APPROVED BY :	SHEET CONTENT	SHEET NO.
PROPOSED REHABILITATION OF PAYATAS B ELEMENTARY SCHOOL	DATE : NOV. 17, 2020				ROOF PLAN AND FRONT ELEVATION (DEP ED CASTELO BLDG.)	
	CHECKED BY :					
BARANGAY PAYATAS, DISTRICT-2, QUEZON CITY	REVISION NO.:					

20-00145

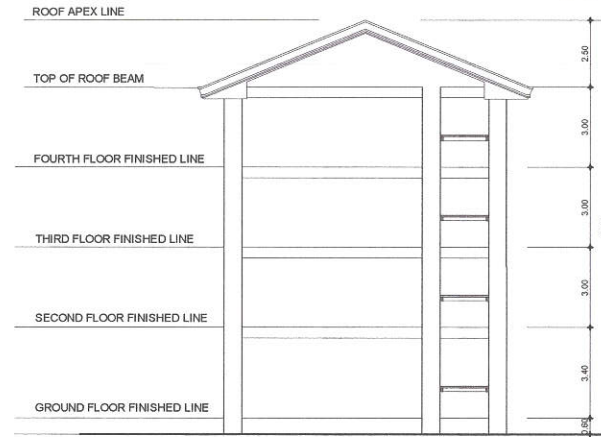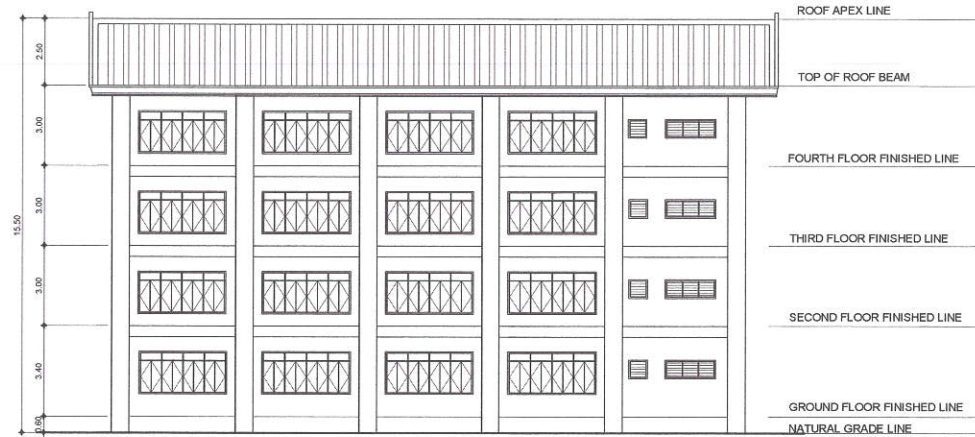

1 REAR ELEVATION (DEP ED CASTELO BUILDING) SCALE : 1 : 200 METERS

2 SECTION (DEP ED CASTELO BLDG.) SCALE : 1 : 200 METERS

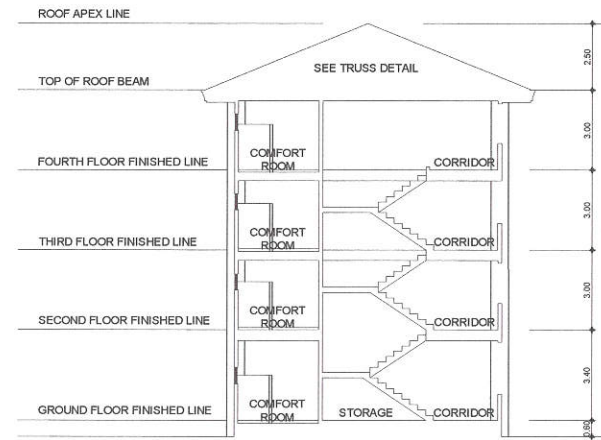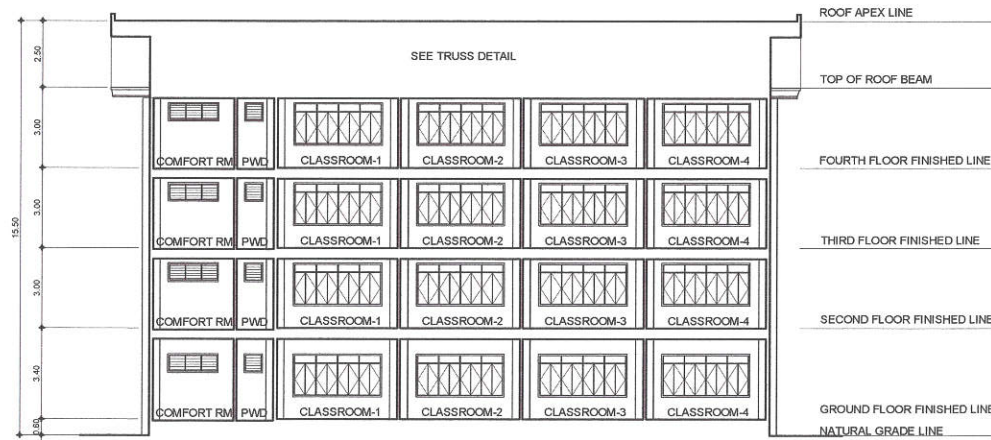

3 SIDE ELEVATION (DEP ED CASTELO BUILDING) SCALE : 1 : 200 METERS


4 SECTION (DEP ED CASTELO BLDG.) SCALE : 1 : 200 METERS



Republika ng Pilipinas
Lungsod ng Quezon
CITY ENGINEERING DEPARTMENT


PROJECT TITLE :	DRAWN BY : DEXTER	SUBMITTED BY :	RECOMMENDING APPROVAL :	APPROVED BY :	SHEET CONTENT	SHEET NO.
PROPOSED REHABILITATION OF PAYATAS B ELEMENTARY SCHOOL	DATE : NOV. 17, 2020				ROOF PLAN AND FRONT ELEVATION (DEP ED CASTELO BLDG.)	AR 30
	CHECKED BY :					
BARANGAY PAYATAS, DISTRICT-2, QUEZON CITY	REVISION NO.:					

20-00145

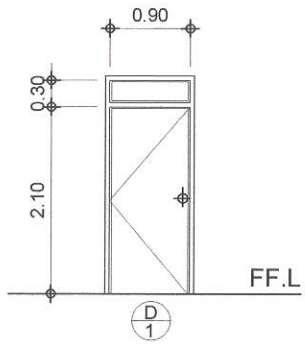


TYPE : PANEL DOOR W/ TRANSOM
LOCATION : CLASSROOMS

DOOR KNOB TO BE REPLACED

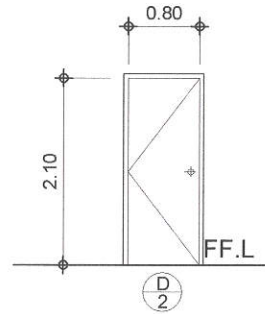


TYPE : FLUSH DOOR
LOCATION : STORAGE

DOOR KNOB TO BE REPLACED

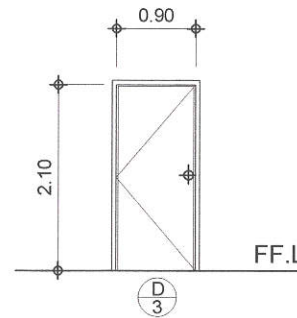

TYPE : FLUSH DOOR
LOCATION : COMFORT ROOMS
(MALE, FEMALE & PWD)

DOOR KNOB TO BE REPLACED

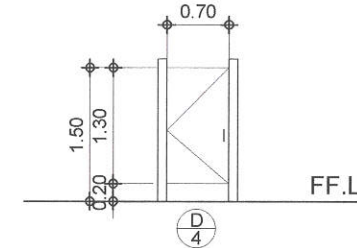

TYPE : FLUSH DOOR
LOCATION : COMFORT ROOMS
(MALE, FEMALE - CUBICLE)

1 SCHEDULE OF DOORS (DEP ED CASTELO BUILDING)

SCALE : 1 : 60 METERS



Republika ng Pilipinas
Lungsod ng Quezon
CITY ENGINEERING DEPARTMENT

PROJECT TITLE :	DRAWN BY : DEXTER	SUBMITTED BY :	RECOMMENDING APPROVAL :	APPROVED BY :	SHEET CONTENT	SHEET NO.
PROPOSED REHABILITATION OF PAYATAS B ELEMENTARY SCHOOL	DATE : NOV. 17, 2020				SCHEDULE OF DOORS & (DEP ED CASTELO BLDG.)	AR 31
	CHECKED BY :					
BARANGAY PAYATAS, DISTRICT-2, QUEZON CITY	REVISION NO.:					

EXISTING WALLS TO BE REPAINTED



EXISTING DOORS TO BE REPAINTED, REPLACED DOOR KNOBS AT BOLTS

20-00145

EXISTING DOORS TO BE REPAINTED, REPLACED DOOR KNOBS AT BOLTS



1 DEP ED CASTELO BUILDING (FACADE)

2 DEP ED CASTELO BUILDING (CORRIDOR)

EXISTING PLUMBING FIXTURES TO BE REPLACED



EXISTING DOORS TO BE REPAINTED, REPLACED DOOR KNOBS AT BOLTS



3 DEP ED CASTELO BUILDING (COMFORT ROOM-PWD)

4 DEP ED CASTELO BUILDING (COMFORT ROOMS)



Republika ng Pilipinas
Lungsod ng Quezon
CITY ENGINEERING DEPARTMENT

PROJECT TITLE :

**PROPOSED REHABILITATION OF
PAYATAS B ELEMENTARY SCHOOL**

BARANGAY PAYATAS, DISTRICT-2, QUEZON CITY

DRAWN BY : DEXTER

DATE : NOV. 17, 2020

CHECKED BY:

REVISION NO.:

SUBMITTED BY:

ENGR. LEO S. DEL ROSARIO
HEAD, PLANNING & PROGRAMMING DIVISION

RECOMMENDING APPROVAL :

ENGR. ISAGANI R. VERZOSA, JR.
OIC, CITY ENGINEERING DEPARTMENT

APPROVED BY :

HON. MA. JOSEFINA G. BELMONTE
CITY MAYOR, QUEZON CITY

SHEET CONTENT

ROOF PLAN AND
FRONT ELEVATION
(DEP ED CASTELO BLDG.)

SHEET NO.

**AR
32**