


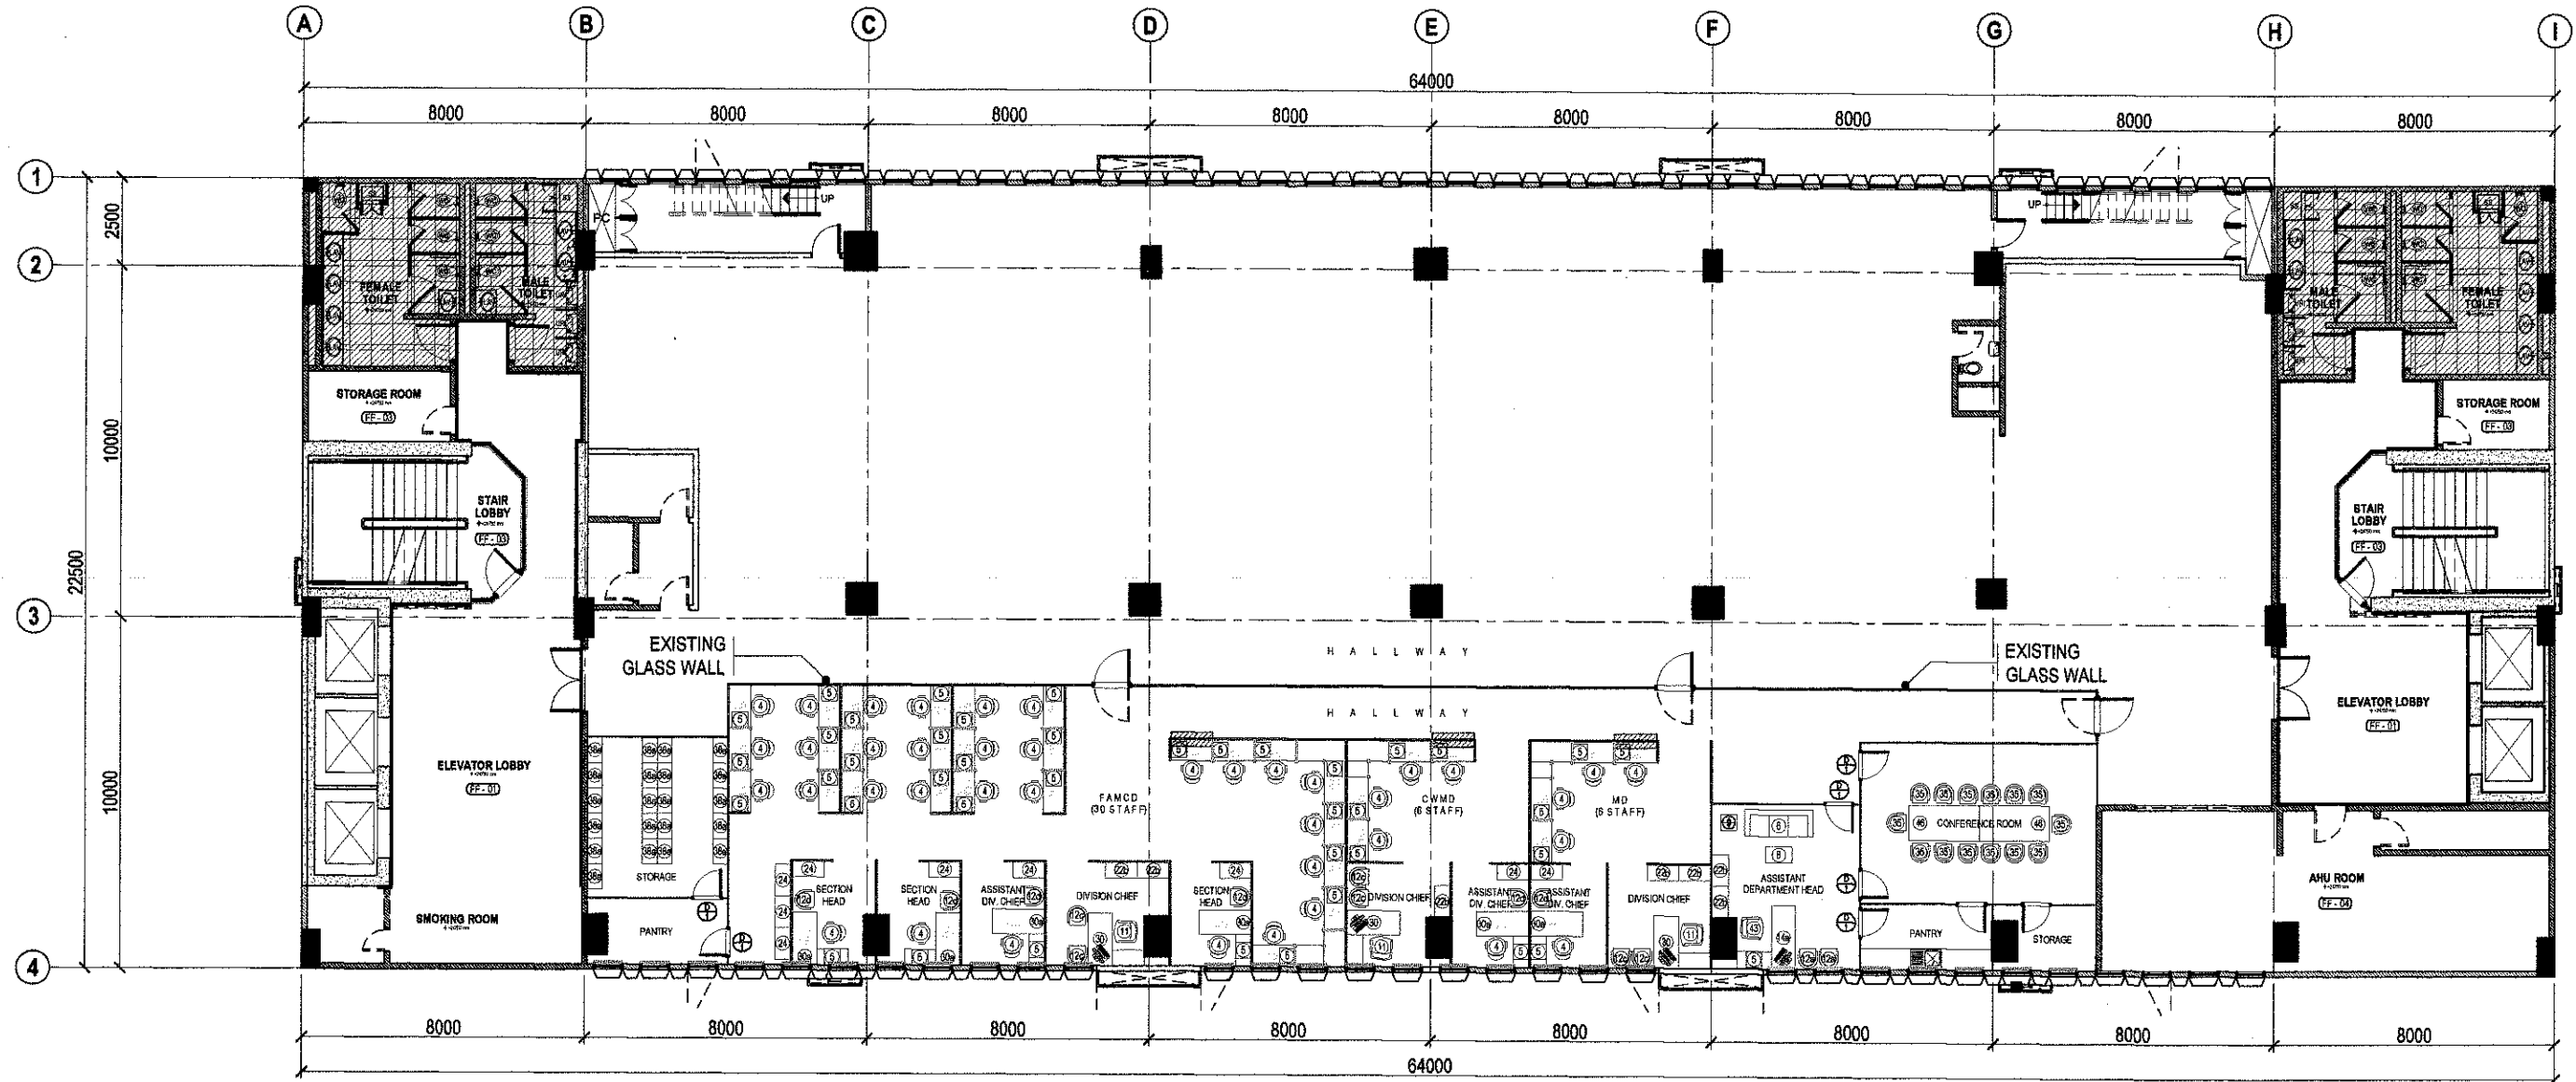

LEGEND:

	MODULAR LAMINATED PARTITION, WITH OR WITHOUT GLASS		ACRYLIC BARRIER
	FABRIC WITH GLASS LOW PARTITION, 1.50m HEIGHT		TUBULAR CHROME LEG
	DRYWALL PARTITION, PAINTED BOTH SIDES		
	TRANSACTION COUNTERTOP, 0.40m WIDTH		
	MODULAR DESK, 0.60m WIDTH		
	ROLLER SHADES (SUNSCREEN)		
	ROLLER SHADES (COMBI)		

FURNITURE:

	D1 MODULAR DOOR W/ HALF GLASS, SINGLE LEAF 0.8m X 2.10mH		8 RECTANGULAR CENTER TABLE, STAINLESS STEEL BASE		12d STAFF VISITOR'S CHAIR		30 FREE STANDING TABLE W/ SIDE TABLE, 1.50mL x 0.70mW		43 EXECUTIVE HIGH BACK CHAIR
	4 STAFF CHAIR		9 SIDE TABLE, STAINLESS STEEL BASE		13 VERTICAL FILING CABINET, 4 - DRAWERS		30a FREE STANDING TABLE W/ SIDE TABLE, 1.30mL x 0.60mW		46 CONFERENCE TABLE, 8 - SEATER
	5 MOBILE PEDESTAL		11 MANGER'S HIGH BACK CHAIR		14a EXECUTIVE TABLE W/ SIDE TABLE, 1.80mL x 0.90mW x 0.75mH		35 CONFERENCE CHAIR		
	5a EXECUTIVE MOBILE PEDESTAL		12a EXECUTIVE VISITOR'S CHAIR, MESH TYPE		22b LOW CABINET, 0.90mL x 0.45mW x 1.06mH		38a CUSTOMIZED STEEL RACK, 0.72mW x 0.41mD x 2.20mH		
	6 SOFA, 3 - SEATER		12c MANAGER VISITOR'S CHAIR, LEATHERETTE		24 LATERAL FILING CABINET, 3 - DRAWERS		42 WORKING TABLE, 2.40mL x 1.2mW		

1 EIGHTH FLOOR FURNITURE LAYOUT

SCALE 1:200 METERS



Republic of the Philippines
Lungsod ng Quezon
CITY ARCHITECT DEPARTMENT
5F CIVIC CENTER - D (Bldg. 844), QUEZON CITY HALL COMPOUND,
ELLIPTICAL ROAD, DULAMAN, QUEZON CITY



PROVISO:

DRAWING AND SPECIFICATIONS ONLY SHOWN, STAMPED OR SEALED AS INSTRUMENTS OF SERVICE ARE THE INTELLECTUAL PROPERTIES & DOCUMENTS OF THE CITY ARCHITECT'S DEPARTMENT. UNDER THE OBJECT FOR WHICH THEY ARE MADE IS DISPUTED OR NOT, IT SHALL BE INEFFECTIVE FOR ANY PERSON, WITHOUT THE CONSENT OF THE AUTHORITY OF SAID DOCUMENTS TO DUPLICATE OR TO MAKE COPIES OF SAID DOCUMENTS FOR USE IN THE REPRODUCTION OF AND FOR OTHER PROJECTS OR BUILDINGS, WHETHER FREQUENTED PARTLY OR IN WHOLE.

RECOMMENDING APPROVAL

ARCH. L. VILLE H. CHUA, *tuasp, plup*
CITY ARCHITECT

APPROVED BY:

HON. MA. JOSEFINA G. BELMONTE
MAYOR

PROJECT TITLE:

SUPPLY AND INSTALLATION OF MODULAR PARTITIONS INCLUDING FURNITURE, AND OTHER WORKS FOR THE CITY GENERAL SERVICES DEPARTMENT @ 8TH FLOOR, Q.C. HALL MAIN BUILDING

LOCATION: QUEZON CITY HALL COMPOUND ELLIPTICAL ROAD
BARANGAY CENTRAL QUEZON CITY

SHEET CONTENTS:

**8TH FLOOR - GENERAL SERVICES
DEPT. FURNITURE LAYOUT**

PROJECT NO.:

DATE: December 2021
DRAWN BY: K.C.M.
DESIGNED BY: Ar. J.U. Cabal, Ar. R.I. Beltran
CHECKED BY: Ar. R.G. Resurreccion


SHEET NO.:

AR-01




SCALE 1:80 METERS




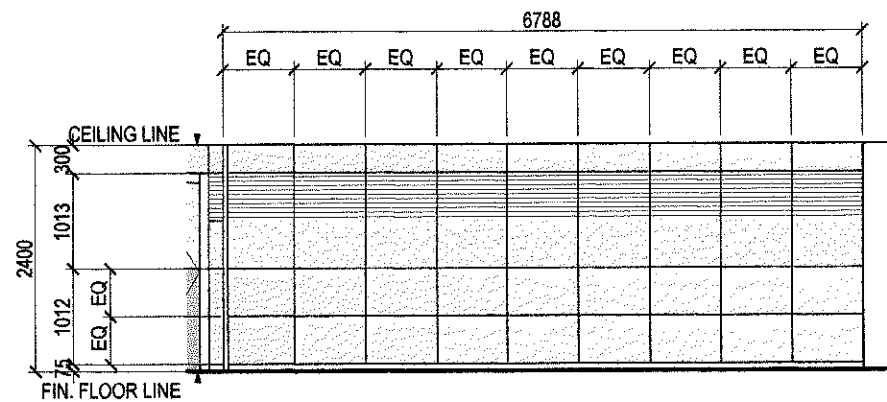


ELEVATION 'A'

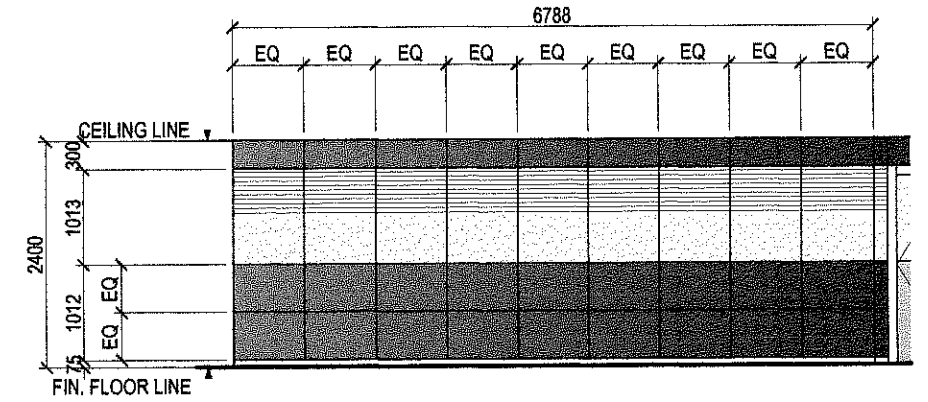


ELEVATION 'B'

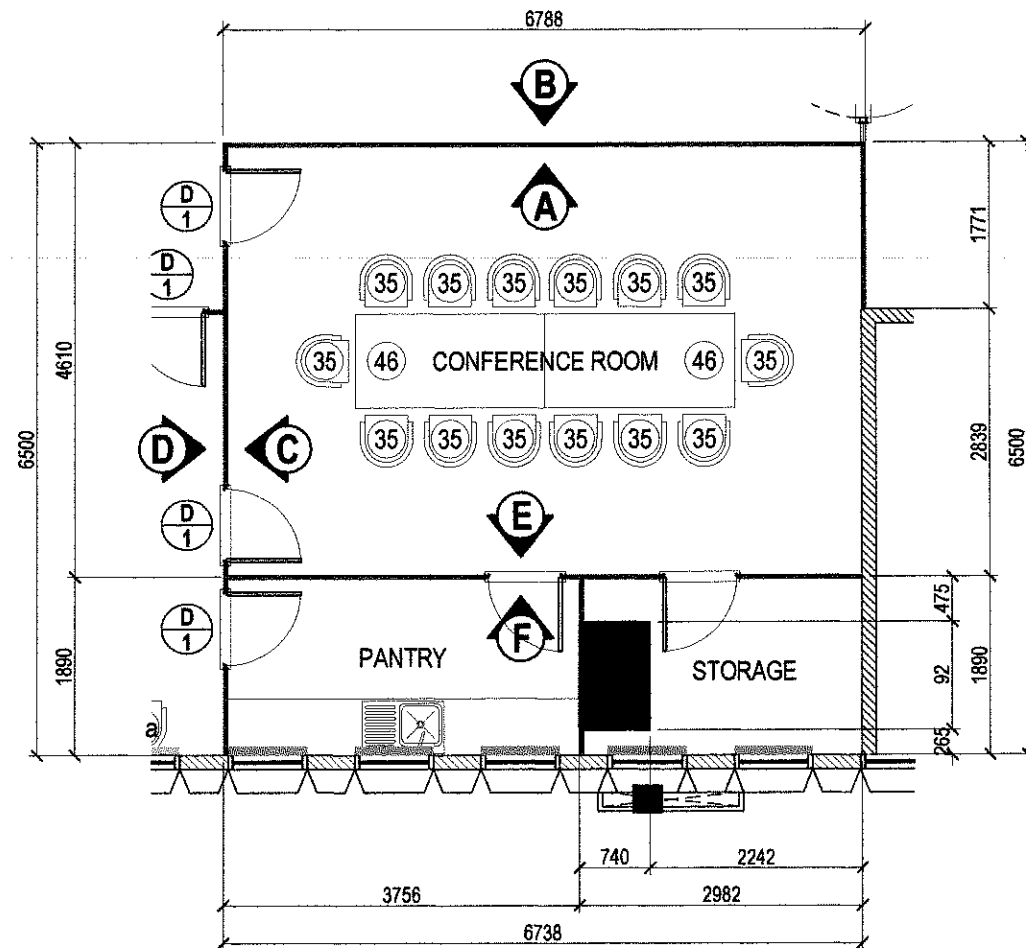


BLOW - UP PLAN

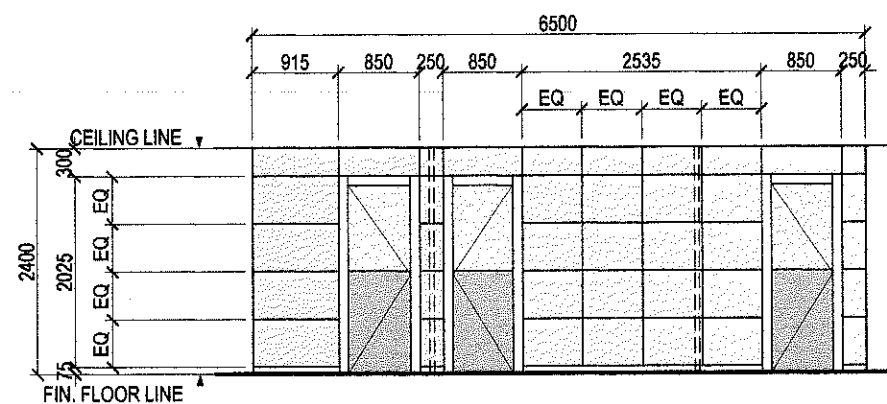


ELEVATION 'C'

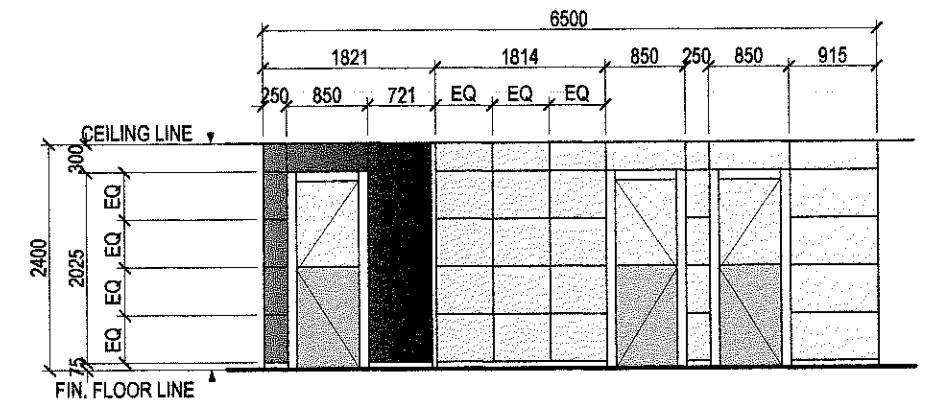

ELEVATION 'D'

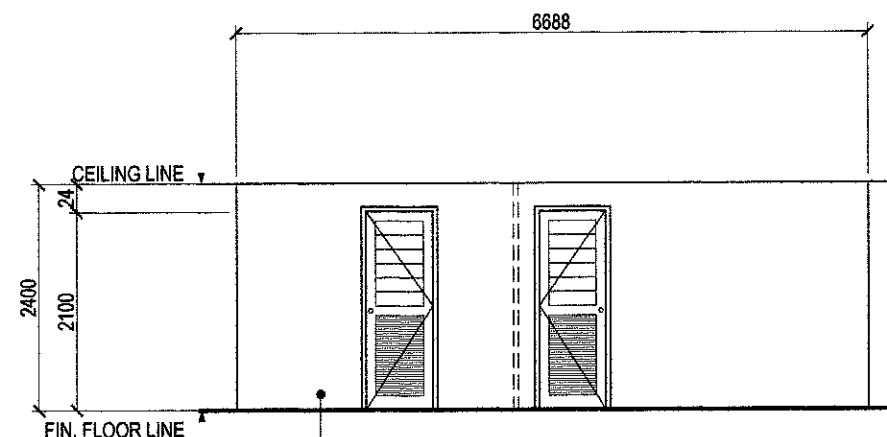

ELEVATION 'E'

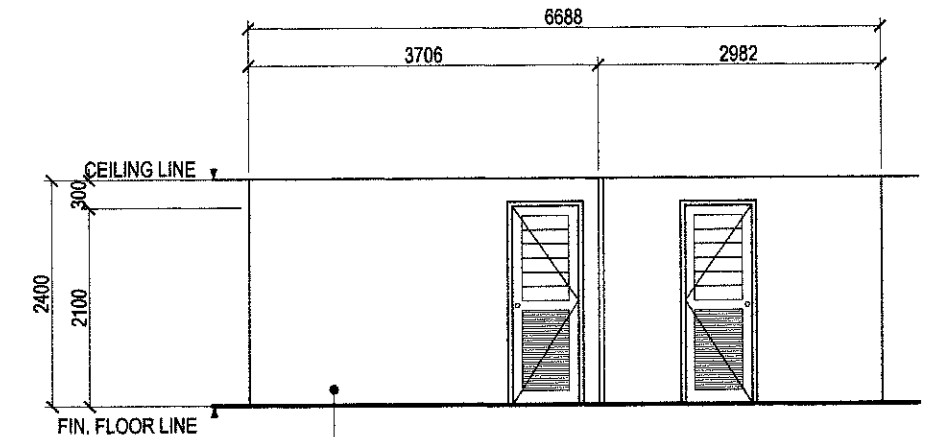

ELEVATION 'F'

1 ELEVATION / SECTION OF CONFERENCE ROOM (W/ PANTRY, AND STORAGE ROOM)

SCALE 1:80 METERS



Republika ng Pilipinas
Lungsod ng Quezon
CITY ARCHITECT DEPARTMENT
5F CIVIC CENTER - D (Bldg. 369), QUEZON CITY HALL COMPOUND,
ELLIPTICAL ROAD, DILIMAN, QUEZON CITY



PROVISO:

DRAWINGS AND SPECIFICATIONS DULY
REVISED, STAMPED, OR SEALED BY
INSTRUMENTS OF SERVICE ARE THE
PROPERTY OF THE CITY ARCHITECT DEPARTMENT.
WHETHER THE OBJECT FOR WHICH THEY
ARE USED IS EXCLUDED OR NOT, IT SHALL
BE UNLAWFUL FOR ANY PERSON WITHOUT
THE CONSENT OF THE ARCHITECT OF SAID
DOCUMENTS TO REPRODUCE OR TO MAKE
COPIES OF SAID DOCUMENTS FOR USE IN
THE REPRODUCTION OF ANY OTHER
PROJECTS OR BUILDINGS, WHETHER
REGISTERED, PARTIAL, OR IN WHOLE.

RECOMMENDING APPROVAL

ARCH. NICOLE H. CHUA, fuap, plep
CITY ARCHITECT

APPROVED BY:

HON. MA. JOSEFINA G. BELMONTE
MAYOR

PROJECT TITLE:

SUPPLY AND INSTALLATION OF MODULAR PARTITIONS
INCLUDING FURNITURE, AND OTHER WORKS FOR THE
CITY GENERAL SERVICES DEPARTMENT @ 8TH FLOOR,
Q.C. HALL MAIN BUILDING

LOCATION: QUEZON CITY HALL COMPOUND ELLIPTICAL ROAD
BARANGAY CENTRAL QUEZON CITY

SHEET CONTENTS:


ELEVATION / SECTION OF
CONFERENCE ROOM
(WITH PANTRY, & STORAGE ROOM)

PROJECT NO.:


DATE: December 2021
DRAWN BY: K.C.M.
DESIGNED BY: Ar. J.U. Cordero & R. Belmonte
CHECKED BY: Ar. R.G. Resurreccion

SHEET NO.:


AR-03

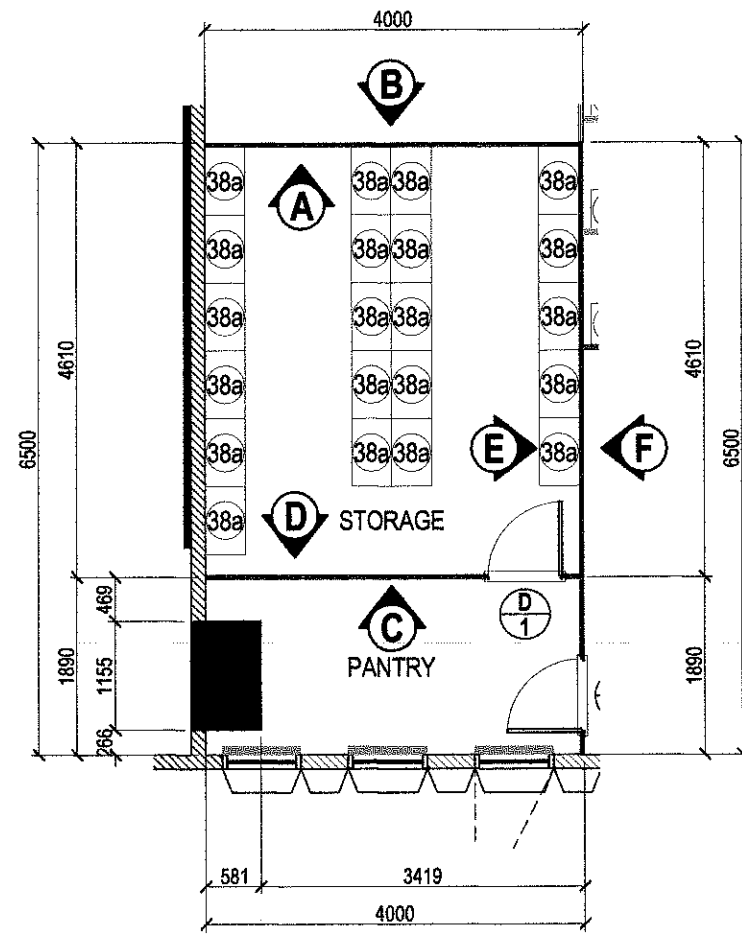


BLOW - UP PLAN

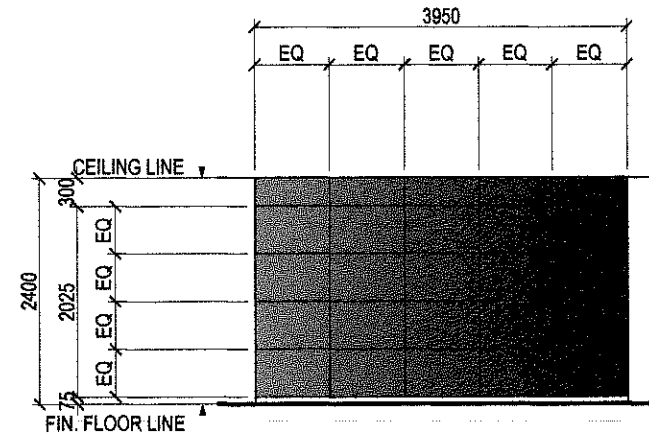


ELEVATION 'B'

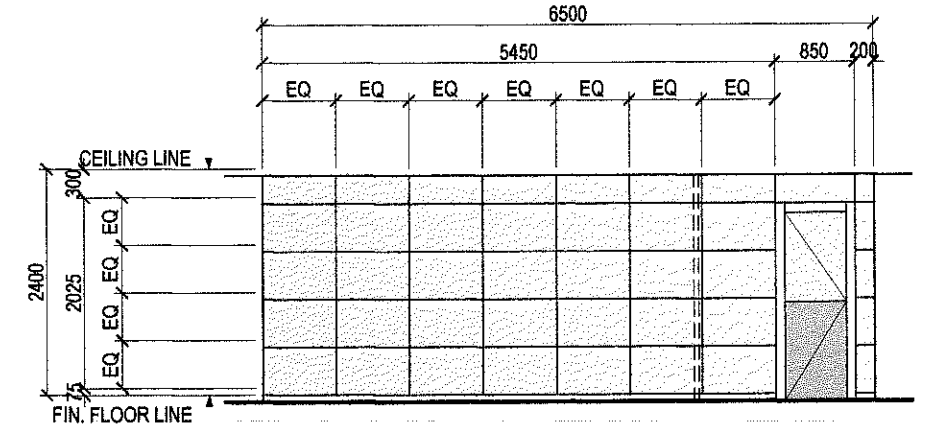


ELEVATION 'E'

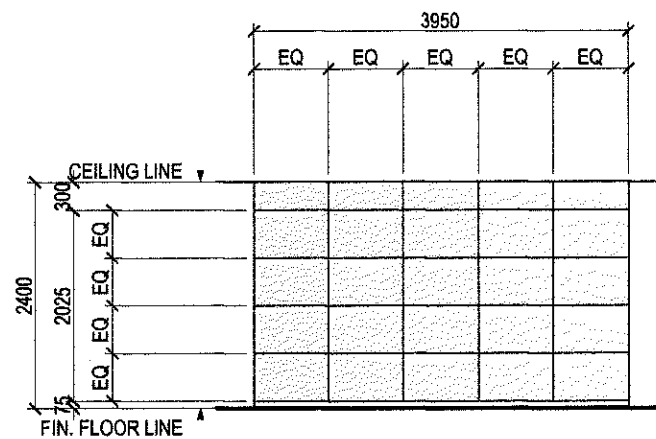

ELEVATION 'A'

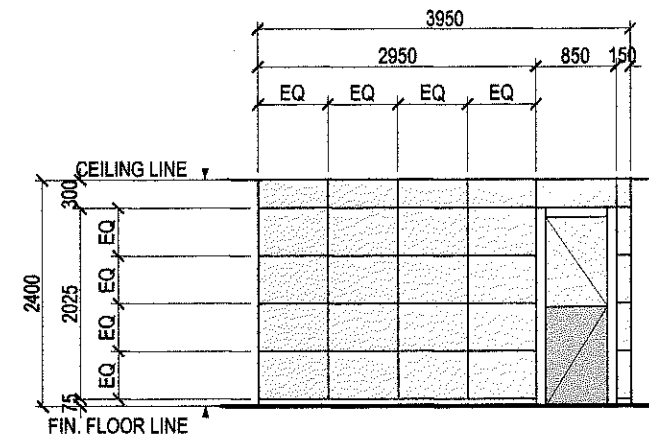

ELEVATION 'C' / 'D'

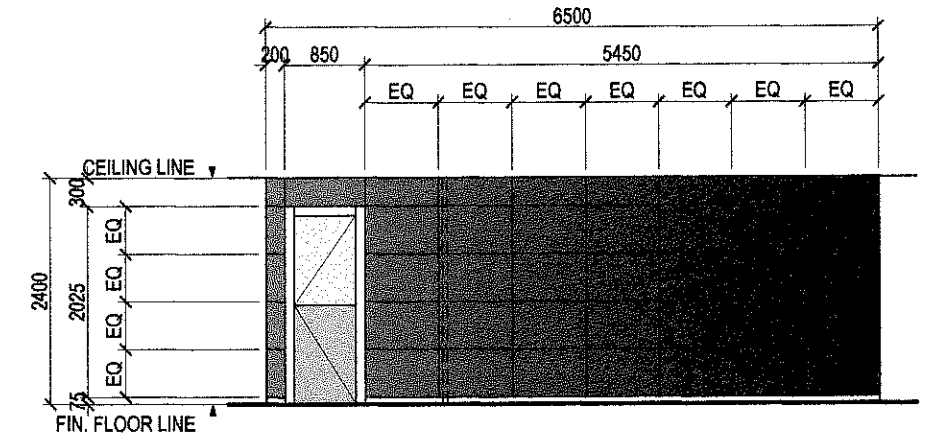

ELEVATION 'F'

1 ELEVATION / SECTION OF STORAGE ROOM, AND PANTRY

SCALE 1:80 METERS



Republika ng Pilipinas
Lungsod ng Quezon
CITY ARCHITECT DEPARTMENT
6/F CIVIC CENTER - D (BRO. Bldg.) QUEZON CITY HALL COMPOUND,
ELLIPTICAL ROAD, DILIMAN, QUEZON CITY



PROVISO:

DRAWINGS AND SPECIFICATIONS DULY
SIGNED, STAMPED OR SEALED AS
INSTRUMENTS OF SERVICE AND THE
INTELLECTUAL PROPERTY & DOCUMENTS
OF THE CITY ARCHITECT'S DEPARTMENT.
WHETHER THE OBJECT FOR WHICH THEY
ARE MADE IS EXISTING OR NOT, IT SHALL
BE UNLAWFUL FOR ANY PERSON, WITHOUT
THE CONSENT OF THE AUTHOR OF SAID
DOCUMENTS TO REPRODUCE OR TO MAKE
COPIES OF SAID DOCUMENTS FOR USE IN
THE REPRODUCTION OF AND FOR OTHER
PROJECTS OR BUILDINGS, WHETHER
EXECUTED WHOLLY OR IN WHOLE

RECOMMENDING APPROVAL

[Signature]
ARCH. LUCILLE H. CHUA, fuap, plep
CITY ARCHITECT

APPROVED BY:

[Signature]
HON. MA. JOSEFINA G. BELMONTE
MAYOR Q.C.

PROJECT TITLE:

**SUPPLY AND INSTALLATION OF MODULAR PARTITIONS
INCLUDING FURNITURE, AND OTHER WORKS FOR THE
CITY GENERAL SERVICES DEPARTMENT @ 8TH FLOOR,
Q.C. HALL MAIN BUILDING**

LOCATION: QUEZON CITY HALL COMPOUND ELLIPTICAL ROAD
BARANGAY CENTRAL QUEZON CITY

SHEET CONTENTS :


**ELEVATION / SECTION OF STORAGE
ROOM, AND PANTRY**

PROJECT NO.:


DATE December 2021
DRAWN BY K.C.M.
DESIGNED BY Ar. J.U. Coso, Mr. R.I. Beltran
CHECKED BY Ar. R.S. Resurreccion

SHEET NO.:


AR-04

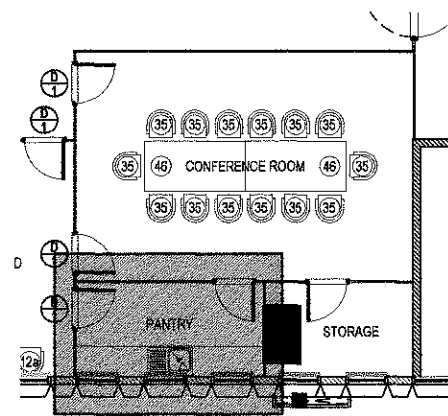


KEY PLAN

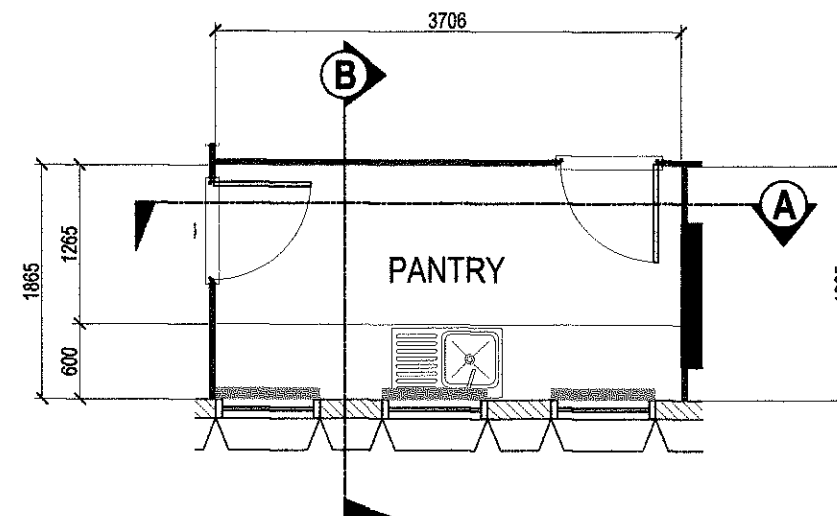

BLOW - UP PLAN

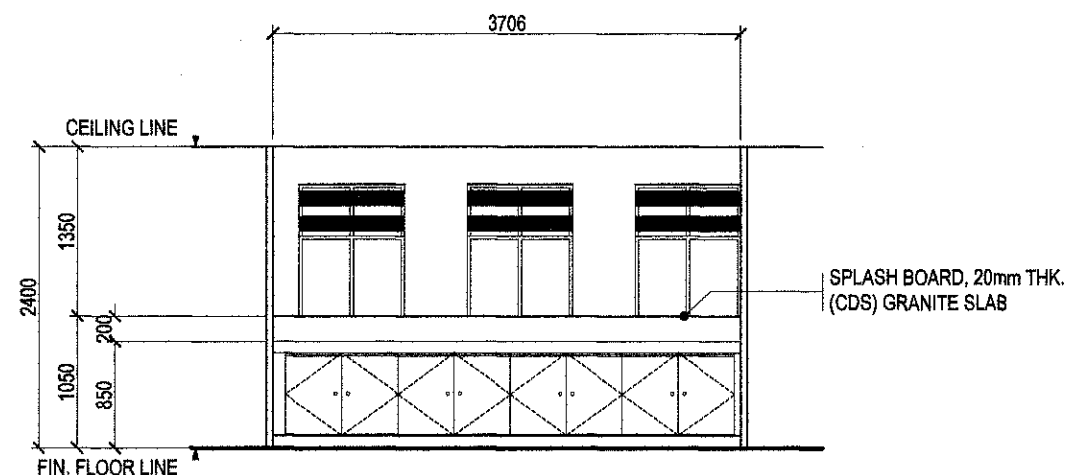

SECTION THRU 'A'

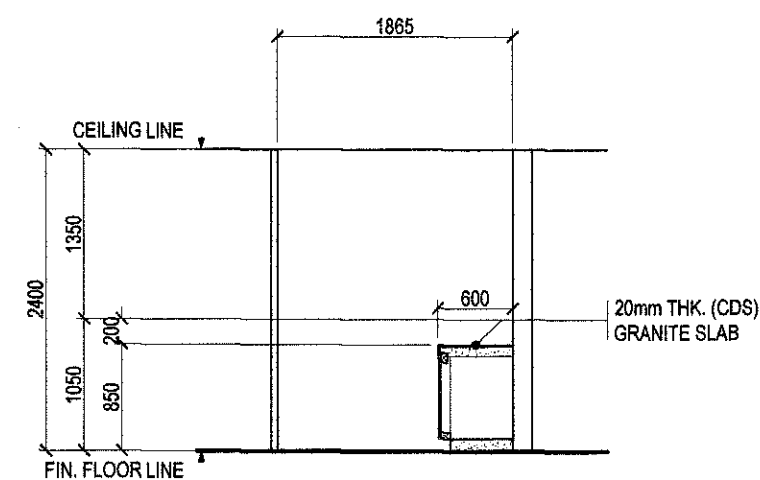

SECTION THRU 'B'

1 | DETAIL OF PANTRY @ CONFERENCE ROOM - 8TH FLOOR

SCALE 1:60 METERS



Republika ng Pilipinas
Lungsod ng Quezon
CITY ARCHITECT DEPARTMENT
OFFICE CENTER - D (BRO. B&M), QUEZON CITY HALL COMPOUND,
ELLIPTICAL ROAD, DILIMAN, QUEZON CITY



PROVIDO:

DRAWINGS AND SPECIFICATIONS ONLY
SIGNED, STAMPED OR SEALED AS
INSTRUMENTS OF SERVICE ARE THE
PROPERTY OF THE CITY ARCHITECTS DEPARTMENT.
WHETHER THE SUBJECT FOR WHICH THEY
ARE MADE IS EXISTING OR NOT, IT SHALL
BE UNLAWFUL FOR ANY PERSON, WITHOUT
THE CONSENT OF THE AUTHOR OF SAID
DOCUMENTS TO REPRODUCE OR TO MAKE
COPIES OF SAID DOCUMENTS FOR USE IN
THE REPRODUCTION OF AND FOR OTHER
PROJECTS OR BUILDINGS, WHETHER
EXECUTED PARTLY OR IN WHOLE.

RECOMMENDING APPROVAL

[Signature]
ARCH. LUIS H. CHUA, fuap, plep
CITY ARCHITECT

APPROVED BY:

[Signature]
HON. MA. JOSEFINA G. BELMONTE
MAYOR
O.C.

PROJECT TITLE:

**SUPPLY AND INSTALLATION OF MODULAR PARTITIONS
INCLUDING FURNITURE, AND OTHER WORKS FOR THE
CITY GENERAL SERVICES DEPARTMENT @ 8TH FLOOR,
O.C. HALL, MAIN BUILDING**
LOCATION: QUEZON CITY HALL COMPOUND ELLIPTICAL ROAD
BARANGAY CENTRAL QUEZON CITY

SHEET CONTENTS:


DETAIL OF PANTRY @ CONFERENCE
ROOM - 8TH FLOOR

PROJECT NO.:

DATE: December 2021
DRAWN BY: K.C.M.
DESIGNED BY: Ar. J.U. Coset
CHECKED BY: Ar. R.G. Resurreccion

SHEET NO.:

AR-05

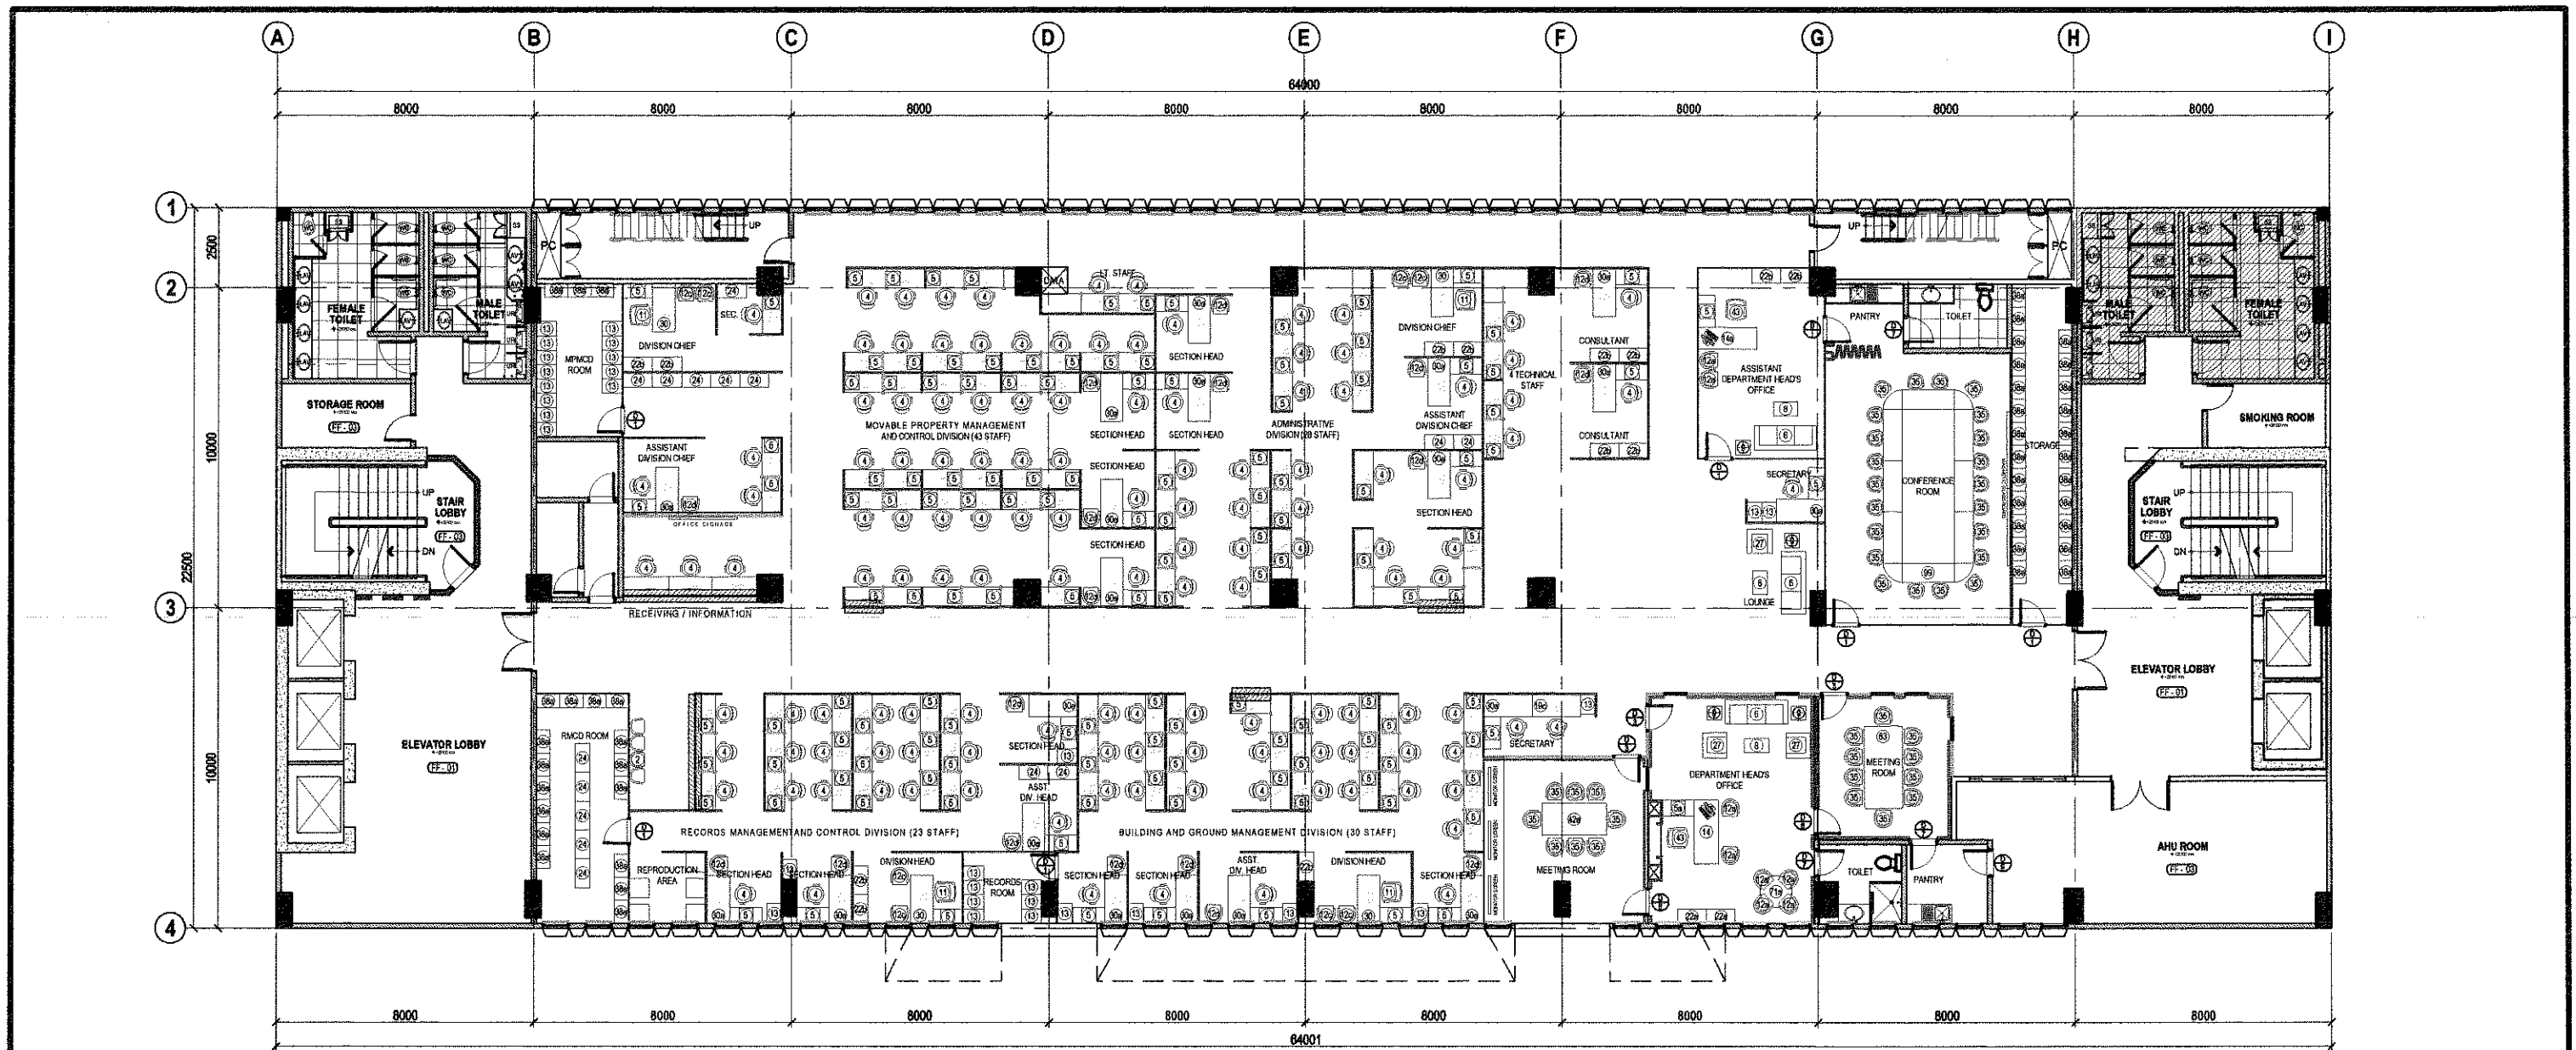

LEGEND:

	MODULAR LAMINATED PARTITION, WITH OR WITHOUT GLASS
	FABRIC WITH GLASS LOW PARTITION, 1.50m HEIGHT
	DRYWALL PARTITION, PAINTED BOTH SIDES
	DRYWALL PARTITION, LAMINATED BOTH SIDES
	DRYWALL PARTITION, LAMINATED ONE SIDE, WALLPAPER ONE SIDE
	DRYWALL PARTITION, LAMINATED ONE SIDE, PAINTED ONE SIDE
	DRYWALL PARTITION, WALLPAPER BOTH SIDES
	DRYWALL PARTITION, WALLPAPER ONE SIDE, PAINTED ONE SIDE
	WALLPAPER FINISH
	TRANSACTION COUNTERTOP, 0.40m WIDTH
	MODULAR DESK, 0.60m WIDTH
	ROLLER SHADES (SUNSCREEN)
	ROLLER SHADES (COMBI)
	ROLLER SHADES (BLACK-OUT)
	ACRYLIC BARRIER
	TUBULAR CHROME LEG
	FOLDING DOOR


FURNITURE:

D1	MODULAR DOOR W/ HALF GLASS, SINGLE LEAF 0.8m X 2.10mH
D3	PANEL TYPE DOOR WITH HALF GLASS, WITH DUCCO FINISH, 0.80mW x 2.10mH
D7	FLUSH TYPE DOOR W/ LOUVER, PAINTED FINISH BOTH SIDES, 0.70mW x 2.10mH
D8	FLUSH TYPE DOOR, W/ WALLPAPER FINISH BOTH SIDES, 0.70mW x 2.10mH
4	STAFF CHAIR
5	MOBILE PEDESTAL
5a	EXECUTIVE MOBILE PEDESTAL
6	SOFA, 3 - SEATER
8	RECTANGULAR CENTER TABLE, STAINLESS STEEL BASE
9	SIDE TABLE, STAINLESS STEEL BASE
11	MANGER'S HIGH BACK CHAIR
12a	EXECUTIVE VISITOR'S CHAIR, MESH TYPE
12c	MANAGER VISITOR'S CHAIR, LEATHERETTE
12d	STAFF VISITOR'S CHAIR
13	VERTICAL FILING CABINET, 4 - DRAWERS
14	EXECUTIVE TABLE W/ SIDE TABLE, 2.00mL x 1.00mW x 0.75mH
14a	EXECUTIVE TABLE W/ SIDE TABLE, 1.80mL x 0.90mW x 0.75mH
19c	FREE STANDING TABLE, 1.50mL x 0.60mW
22a	WOOD LATERAL FILING CABINET, 0.90mL x 0.45mW x 1.06mH
22b	LOW CABINET, 0.90mL x 0.45mW x 1.06mH
24	LATERAL FILING CABINET, 3 - DRAWERS
27	SOFA, 1 - SEATER
30	FREE STANDING TABLE W/ SIDE TABLE, 1.50mL x 0.70mW
30a	FREE STANDING TABLE W/ SIDE TABLE, 1.30mL x 0.60mW
35	CONFERENCE CHAIR
38a	CUSTOMIZED STEEL RACK, 0.72mW x 0.41mD x 2.20mH
42a	WORKING TABLE, 2.00mL x 1.00mW
43	EXECUTIVE HIGH BACK CHAIR
71a	ROUND TABLE, GLASS TOP, 0.90m Ø
83	CONFERENCE TABLE, 10 - SEATER
99	O-SHAPED CONFERENCE TABLE, 22 - SEATER


1 NINTH FLOOR FURNITURE LAYOUT

SCALE 1:200 METERS


	Republic of the Philippines City of Quezon City CITY ARCHITECT DEPARTMENT 5F CIVIC CENTER - D (Bldg. 344), QUEZON CITY HALL COMPOUND, ELLIPTICAL ROAD, DILIMAN, QUEZON CITY	PROVIDO: DRAWINGS AND SPECIFICATIONS DULY SIGNED, STAMPED OR SEALED AS INSTRUMENTS OF SERVICE ARE THE PROPERTY OF THE CITY ARCHITECTS DEPARTMENT, WHETHER THE SUBJECT MATTER THEREOF IS OR IS NOT IN THE PUBLIC DOMAIN. NO PART THEREOF SHALL BE REPRODUCED OR TRANSMITTED IN ANY FORM OR BY ANY MEANS, ELECTRONIC OR MECHANICAL, INCLUDING PHOTOCOPYING, RECORDING, OR BY ANY INFORMATION STORAGE AND RETRIEVAL SYSTEM, WITHOUT THE WRITTEN PERMISSION OF THE CITY ARCHITECTS DEPARTMENT.	RECOMMENDING APPROVAL LUCILLE H. CHUA , fup, plep CITY ARCHITECT	APPROVED BY: HON. MA. JOSEFINA G. BELMONTE MAYOR	PROJECT TITLE: SUPPLY AND INSTALLATION OF MODULAR PARTITIONS INCLUDING FURNITURE, AND OTHER WORKS FOR THE CITY GENERAL SERVICES DEPARTMENT @ 9TH FLOOR, Q.C. HALL MAIN BUILDING LOCATION: QUEZON CITY HALL COMPOUND ELLIPTICAL ROAD, DILIMAN, QUEZON CITY	SHEET CONTENTS: 9TH FLOOR - GENERAL SERVICES DEPT. FURNITURE LAYOUT	PROJECT NO.: DATE: December 2021 DRAWN BY: K.C.M. DESIGNED BY: Ar. J.U. Coda, Ar. R.L. Beltran CHECKED BY: Ar. R.C. Resurreccion	SHEET NO.: AR-06
--	--	---	---	---	--	--	--	----------------------------

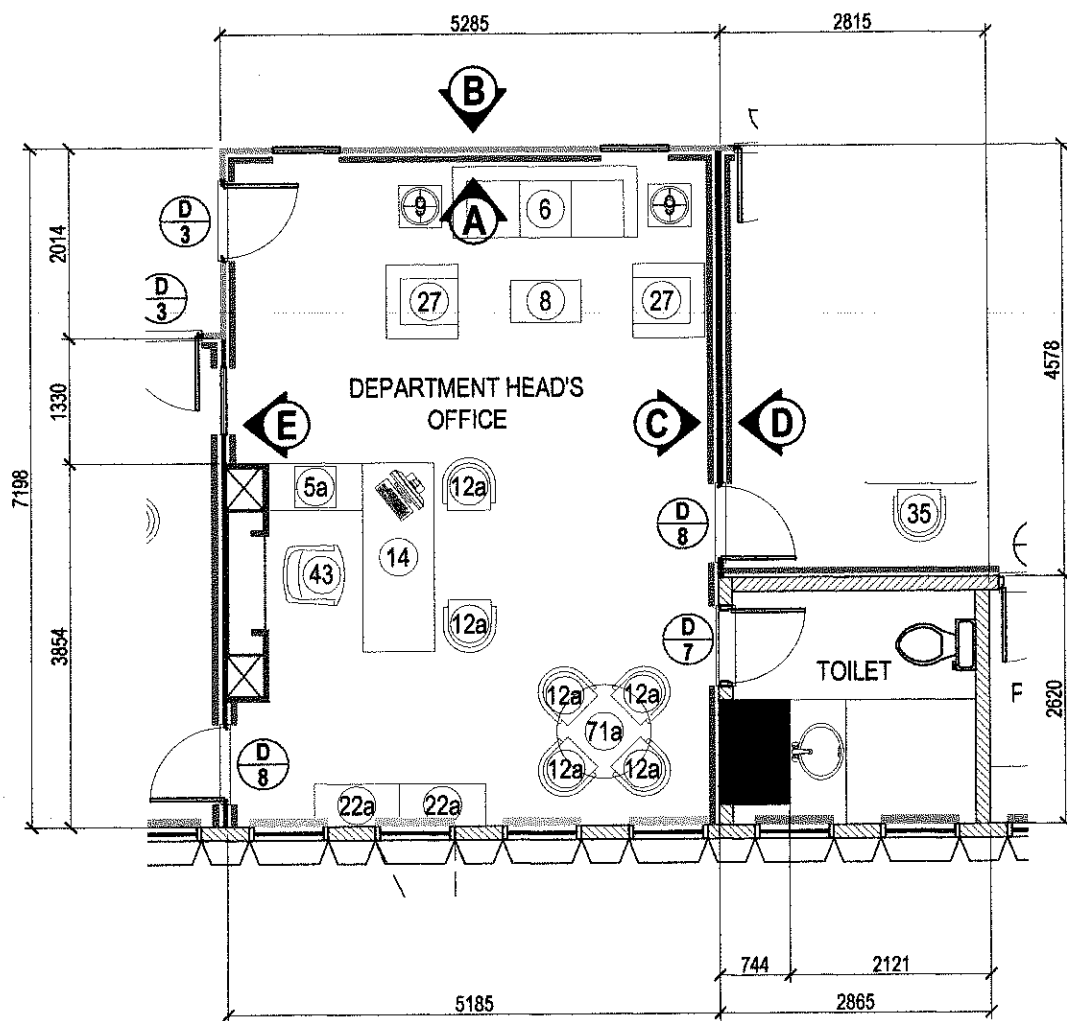


BLOW - UP PLAN

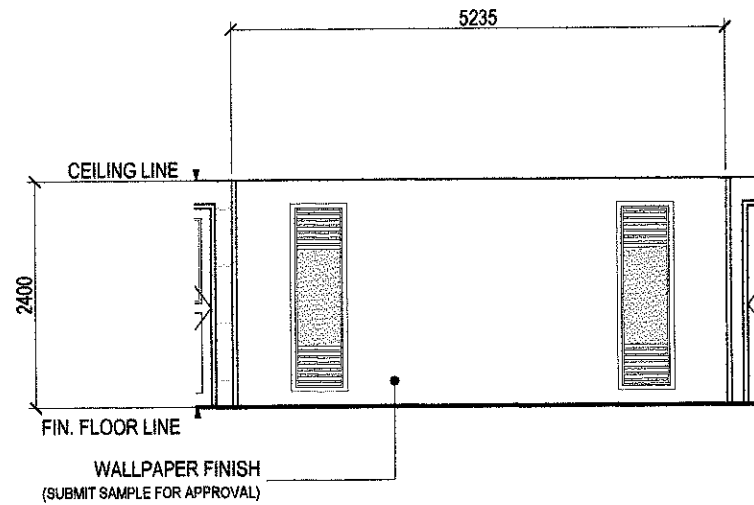


ELEVATION 'A'

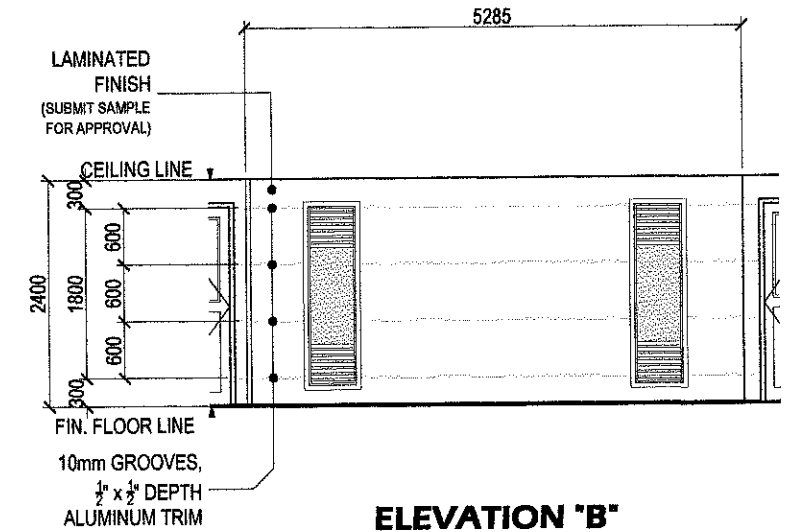


ELEVATION 'B'

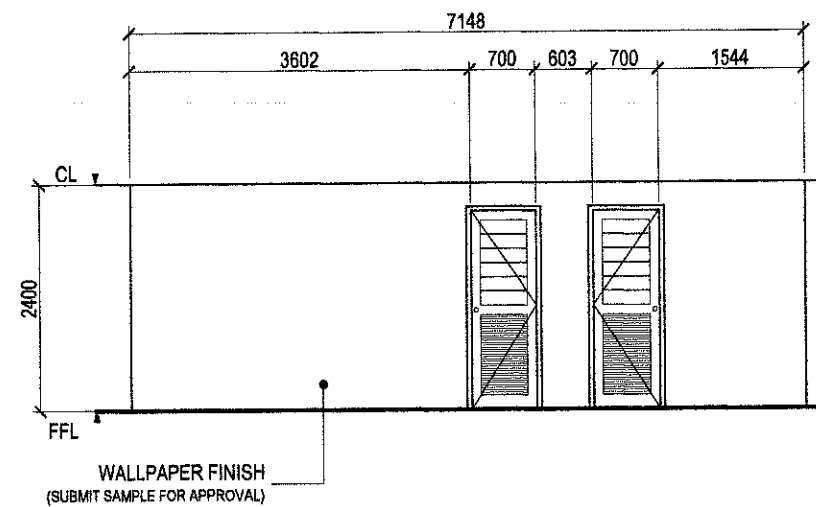

ELEVATION 'C'

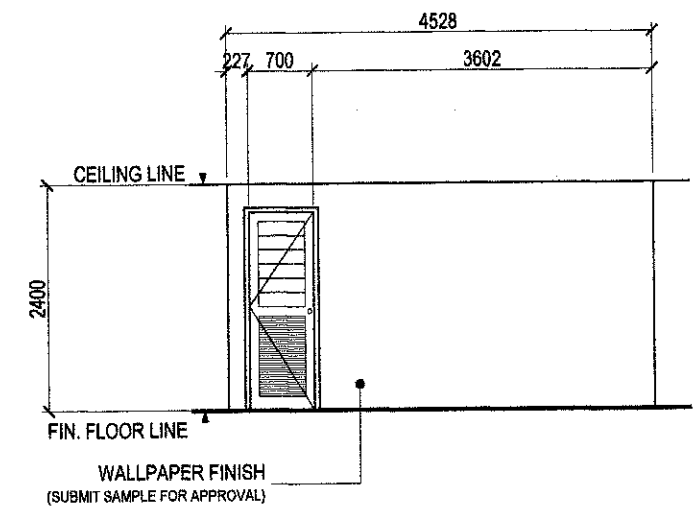


ELEVATION 'D'

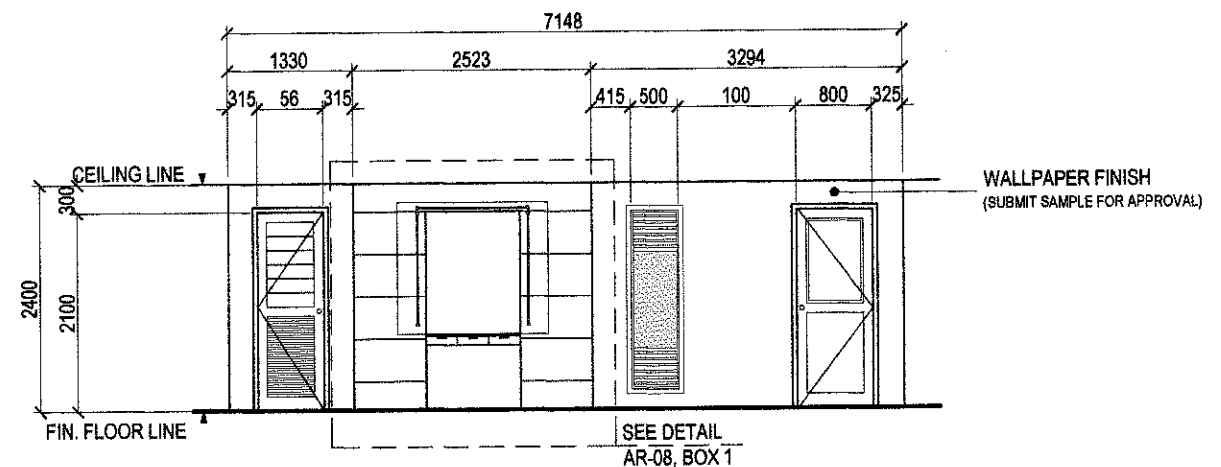


ELEVATION 'E'


1 ELEVATION / SECTION OF THE DEPARTMENT HEAD'S OFFICE

 SCALE 1:80 METERS

 Republika ng Pilipinas Lungsod ng Quezon CITY ARCHITECT DEPARTMENT 5F CMG CENTER - D (Bldg. 804), QUEZON CITY HALL COMPOUND, ELLIPTICAL ROAD, DILIMAN, QUEZON CITY	PROVIDO: DRAWINGS AND SPECIFICATIONS ONLY SHOWN, STAMPED OR SEALED AS INSTRUMENTS OF SERVICE ARE THE INTELLECTUAL PROPERTIES & DOCUMENTS OF THE CITY ARCHITECT DEPARTMENT. WHETHER THE OBJECT FOR WHICH THEY ARE MADE IS EXERCISED OR NOT, IT SHALL BE UNLAWFUL FOR ANY PERSON, WITHOUT THE CONSENT OF THE AUTHOR OF SAID DOCUMENTS TO REPRODUCE OR TO MAKE COPIES OF SAID DOCUMENTS FOR USE IN THE EXECUTION OF AND FOR OTHER PROJECTS OR BUILDINGS, WHETHER EXECUTED BY THE CITY ARCHITECT	RECOMMENDING APPROVAL  ARCH. L. L. H. CHUA, fuap, plep CITY ARCHITECT	APPROVED BY:  HON. MA. JOSEFINA G. BELMONTE MAYOR	PROJECT TITLE: SUPPLY AND INSTALLATION OF MODULAR PARTITIONS INCLUDING FURNITURE, AND OTHER WORKS FOR THE CITY GENERAL SERVICES DEPARTMENT @ 9TH FLOOR, Q.C. HALL MAIN BUILDING LOCATION: QUEZON CITY HALL COMPOUND ELLIPTICAL ROAD BARANGAY CENTRAL QUEZON CITY	SHEET CONTENTS: ELEVATION / SECTION OF THE DEPARTMENT HEAD'S OFFICE	PROJECT NO.: DATE: December 2021 DRAWN BY: K.C.M. DESIGNED BY: Ar. J.U. Cordero CHECKED BY: Ar. R.G. Resurreccion	SHEET NO.: AR-07
---	--	---	---	--	---	---	---------------------------------------

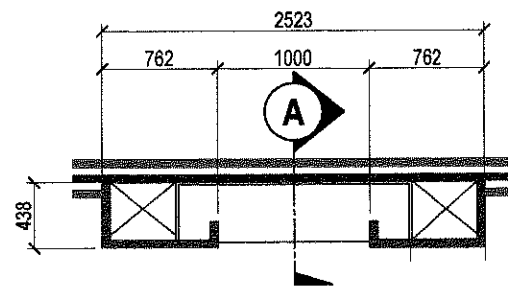


BLOW - UP PLAN

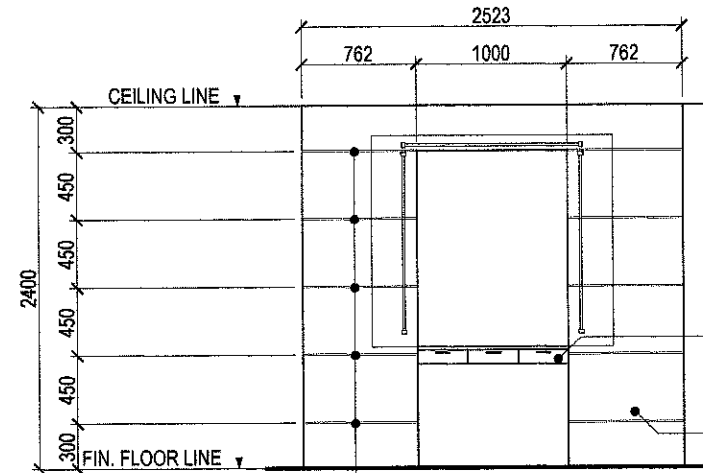

10mm GROOVES,
1/2" x 1/2" DEPTH
ALUMINUM TRIM

ELEVATION


2" Ø DIRECTIONAL
LIGHTING
T5 LIGHTING,
U-ARRANGEMENT
PAINTED PLYWOOD
BACKING
DRAWER W/ STAINLESS
STEEL HANDLE
WOOD LAMINATE
(COLOR TO ARCHITECT'S APPROVAL)

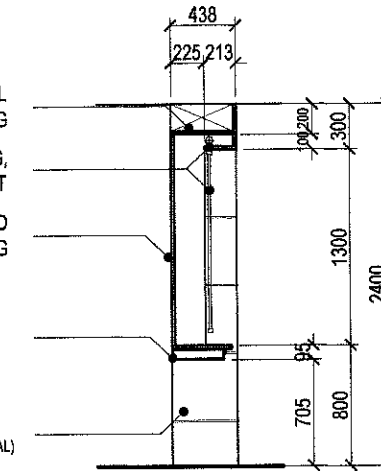


SECTION THRU 'A'

1 TYPICAL DETAIL OF BACK WALL


SCALE 1:50 METERS

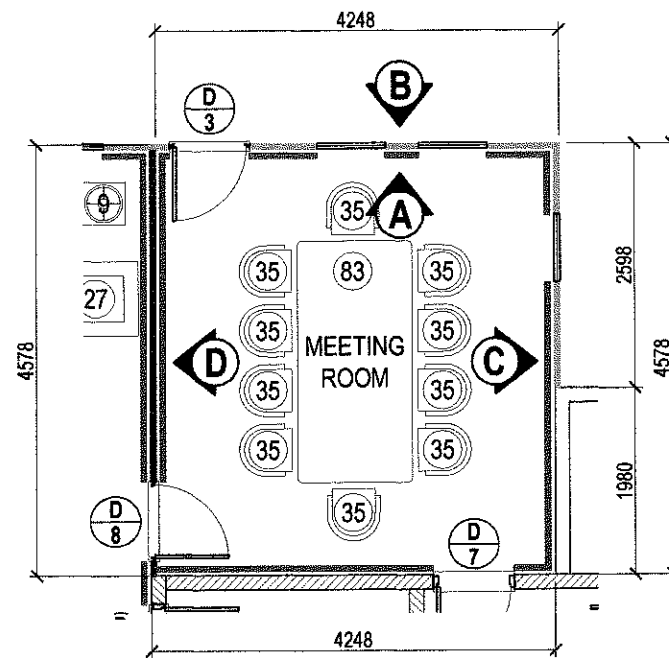


BLOW - UP PLAN

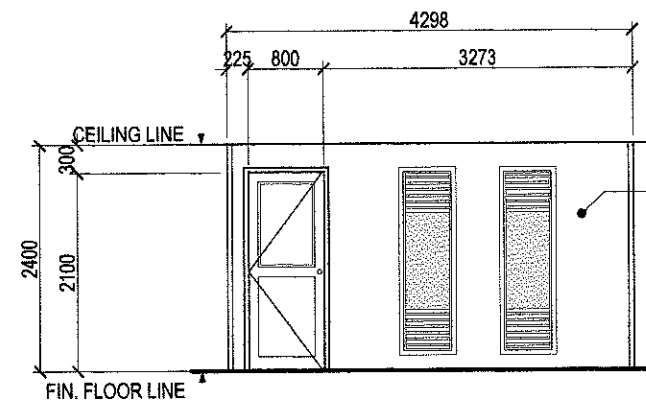


ELEVATION 'A'

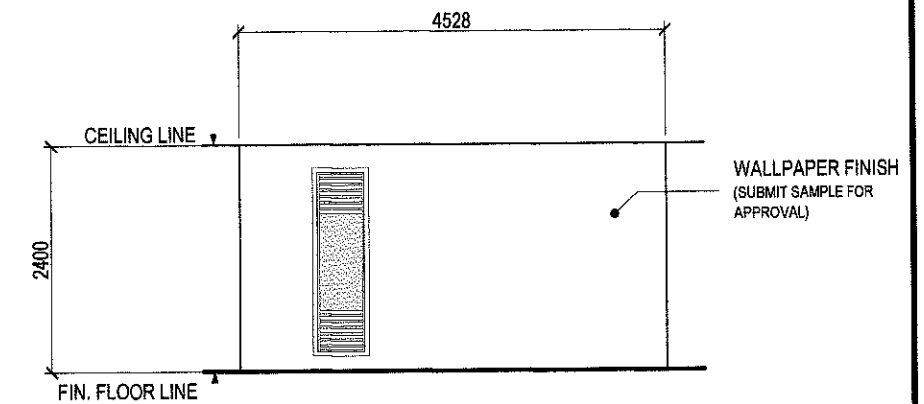

ELEVATION 'C'

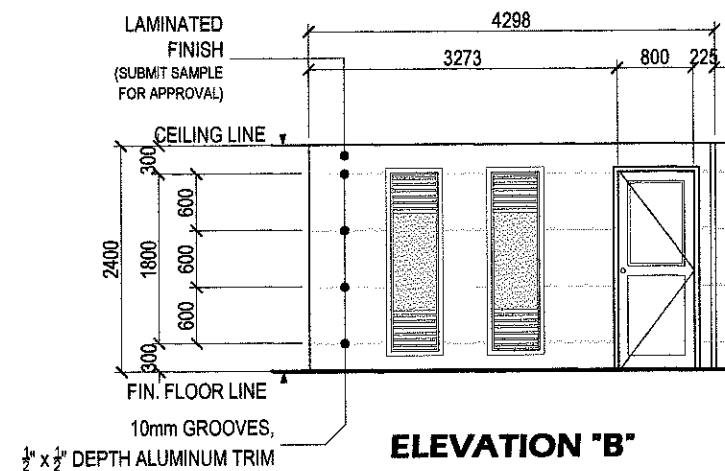

ELEVATION 'B'

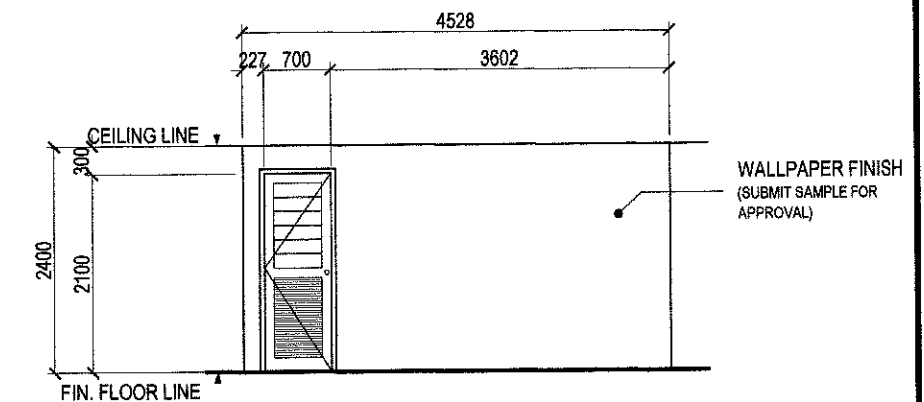

ELEVATION 'D'

2 ELEVATION / SECTION OF MEETING ROOM

SCALE 1:80 METERS



Republika ng Pilipinas
Lungsod ng Quezon
CITY ARCHITECT DEPARTMENT
9F CIVIC CENTER - D (BRO. Bldg), QUEZON CITY HALL COMPOUND,
ELLIPTICAL ROAD, DUMAM, QUEZON CITY



PROVISIO:

DRAWINGS AND SPECIFICATIONS DULY
SIGNED, STAMPED OR SEALED AS
INSTRUMENTS OF SERVICE ARE THE
SOLE PROPERTY OF THE ARCHITECT.
WHETHER THE OBJECT FOR WHICH THEY
ARE MADE IS EXCLUDED OR NOT, IT SHALL
BE ILLEGAL FOR ANY PERSON, WITHOUT
THE CONSENT OF THE ARCHITECT, TO MAKE
COPIES OF SAID DOCUMENTS FOR USE IN
THE EXECUTION OF ANY OTHER PROJECT
OR BUILDING, WHETHER
EXECUTED PARTLY OR IN WHOLE.

RECOMMENDING APPROVAL

ARCH. **ARVILLE H. CHUA**, *tuap, plep*
CITY ARCHITECT

APPROVED BY:

HON. MA. JOSEFINA G. BELMONTE
MAYOR

PROJECT TITLE:

**SUPPLY AND INSTALLATION OF MODULAR PARTITIONS
INCLUDING FURNITURE, AND OTHER WORKS FOR THE
CITY GENERAL SERVICES DEPARTMENT @ 9TH FLOOR,
Q.C. HALL MAIN BUILDING**

LOCATION: QUEZON CITY HALL COMPOUND ELLIPTICAL ROAD
BARANGAY CENTRAL, QUEZON CITY

SHEET CONTENTS:


TYPICAL DETAIL OF BACK WALL
ELEVATION / SECTION OF MEETING
ROOM

PROJECT NO.:


DATE: December 2021
DRAWN BY: K.C.M.
DESIGNED BY: Ar. J.U. Cesa / Ar. R.J. Beltran
CHECKED BY: Ar. R.G. Resurreccion

SHEET NO.:


AR-08

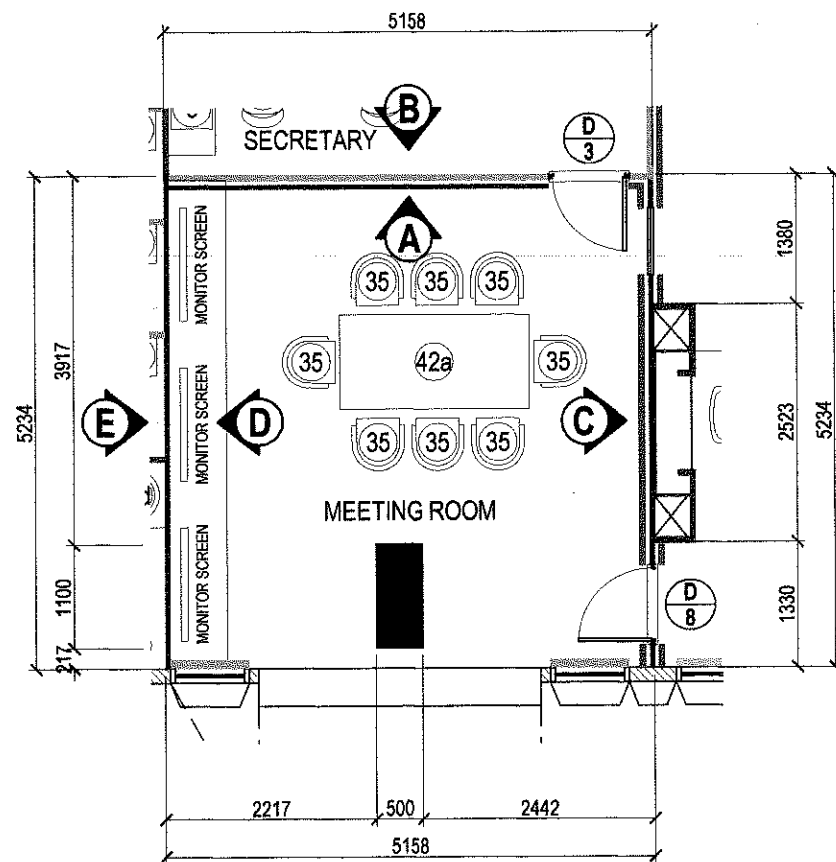


BLOW - UP PLAN

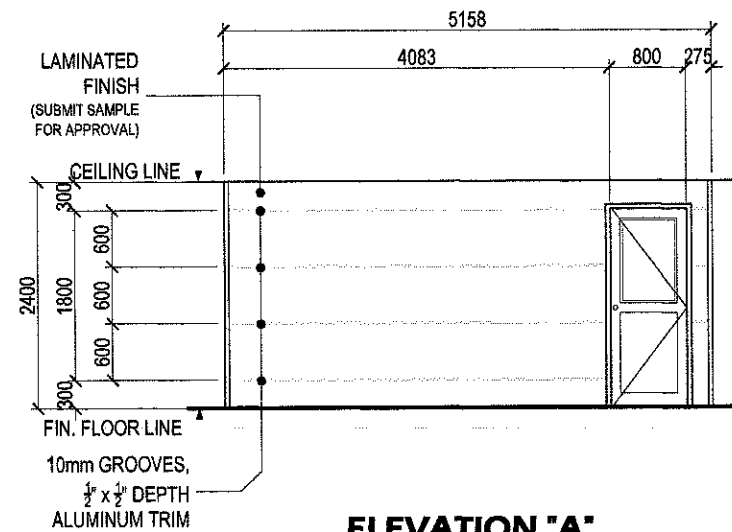


ELEVATION "A"

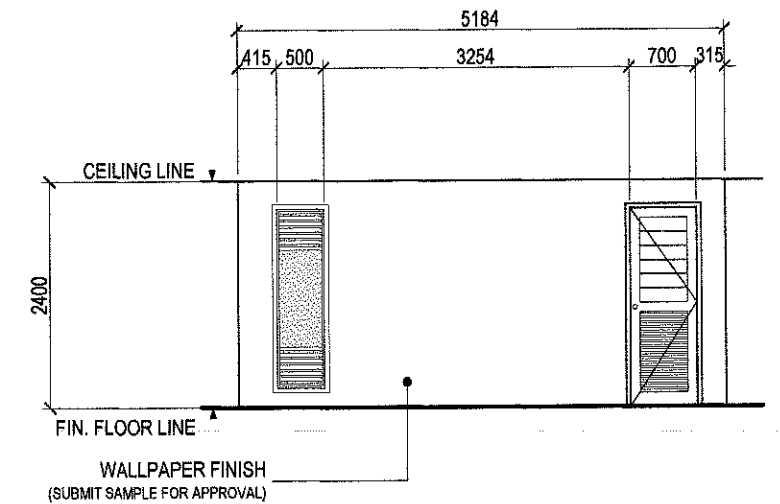

ELEVATION "C"

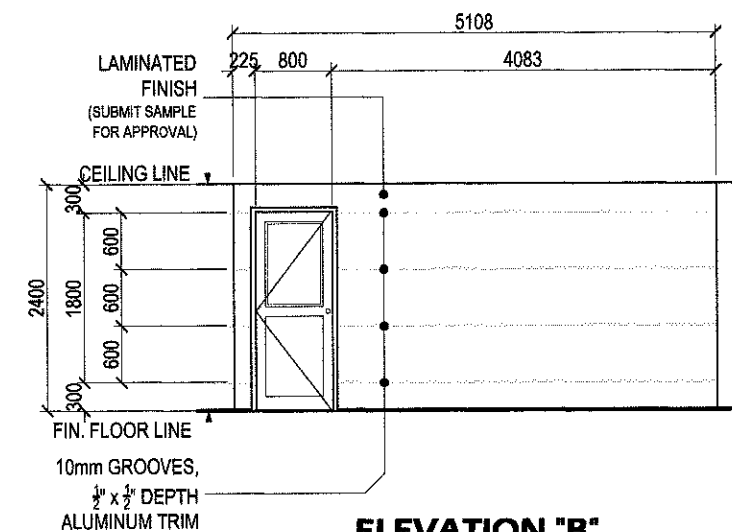

ELEVATION "B"

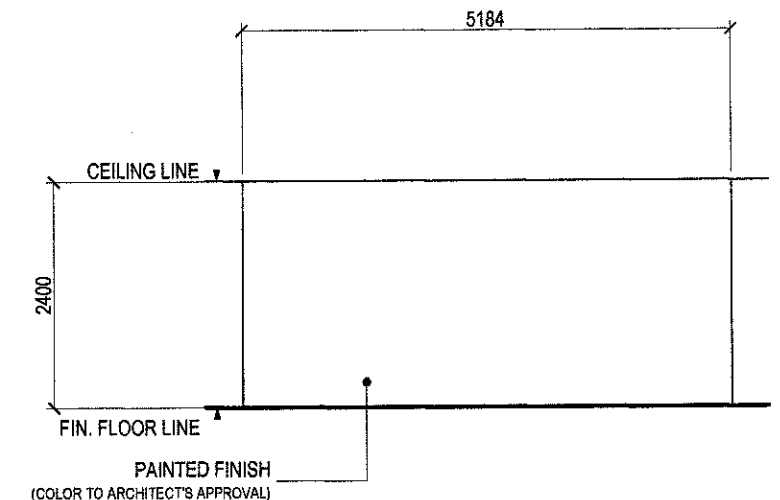

ELEVATION "D" / "E"

1 ELEVATION / SECTION OF MEETING ROOM

SCALE 1:80 METERS



Republika ng Pilipinas
Lungsod ng Quezon
CITY ARCHITECT DEPARTMENT
5F CIVIC CENTER - D (Bldg. 866), QUEZON CITY HALL COMPOUND,
ELLIPTICAL ROAD, DILIMAN, QUEZON CITY



PROVISO:
DRAWINGS AND SPECIFICATIONS FULLY
SHOWN, STAMPED OR SEALED AS
INSTRUMENTS OF SERVICE ARE THE
INTELLECTUAL PROPERTIES AND DOCUMENTS
OF THE CITY ARCHITECT'S DEPARTMENT.
WHETHER THE OBJECT FOR WHICH THEY
ARE MADE IS EXISTING OR NOT, IT SHALL
BE THE DUTY OF THE ARCHITECT, WITHOUT
THE CONSENT OF THE ARCHITECT, TO MAKE
COPIES OF SAID DOCUMENTS FOR USE IN
THE REPRODUCTION OF AND FOR OTHER
PROJECTS OR BUILDINGS, WHETHER
EXECUTED PARTLY OR IN WHOLE.

RECOMMENDING APPROVAL

[Signature]
ARCH. JUCILLE H. CHUA, fuap, plep
CITY ARCHITECT

APPROVED BY:

[Signature]
HON. MA. JOSEFINA G. BELMONTE
MAYOR

PROJECT TITLE:

**SUPPLY AND INSTALLATION OF MODULAR PARTITIONS
INCLUDING FURNITURE, AND OTHER WORKS FOR THE
CITY GENERAL SERVICES DEPARTMENT @ 9TH FLOOR,
Q.C. HALL MAIN BUILDING**

LOCATION: QUEZON CITY HALL COMPOUND ELLIPTICAL ROAD
BARANGAY CENTRAL QUEZON CITY

SHEET CONTENTS:

ELEVATION / SECTION OF MEETING
ROOM

PROJECT NO.:


DATE: December 2021
DRAWN BY: K.C.M.
DESIGNED BY: Ar. J.U. Gosa / Ar. R.I. Beltran
CHECKED BY: Ar. R.G. Resurreccion

SHEET NO.:


AR-09




BLOW - UP PLAN

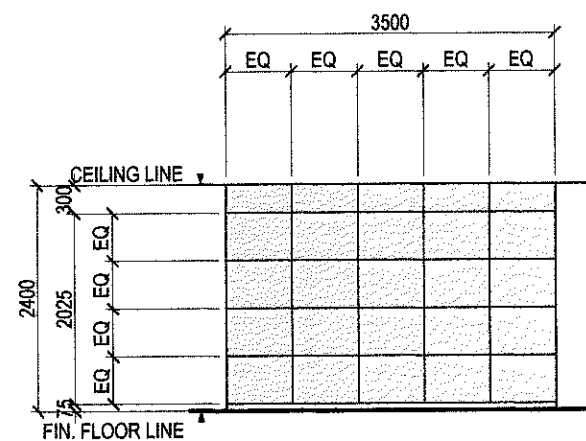


ELEVATION 'A'

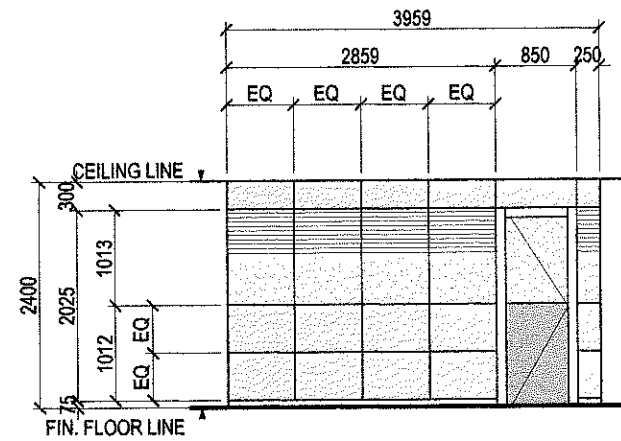


ELEVATION 'C'

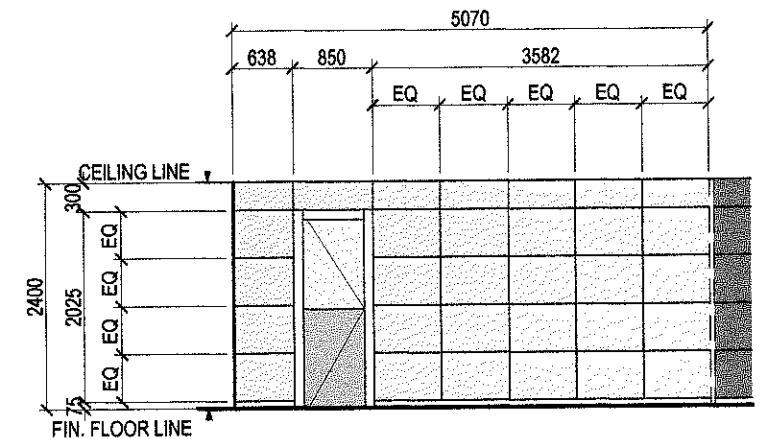


ELEVATION 'E'

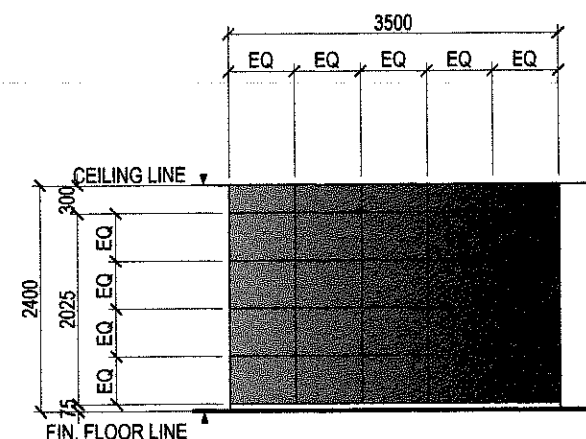


ELEVATION 'B'

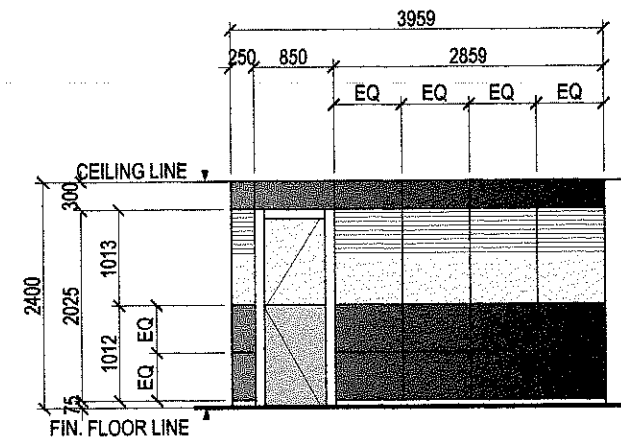


ELEVATION 'D'

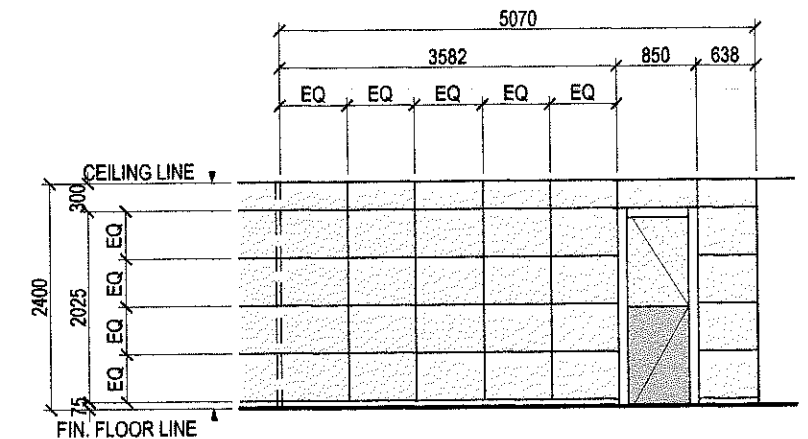

ELEVATION 'F'

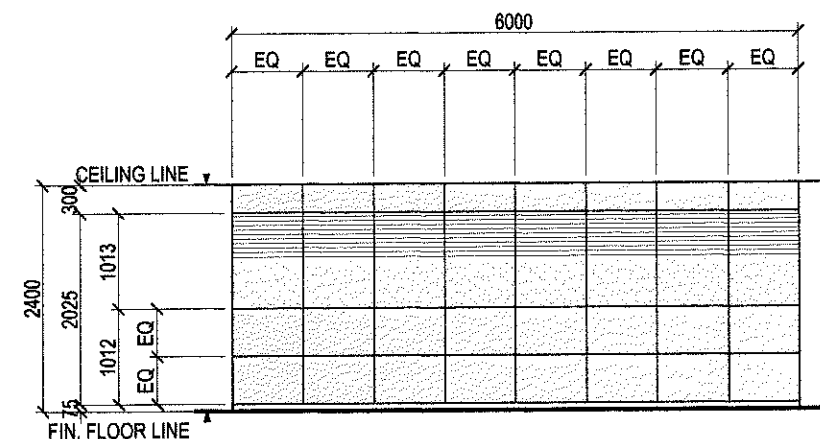

ELEVATION 'G'

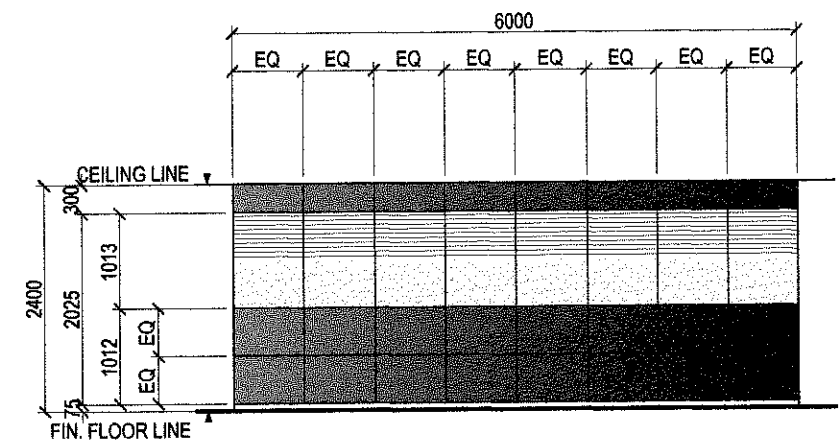

ELEVATION 'H'

1 ELEVATION / SECTION OF THE ASSISTANT DEPARTMENT HEAD'S OFFICE

SCALE 1:80 METERS



Republika ng Pilipinas
Lungsod ng Quezon
CITY ARCHITECT DEPARTMENT
5F CIVIC CENTER - D (Bldg. 846), QUEZON CITY HALL COMPOUND,
ELLIPTICAL ROAD, DILIMAN, QUEZON CITY



PROVISO:

DRAWINGS AND SPECIFICATIONS SHALL BE SIGNED, STAMPED OR SEALED AS INSTRUMENTS OF SERVICE AND THE INTELLECTUAL PROPERTY DOCUMENTS OF THE CITY ARCHITECT DEPARTMENT. WHETHER THE OBJECT FOR WHICH THEY ARE MADE IS EXISTING OR NOT, IT SHALL BE UNLAWFUL FOR ANY PERSON, WITHOUT THE CONSENT OF THE AUTHOR OF SAID DOCUMENTS TO REPRODUCE OR TO MAKE COPIES OF SAID DOCUMENTS FOR USE IN THE REPAIRING OF AND FOR OTHER PROJECTS OR BUILDINGS, WHETHER REQUESTED, PARTLY OR IN WHOLE.

RECOMMENDING APPROVAL

ARCH. LUCILLE H. CHUA, fupap, plep
CITY ARCHITECT

APPROVED BY:

HON. MA. JOSEFINA G. BELMONTE
MAYOR

PROJECT TITLE:

SUPPLY AND INSTALLATION OF MODULAR PARTITIONS INCLUDING FURNITURE, AND OTHER WORKS FOR THE CITY GENERAL SERVICES DEPARTMENT @ 9TH FLOOR, Q.C. HALL MAIN BUILDING

LOCATION: QUEZON CITY HALL COMPOUND ELLIPTICAL ROAD BARANGAY CENTRAL QUEZON CITY

SHEET CONTENTS:





ELEVATION / SECTION OF THE ASSISTANT DEPARTMENT HEAD'S OFFICE

PROJECT NO.:

DATE: December 2021
DRAWN BY: K.C.M.
DESIGNED BY: Ar. J.J. Costa / Ar. R.I. Beltran
CHECKED BY: Ar. R.G. Resurreccion

SHEET NO.:

AR-10

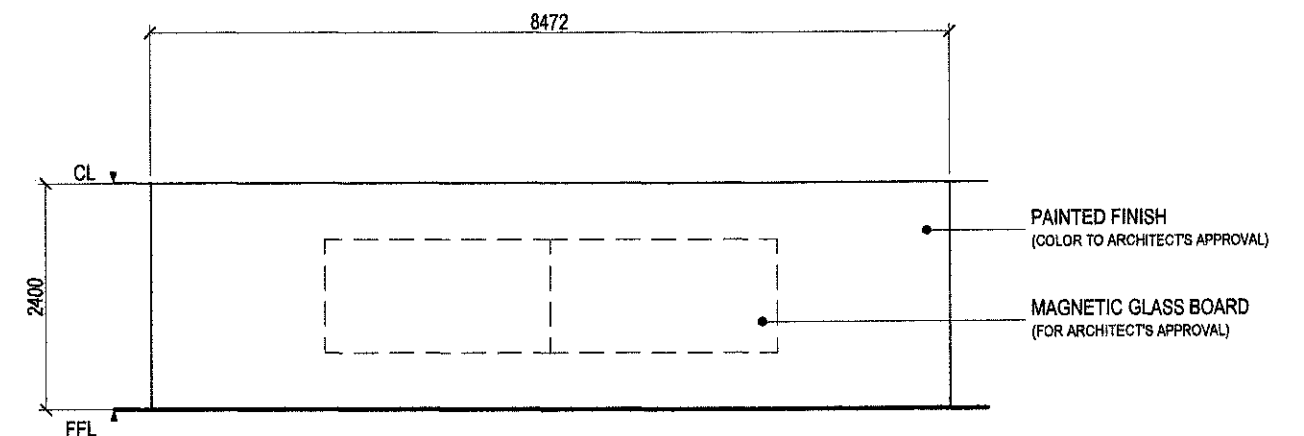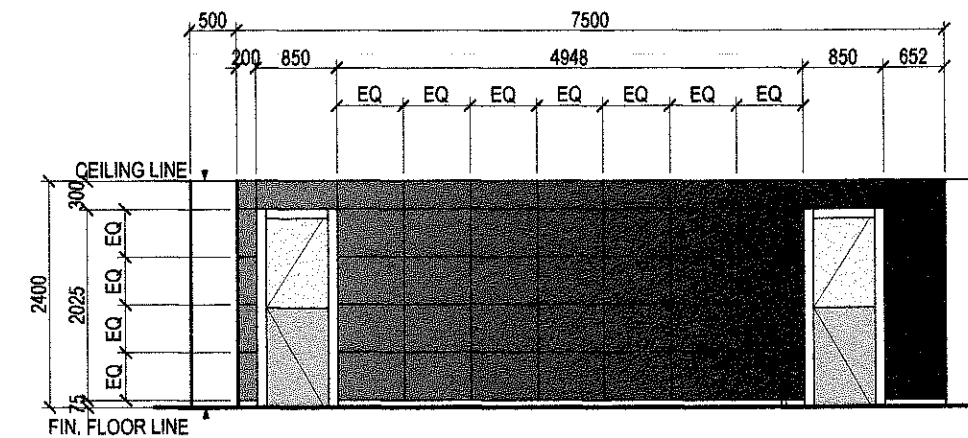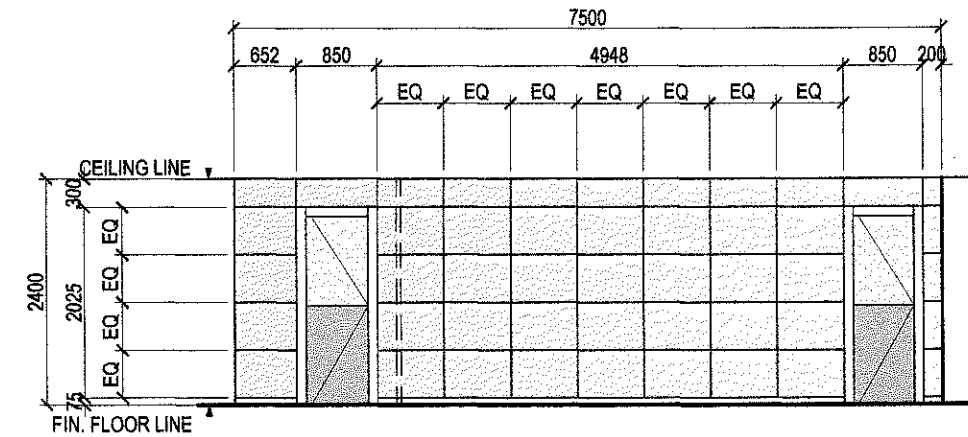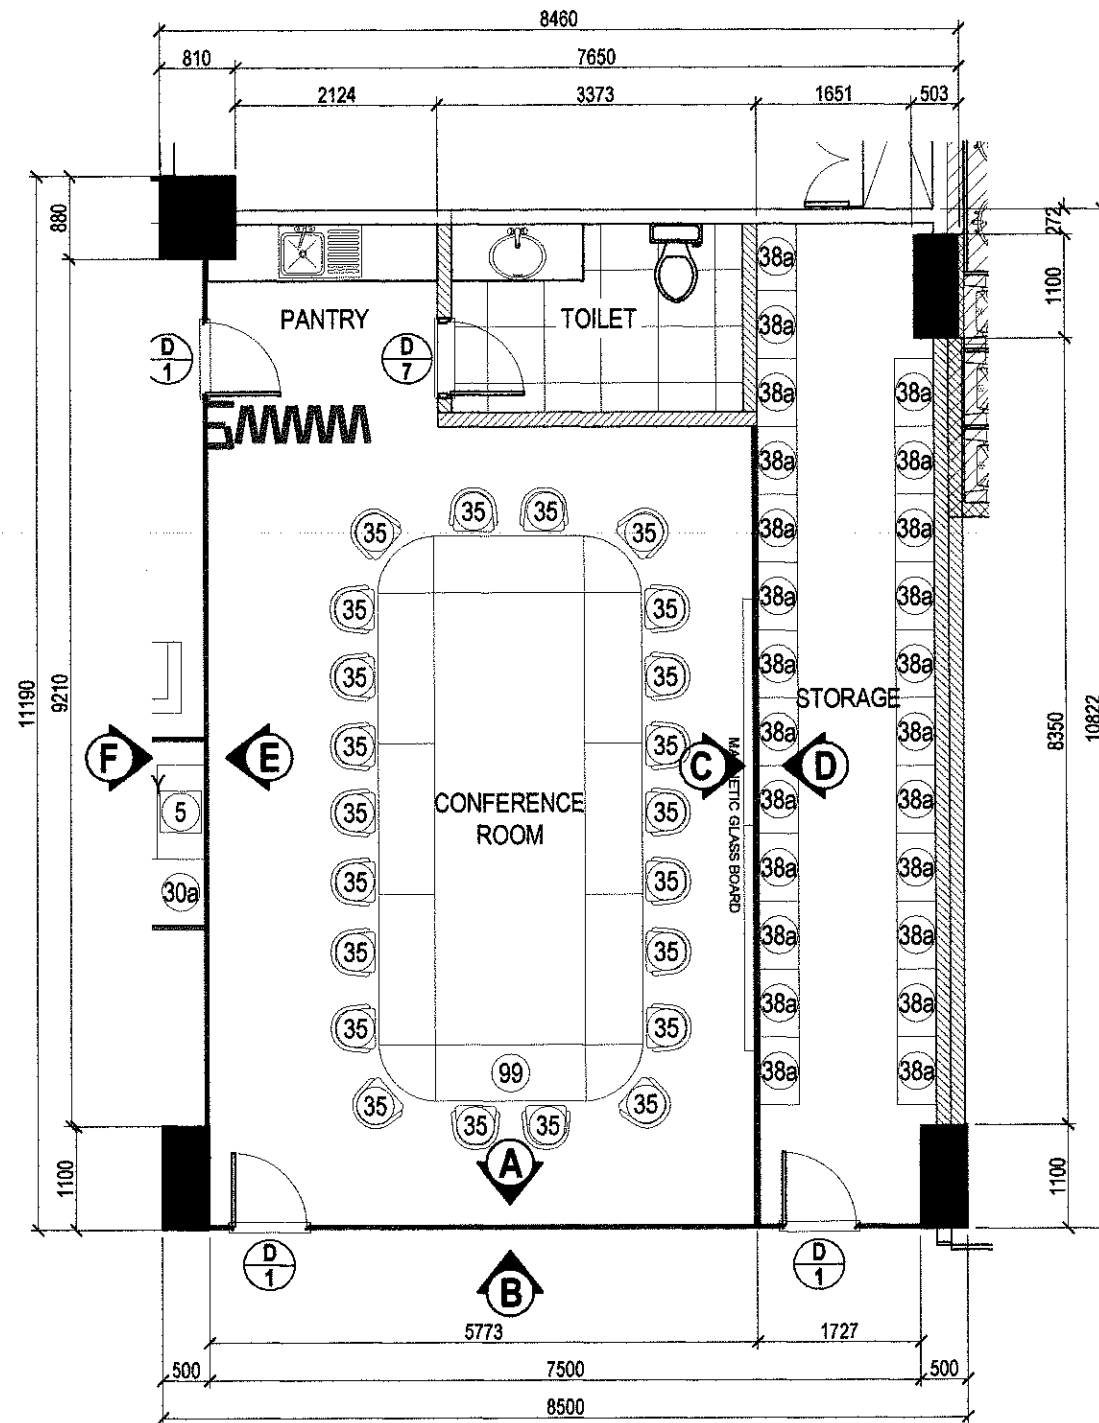

BLOW - UP PLAN

ELEVATION 'A'


ELEVATION 'B'

ELEVATION 'C' / 'D'


1 ELEVATION / SECTION OF CONFERENCE ROOM

SCALE 1:80 METERS

Republika ng Pilipinas Lungsod ng Quezon CITY ARCHITECT DEPARTMENT SF CIVIC CENTER - D (BRO. BANG), QUEZON CITY HALL COMPOUND, ELLIPTICAL ROAD, DUMALAN, QUEZON CITY	PROVIDO: DRAWING AND SPECIFICATIONS MUST BE SIGNED, STAMPED OR SEALED BY THE ARCHITECT OR ARCHITECTS IN CHARGE OF THE PROJECT. THE ARCHITECT OR ARCHITECTS IN CHARGE OF THE PROJECT SHALL BE RESPONSIBLE FOR THE ACCURACY OF THE INFORMATION PROVIDED AND FOR THE COMPLETION OF THE PROJECT. THE ARCHITECT OR ARCHITECTS IN CHARGE OF THE PROJECT SHALL BE RESPONSIBLE FOR THE COMPLETION OF THE PROJECT. THE ARCHITECT OR ARCHITECTS IN CHARGE OF THE PROJECT SHALL BE RESPONSIBLE FOR THE COMPLETION OF THE PROJECT.	RECOMMENDING APPROVAL ARCH. LUCILLE H. CHUA, fup, plep CITY ARCHITECT	APPROVED BY: HON. MA. JOSEFINA G. BELMONTE MAYOR	PROJECT TITLE: SUPPLY AND INSTALLATION OF MODULAR PARTITIONS INCLUDING FURNITURE, AND OTHER WORKS FOR THE CITY GENERAL SERVICES DEPARTMENT @ 9TH FLOOR, Q.C. HALL MAIN BUILDING LOCATION: QUEZON CITY HALL COMPOUND ELLIPTICAL ROAD BARANGAY CENTRAL QUEZON CITY	SHEET CONTENTS: ELEVATION / SECTION OF CONFERENCE ROOM	PROJECT NO.: DATE: December 2021 DRAWN BY: K.C.M. Yaw DESIGNED BY: Ar. J.U. Gadea / Ar. R.I. Ballester CHECKED BY: Ar. R.G. Resurreccion	SHEET NO.: AR-11
--	--	---	--	---	--	--	---------------------------------------

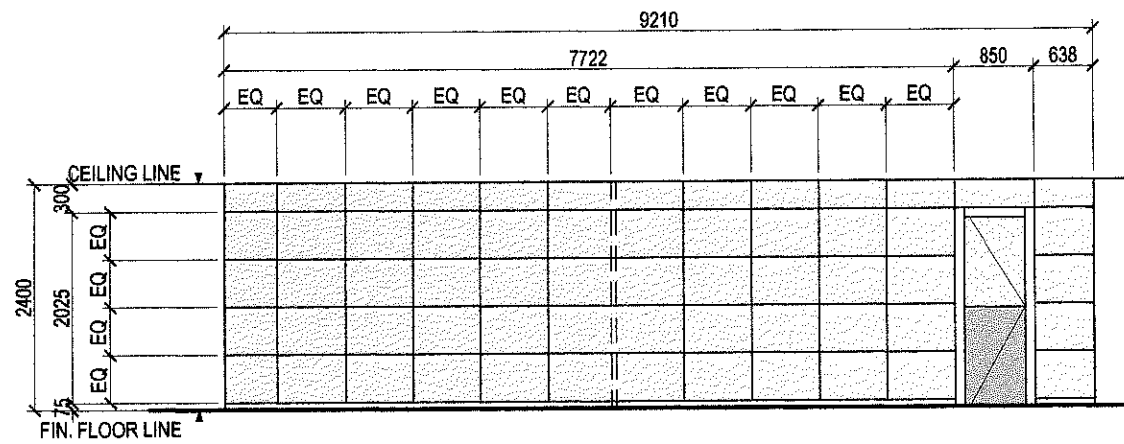


ELEVATION "E"

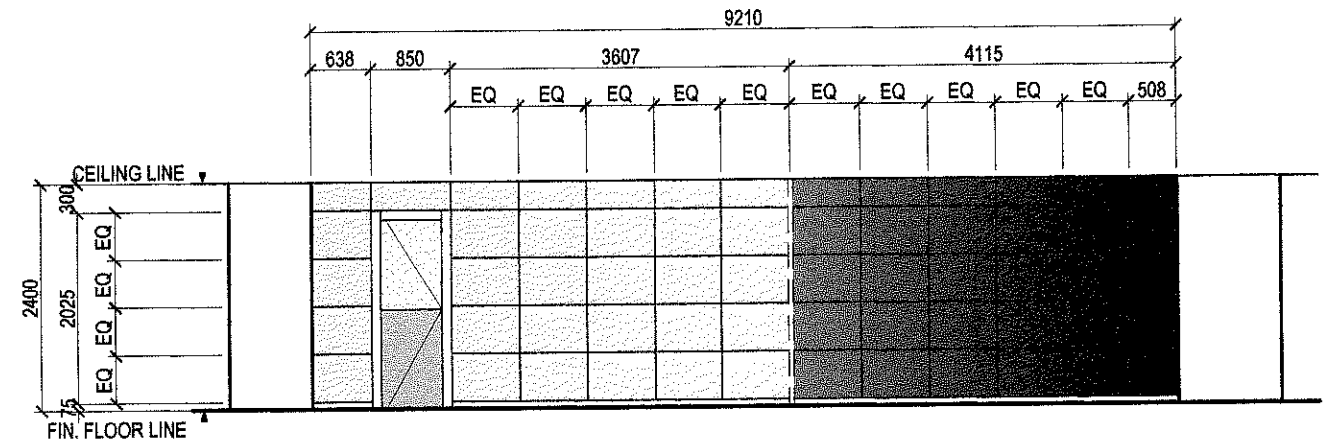


ELEVATION "F"

1 ELEVATION / SECTION OF CONFERENCE ROOM


SCALE 1:80 METERS

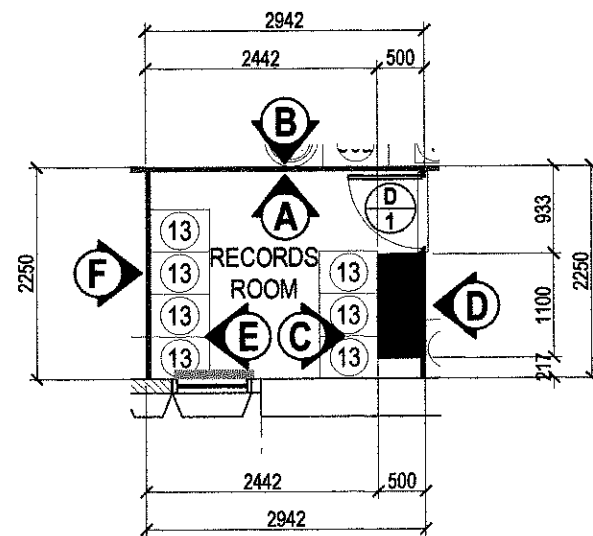


BLOW - UP PLAN

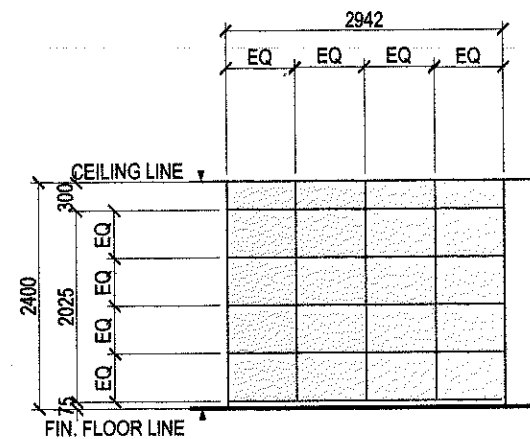


ELEVATION "A"

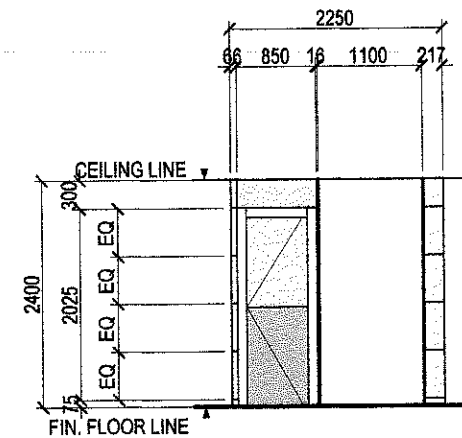


ELEVATION "C"

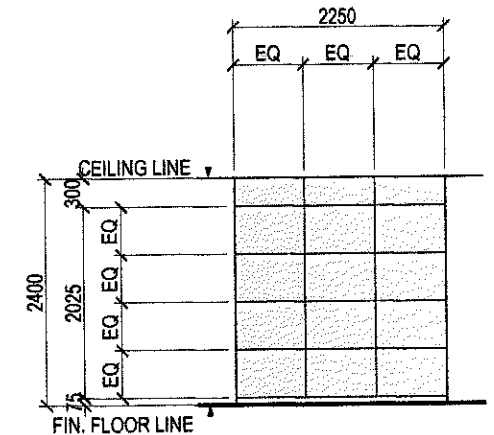


ELEVATION "E"

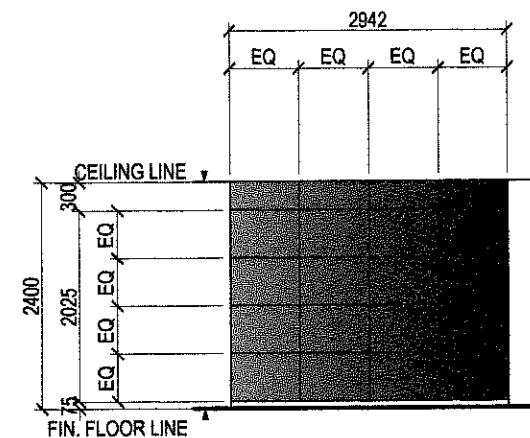

ELEVATION "B"

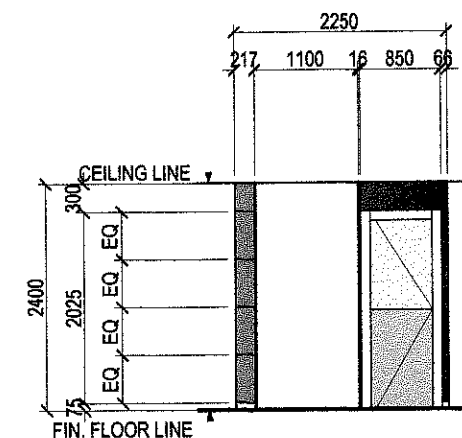

ELEVATION "D"

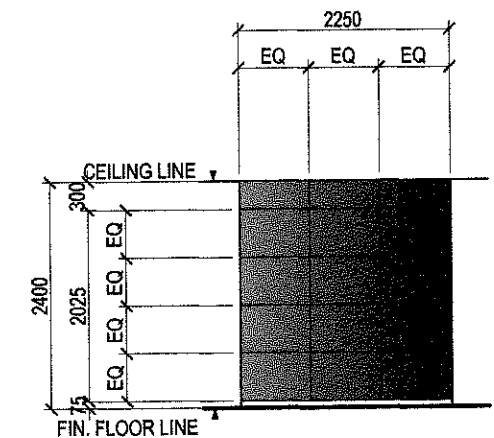

ELEVATION "F"

2 ELEVATION / SECTION OF RECORDS ROOM

SCALE 1:80 METERS



Republika ng Pilipinas
Lungsod ng Quezon
CITY ARCHITECT DEPARTMENT
9F CIVIC CENTER - D (BRO. Bldg), QUEZON CITY HALL COMPOUND,
ELLIPTICAL ROAD, DILIMAN, QUEZON CITY



PROVISOR:

DRAWINGS AND SPECIFICATIONS ONLY.
SIGNED, STAMPED OR SEALED AS
INSTRUMENTS OF SERVICE ARE THE
PROPERTY OF THE CITY ARCHITECT DEPARTMENT.
WHETHER THE OBJECT FOR WHICH THEY
ARE MADE IS EXISTING OR NOT, IF ANY
REWORKING, FOR ANY PERSON, WITHOUT
THE CONSENT OF THE ARCHITECT OF SAID
DOCUMENTS TO RE-DATE OR TO MAKE
COPIES OF SAID DOCUMENTS FOR USE IN
THE REVISION OF AND FOR OTHER
PROJECTS OR BUILDINGS, WHETHER
PREPARED BY HIM OR BY WHOM.

RECOMMENDING APPROVAL

ARCH. JUCILLE H. CHUA, fuap, plep
CITY ARCHITECT

APPROVED BY:

HON. MA. JOSEFINA G. BELMONTE
MAYOR

PROJECT TITLE:

SUPPLY AND INSTALLATION OF MODULAR PARTITIONS
INCLUDING FURNITURE, AND OTHER WORKS FOR THE
CITY GENERAL SERVICES DEPARTMENT @ 9TH FLOOR,
Q.C. HALL, MAIN BUILDING

LOCATION: QUEZON CITY HALL COMPOUND ELLIPTICAL ROAD
BARANGAY CENTRAL QUEZON CITY

SHEET CONTENTS:



ELEVATION / SECTION OF
CONFERENCE ROOM
ELEVATION / SECTION OF RECORDS
ROOM

PROJECT NO.:


DATE: December 2021
DRAWN BY: K.C.M.
DESIGNED BY: Ar. J.U. Ochoa / Ar. R.I. Beltran
CHECKED BY: Ar. R.C. Resurreccion

SHEET NO.:


AR-12

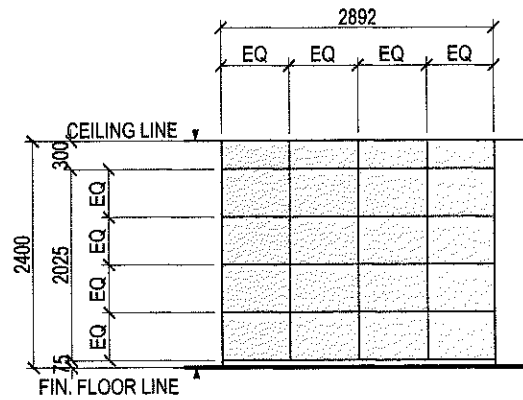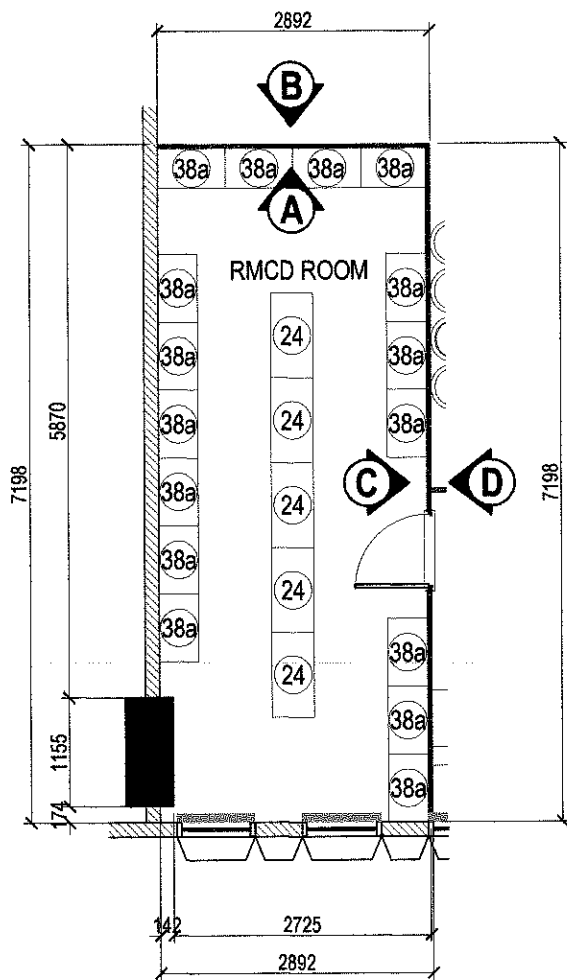


ELEVATION 'A'

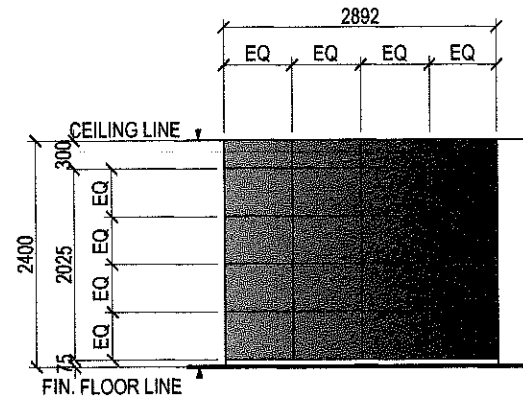

ELEVATION 'B'

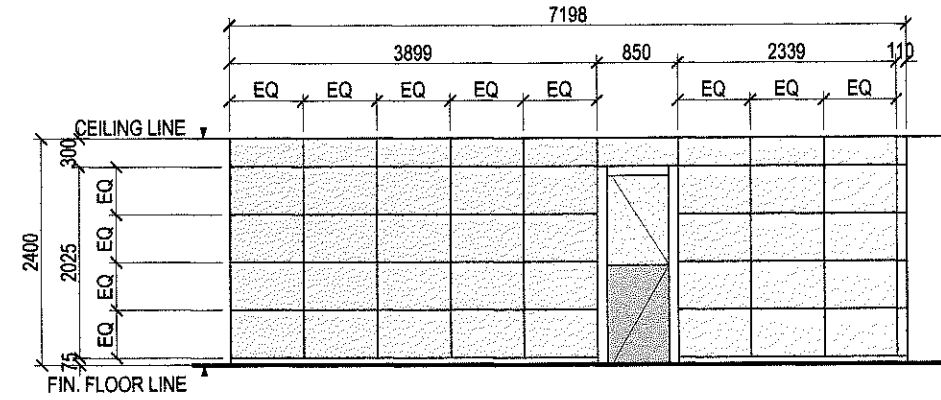



ELEVATION 'C'

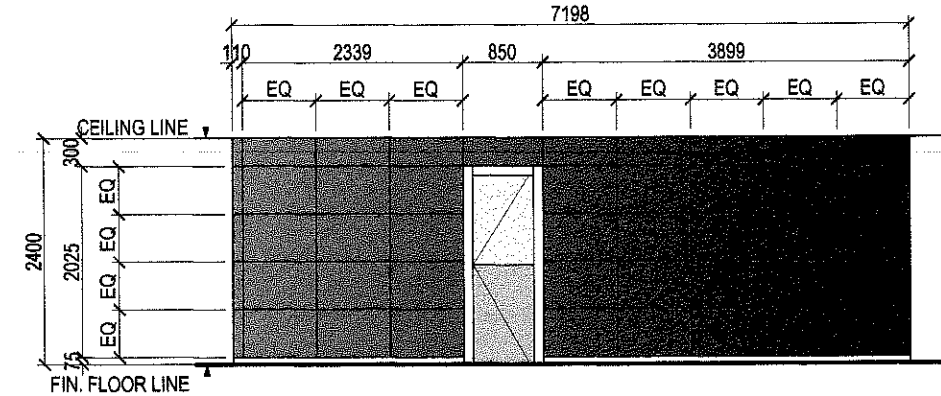


ELEVATION 'D'

1 ELEVATION / SECTION OF R.M.C.D STORAGE ROOM

SCALE 1:80 METERS

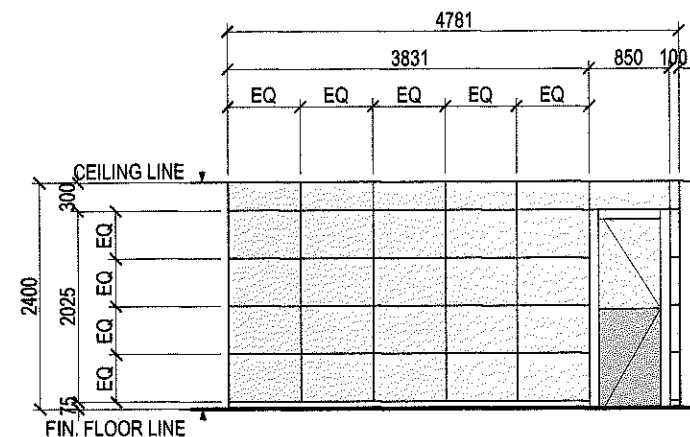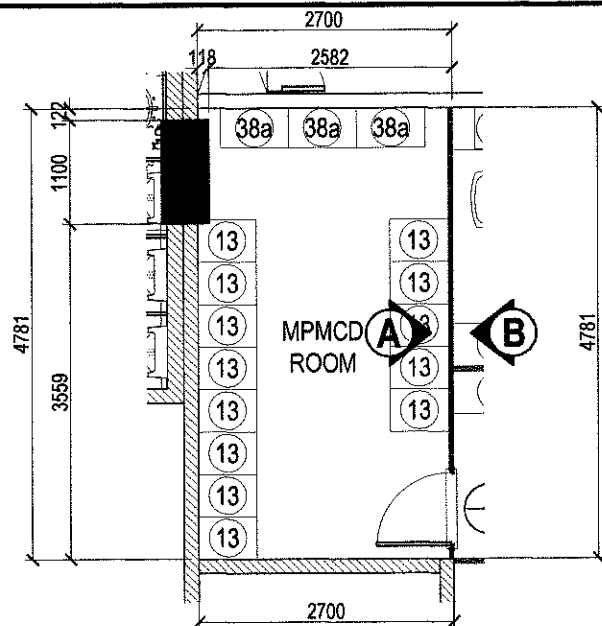

ELEVATION 'A'

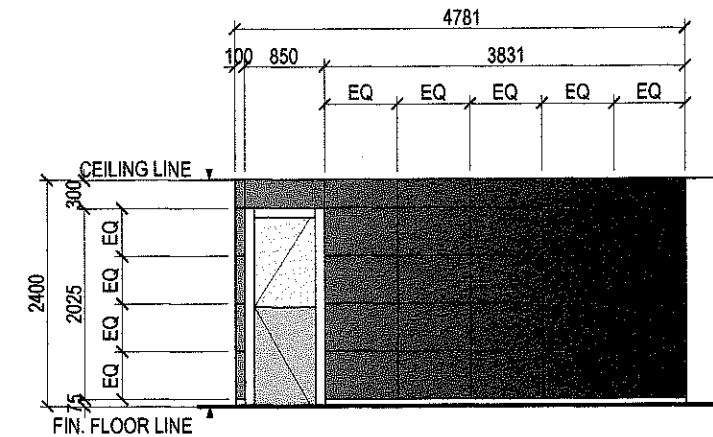


ELEVATION 'B'


2 ELEVATION / SECTION OF M.P.M.C.D STORAGE ROOM

SCALE 1:80 METERS


Republika ng Pilipinas Lungsod ng Quezon CITY ARCHITECT DEPARTMENT 8F CIVIC CENTER - D (8RD. Bldg.) QUEZON CITY HALL COMPOUND, ELLIPTICAL ROAD, DILIMAN, QUEZON CITY	PROVISO: DRAWINGS AND SPECIFICATIONS ONLY SHOWN, STAMPED OR SEALED AS INSTRUMENTS OF SERVICE AND THE INTELLECTUAL PROPERTIES & DOCUMENTS OF THE CITY ARCHITECTS DEPARTMENT. WHETHER THE PROJECT FOR WHICH THEY ARE MADE IS SECURED OR NOT, IT SHALL BE UNLAWFUL FOR ANY PERSON WITHOUT THE CONSENT OF THE AUTHOR OF SAID DOCUMENTS TO REPRODUCE OR TO MAKE COPIES OF SAID DOCUMENTS FOR USE IN THE REPRODUCTION OF AND FOR OTHER PROJECTS OR BUILDINGS, WHETHER PREPARED PARTLY OR IN WHOLE.	RECOMMENDING APPROVAL <i>[Signature]</i> ARCH. MA. JILIE H. CHUA, fuap, plep CITY ARCHITECT	APPROVED BY: <i>[Signature]</i> HON. MA. JOSEFINA G. BELMONTE MAYOR	PROJECT TITLE: SUPPLY AND INSTALLATION OF MODULAR PARTITIONS INCLUDING FURNITURE, AND OTHER WORKS FOR THE CITY GENERAL SERVICES DEPARTMENT @ 9TH FLOOR, Q.C. HALL MAIN BUILDING LOCATION: QUEZON CITY HALL COMPOUND ELLIPTICAL ROAD BARANGAY CENTRAL, QUEZON CITY	SHEET CONTENTS: ELEVATION / SECTION OF R.M.C.D STORAGE ROOM ELEVATION / SECTION OF M.P.M.C.D STORAGE ROOM	PROJECT NO.: DATE: December 2021 DRAWN BY: K.C.M. DESIGNED BY: Ar. J.U. / Ar. R.I. Beltran CHECKED BY: Ar. R.G. Resurreccion	SHEET NO.: AR-13
--	---	--	--	---	---	--	---------------------------------------

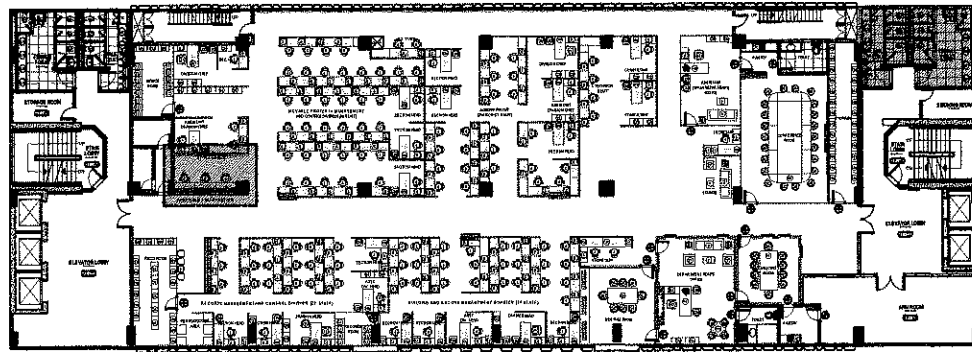


KEY PLAN

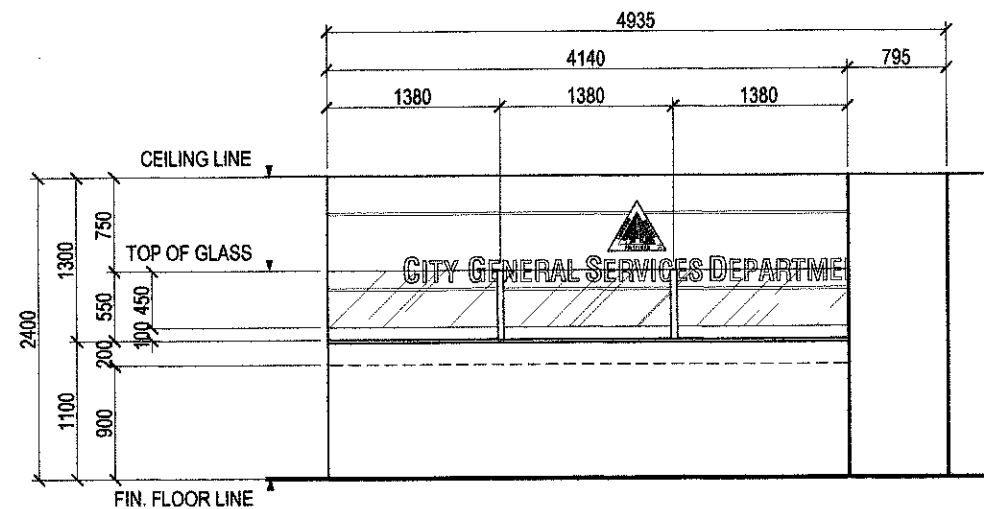


ELEVATION 'B'

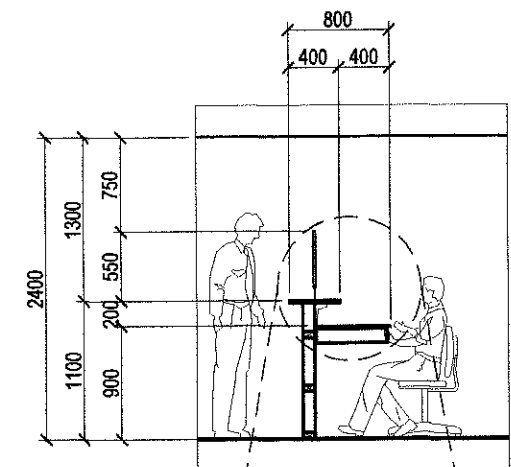



SECTION THRU 'D'

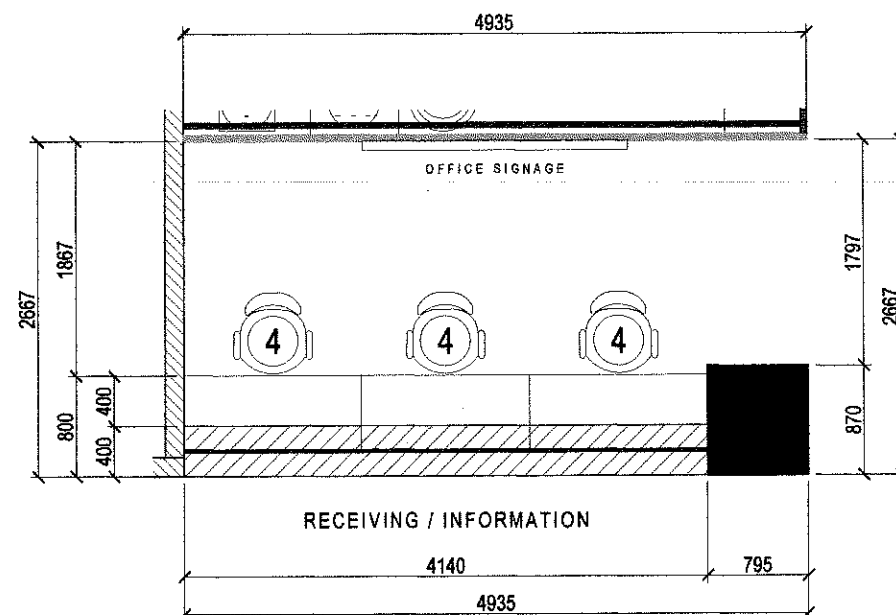


BLOW - UP PLAN

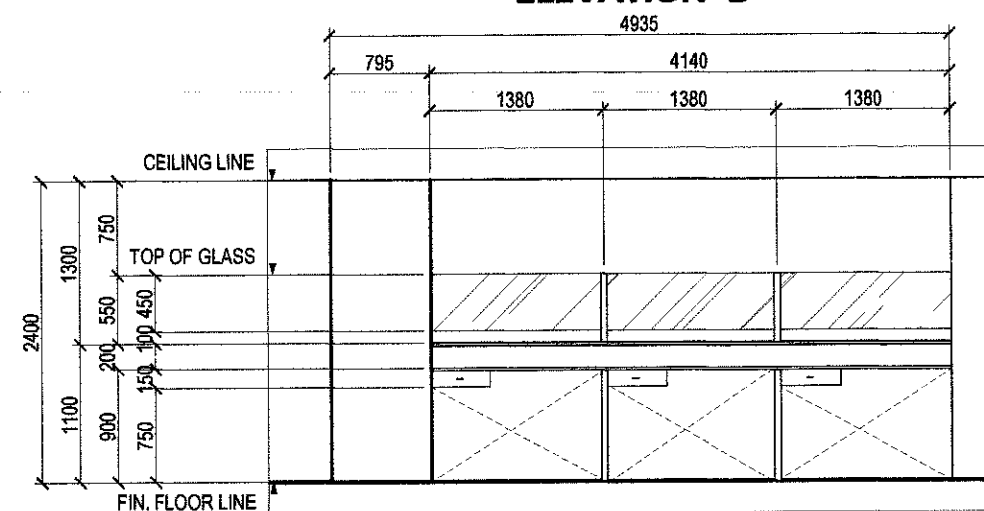

ELEVATION 'C'

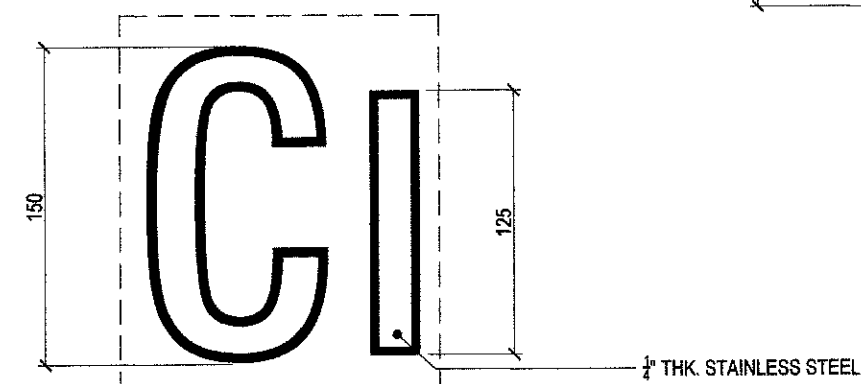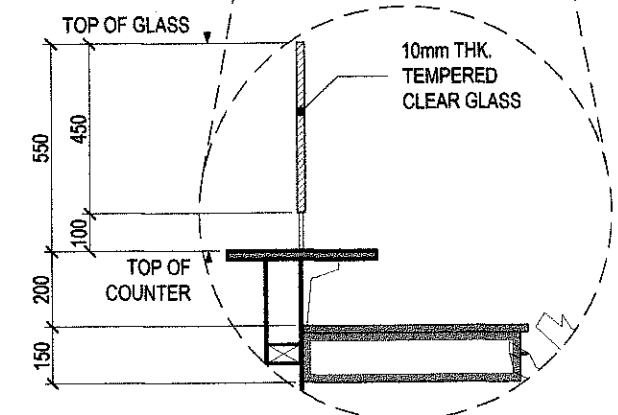

OFFICE SIGNAGE DETAIL

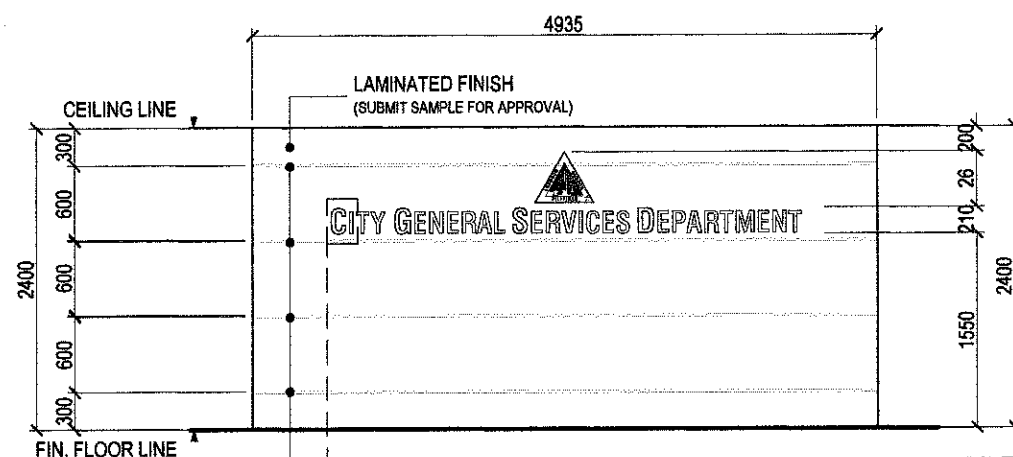

ELEVATION 'A'

1 | DETAIL OF RECEIVING, AND INFORMATION COUNTER @ 9TH FLOOR

SCALE 1:60 METERS



Republika ng Pilipinas
Lungsod ng Quezon
CITY ARCHITECT DEPARTMENT
9F CIVIC CENTER - D (Bldg. 840), QUEZON CITY HALL COMPOUND,
ELLIPTICAL ROAD, DUMAGAN, QUEZON CITY



PROVIDO:

Drawings and specifications duly signed, stamped or sealed as instruments of service and the intellectual property and documents of the City Architect Department. Whether the object for which they are made is executed or not, it shall be unlawful for any person without the consent of the author or said documents to duplicate or to make copies of said documents for use in the repetition of and for other projects or buildings, whether executed partly or in whole.

RECOMMENDING APPROVAL

[Signature]
ARCH. NICOLE H. CHUA, fuap, plep
CITY ARCHITECT

APPROVED BY:

[Signature]
HON. MA. JOSEFINA G. BELMONTE
MAYOR

PROJECT TITLE:

SUPPLY AND INSTALLATION OF MODULAR PARTITIONS INCLUDING FURNITURE, AND OTHER WORKS FOR THE CITY GENERAL SERVICES DEPARTMENT @ 9TH FLOOR, Q.C. HALL MAIN BUILDING

LOCATION: QUEZON CITY HALL COMPOUND ELLIPTICAL ROAD
BARANGAY CENTRAL QUEZON CITY

SHEET CONTENTS:


DETAIL OF RECEIVING, AND INFORMATION COUNTER

PROJECT NO.:


DATE: December 2021
DRAWN BY: K.C.M.
DESIGNED BY: Ar. J.U. C... Ar. R.I. Beltran
CHECKED BY: Ar. R.G. Resurreccion

SHEET NO.:

AR-14

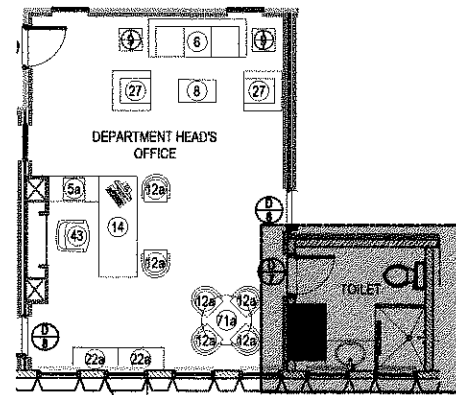

KEY PLAN

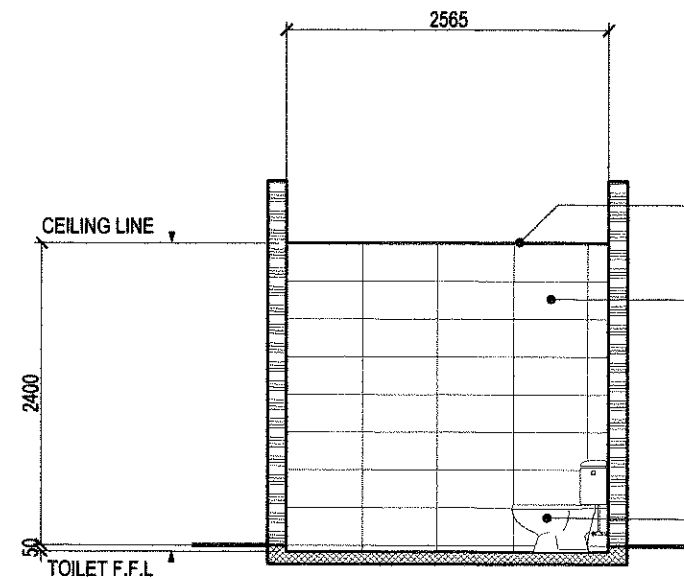


SECTION THRU 'A'

12mm THK. MOISTURE RESISTANT GYPSUM BOARD ON LIGHT WEIGHT ALUMINUM FRAMES


300mm X 600mm HOMOGENOUS / PORCELAIN WALL TILES (SUBMIT SAMPLE FOR APPROVAL)

CLEAR TEMPERED GLASS SHOWER PARTITION


REPLACEMENT OF WATER CLOSET: ONE PIECE TANK TYPE STAINLESS STEEL WATER CLOSET W/ BIDET (SUBMIT SAMPLE FOR APPROVAL)

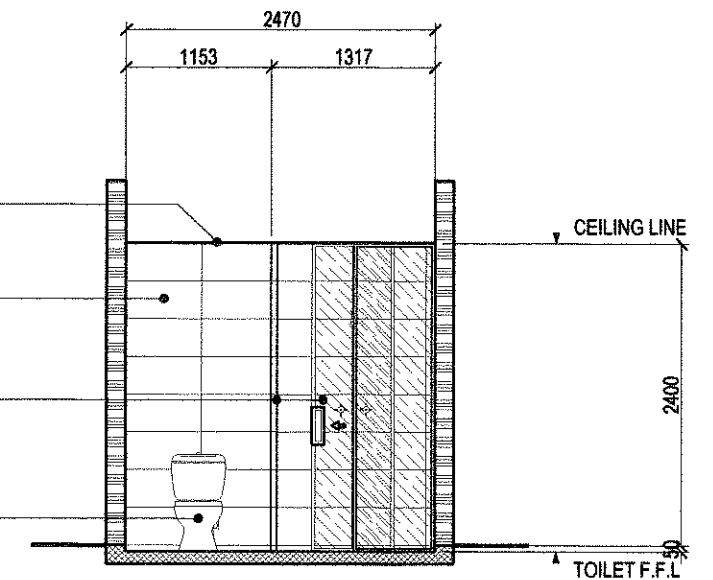

SECTION THRU 'C'

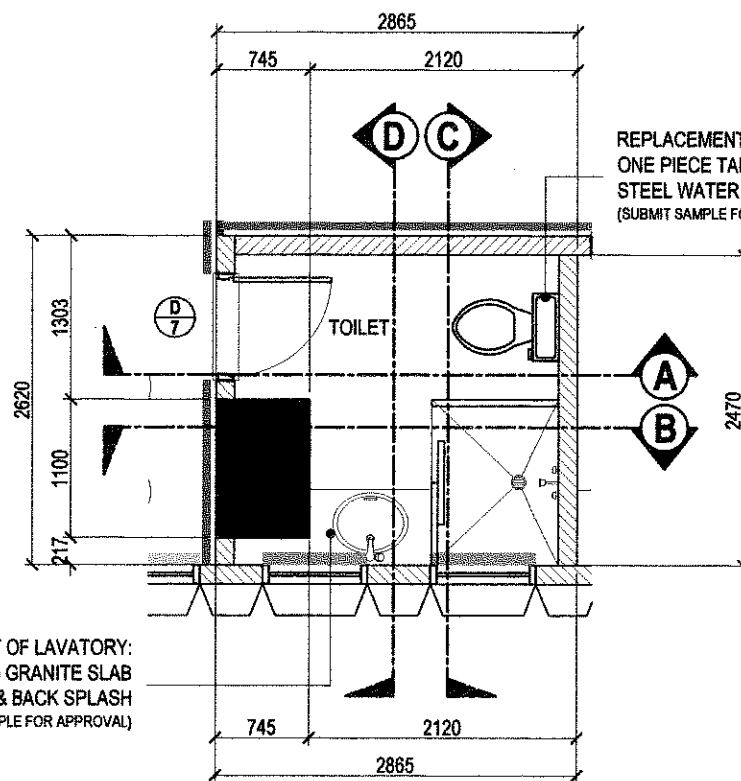

BLOW - UP PLAN

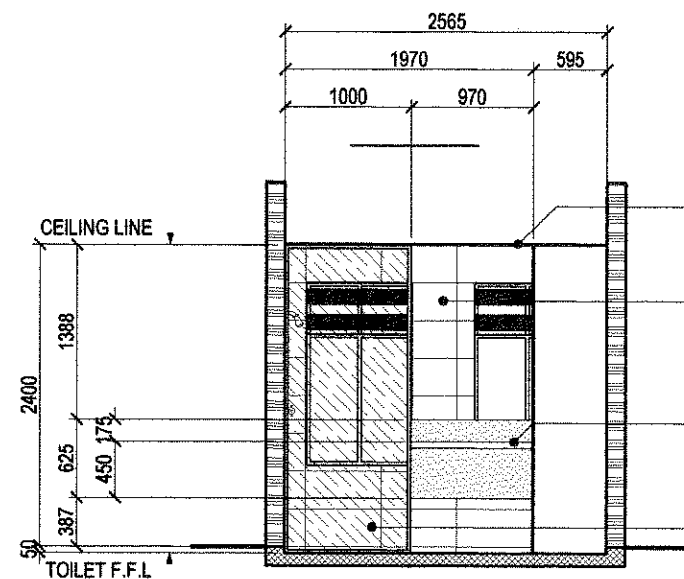


SECTION THRU 'B'

12mm THK. MOISTURE RESISTANT GYPSUM BOARD ON LIGHT WEIGHT ALUMINUM FRAMES

300mm X 600mm HOMOGENOUS / PORCELAIN WALL TILES (SUBMIT SAMPLE FOR APPROVAL)

REPLACEMENT OF LAVATORY: 20mm THK. (CDS) GRANITE SLAB COUNTER TOP & BACK SPLASH (SUBMIT SAMPLE FOR APPROVAL)

CLEAR TEMPERED GLASS SHOWER PARTITION

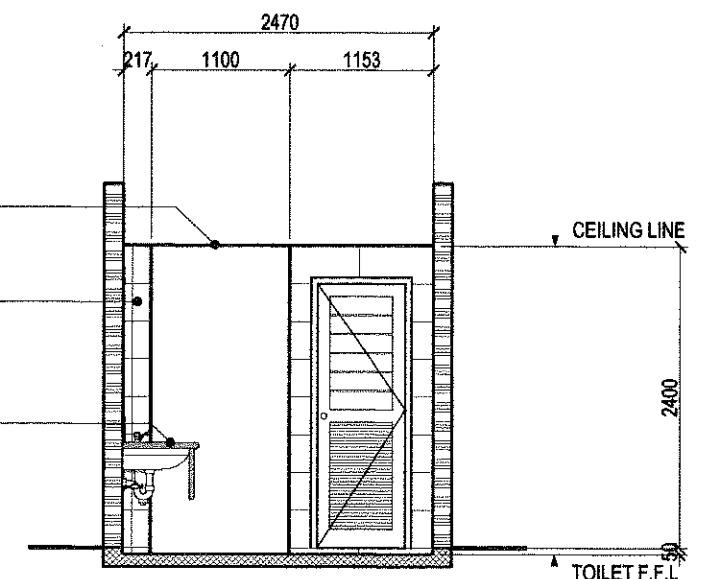

SECTION THRU 'D'

1 DETAIL OF TOILET @ THE DEPARTMENT HEAD'S OFFICE - 9TH FLOOR

SCALE 1:80 METERS



Republika ng Pilipinas
Lungsod ng Quezon
CITY ARCHITECT DEPARTMENT
5F CHAC CENTER - D (Bldg. 04), QUEZON CITY HALL COMPOUND,
ELLIPTICAL ROAD, DILIMAN, QUEZON CITY



PROVISO:

DRAWINGS AND SPECIFICATIONS ONLY
SIGNED, STAMPED OR SEALED AS
INSTRUMENTS OF SERVICE ARE THE
INTELLECTUAL PROPERTIES & DOCUMENTS
OF THE CITY ARCHITECTS DEPARTMENT.
WHETHER THE OBJECT FOR WHICH THEY
ARE MADE IS EXECUTED OR NOT, IT SHALL
BE VALID FOR ANY PERSON WITHOUT
THE CONSENT OF THE AUTHOR OF SAID
DOCUMENTS TO DUPLICATE OR TO MAKE
COPIES OF SAID DOCUMENTS FOR USE IN
THE REPRODUCTION OF AND FOR OTHER
PROJECTS OR BUILDINGS, WHETHER
EXECUTED PARTLY OR IN WHOLE.

RECOMMENDING APPROVAL

[Signature]
ARCH. UCILLE H. CHUA, f.u.s.p., p.l.p.
CITY ARCHITECT

APPROVED BY:

[Signature]
HON. MA. JOSEFINA G. BELMONTE
MAYOR

PROJECT TITLE :

**SUPPLY AND INSTALLATION OF MODULAR PARTITIONS
INCLUDING FURNITURE, AND OTHER WORKS FOR THE
CITY GENERAL SERVICES DEPARTMENT @ 9TH FLOOR,
Q.C. HALL MAIN BUILDING**

LOCATION: QUEZON CITY HALL COMPOUND ELLIPTICAL ROAD
BARANGAY CENTRAL QUEZON CITY

SHEET CONTENTS :


DETAIL OF TOILET @ THE
DEPARTMENT HEAD'S OFFICE,
9TH FLOOR

PROJECT NO.:


DATE: December 2021
DRAWN BY: K.C.M. *[Signature]*
DESIGNED BY: Ar. JULIO Ar. R.I. Belmonte
CHECKED BY: Ar. R.G. Resurreccion

SHEET NO.:

AR-15

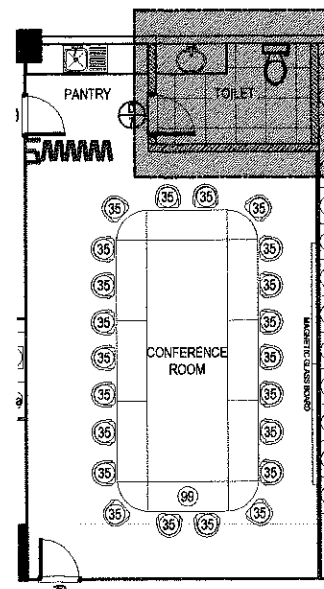


KEY PLAN

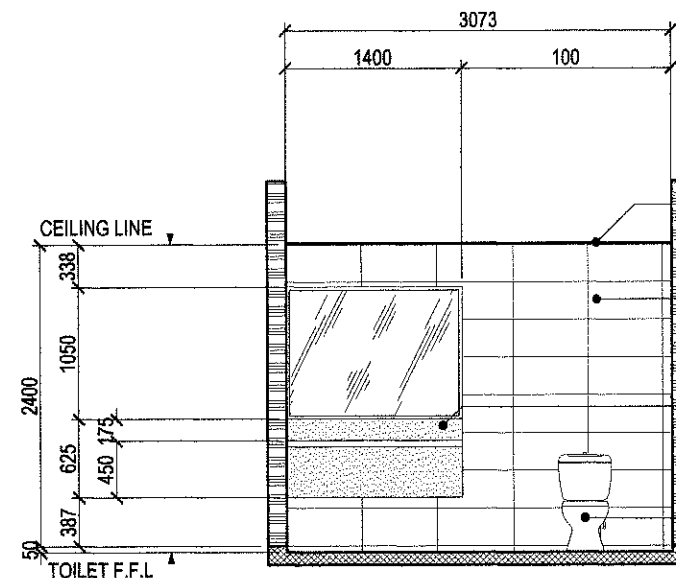


SECTION THRU 'A'


- 12mm THK. MOISTURE RESISTANT GYPSUM BOARD ON LIGHT WEIGHT ALUMINUM FRAMES
- 300mm X 600mm HOMOGENOUS / PORCELAIN WALL TILES (SUBMIT SAMPLE FOR APPROVAL)
- REPLACEMENT OF LAVATORY: 20mm THK. (CDS) GRANITE SLAB COUNTER TOP & BACK SPLASH (SUBMIT SAMPLE FOR APPROVAL)
- REPLACEMENT OF WATER CLOSET: ONE PIECE TANK TYPE STAINLESS STEEL WATER CLOSET W/ BIDET (SUBMIT SAMPLE FOR APPROVAL)

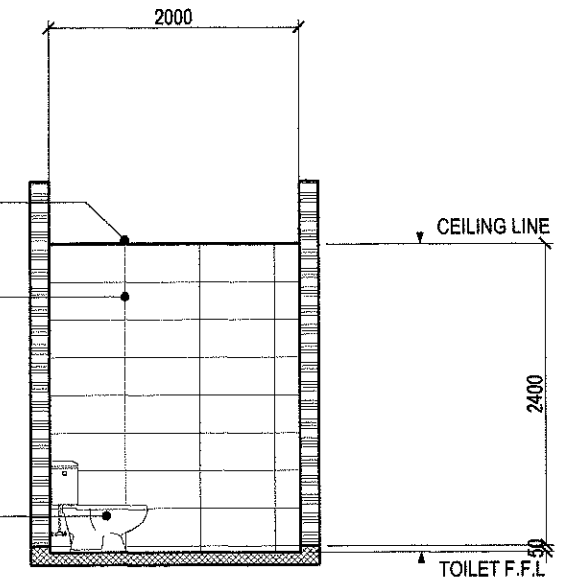

SECTION THRU 'C'

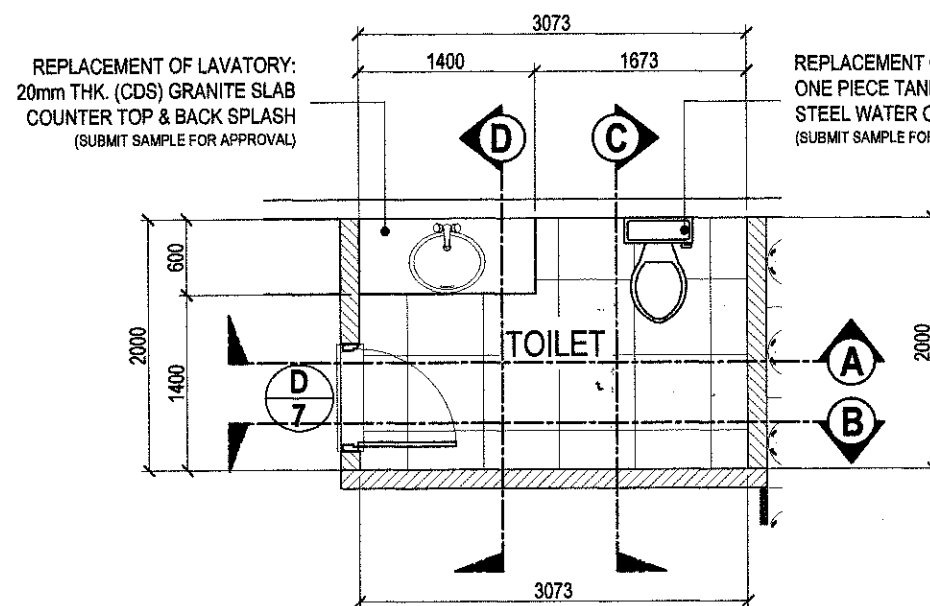


BLOW - UP PLAN

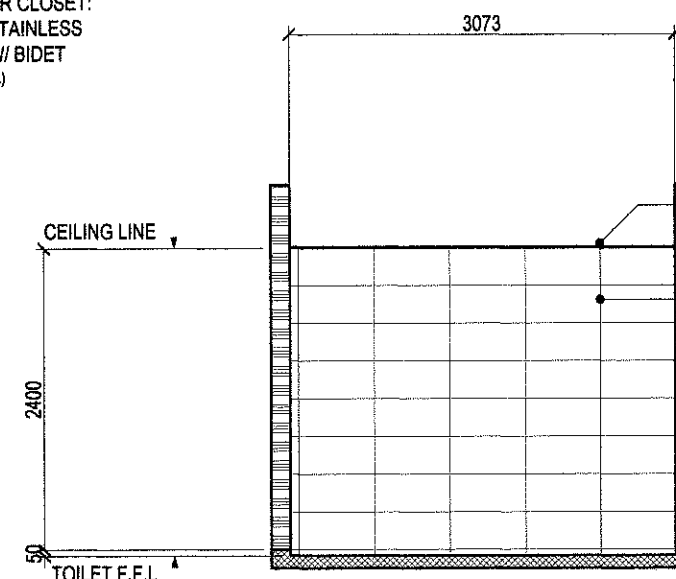

SECTION THRU 'B'

- 12mm THK. MOISTURE RESISTANT GYPSUM BOARD ON LIGHT WEIGHT ALUMINUM FRAMES
- 300mm X 600mm HOMOGENOUS / PORCELAIN WALL TILES (SUBMIT SAMPLE FOR APPROVAL)
- REPLACEMENT OF LAVATORY: 20mm THK. (CDS) GRANITE SLAB COUNTER TOP & BACK SPLASH (SUBMIT SAMPLE FOR APPROVAL)

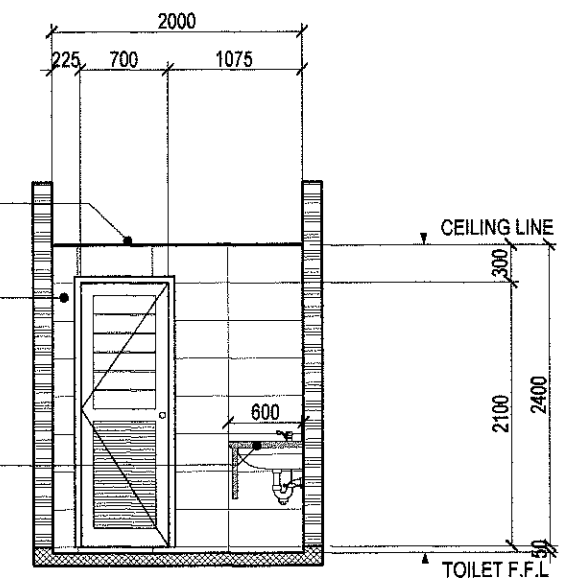


SECTION THRU 'D'


1 DETAIL OF TOILET @ CONFERENCE ROOM - 9TH FLOOR

SCALE 1:80 METERS


 Republika ng Pilipinas Lungsod ng Quezon CITY ARCHITECT DEPARTMENT 5F CIVIC CENTER - D (BRO. Bldg.), QUEZON CITY HALL COMPOUND, ELLIPTICAL ROAD, DILIMAN, QUEZON CITY	PROVISO: DRAWINGS AND SPECIFICATIONS ONLY SHOWN, STAMPED OR SEALED AS INSTRUMENTS OF SERVICE ARE THE PROPERTY OF THE CITY ARCHITECTS DEPARTMENT. WHETHER THE CLIENT FOR WHICH THEY ARE MADE IS CALLED UPON OR NOT, IT SHALL BE UNLAWFUL FOR ANY PERSON, WITHOUT THE CONSENT OF THE ARCHITECT OF SAID DEPARTMENT TO REPRODUCE OR TO MAKE COPIES OF SAID DOCUMENTS FOR USE IN THE REPERFECT OF AND FOR OTHER PROJECTS OR BUILDINGS, WHETHER EXECUTED EARLY OR IN WHOLE.	RECOMMENDING APPROVAL <i>[Signature]</i> ARCH. LUCILLE H. CHUA, tuap, plep CITY ARCHITECT	APPROVED BY: <i>[Signature]</i> HON. MA. JOSEFINA G. BELMONTE MAYOR	PROJECT TITLE: SUPPLY AND INSTALLATION OF MODULAR PARTITIONS INCLUDING FURNITURE, AND OTHER WORKS FOR THE CITY GENERAL SERVICES DEPARTMENT @ 9TH FLOOR, Q.C. HALL MAIN BUILDING LOCATION: QUEZON CITY HALL COMPOUND ELLIPTICAL ROAD BARANGAY CENTRAL QUEZON CITY	SHEET CONTENTS: DETAIL OF TOILET @ CONFERENCE ROOM, 9TH FLOOR	PROJECT NO.: DATE: December 2021 DRAWN BY: K.C.M. DESIGNED BY: Ar. J.J. Ocasio / Ar. R.L. Belmonte CHECKED BY: Ar. A.G. Resurreccion	SHEET NO.: AR-16
---	---	--	--	--	---	--	---------------------------------------

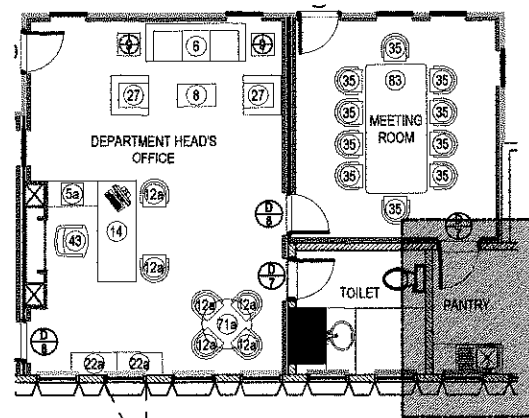


KEY PLAN

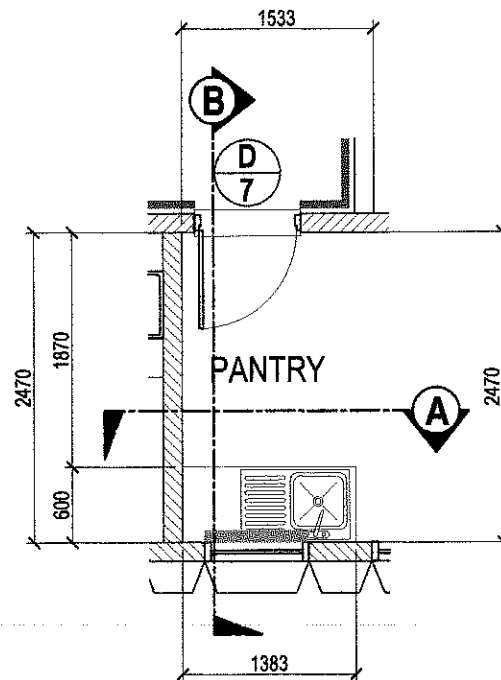


BLOW - UP PLAN

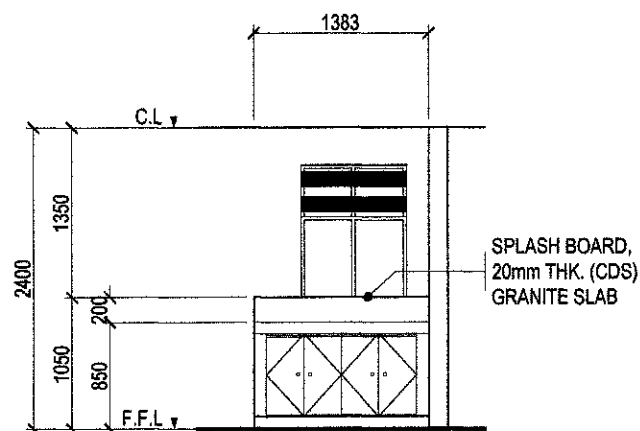


SECTION THRU 'A'

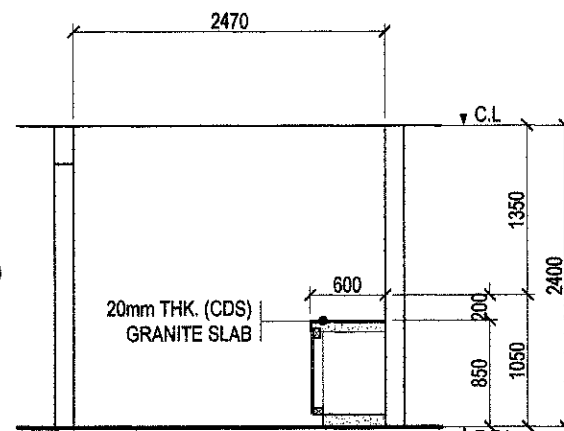


SECTION THRU 'B'

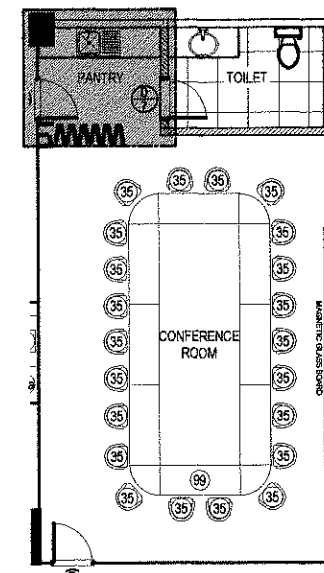


KEY PLAN

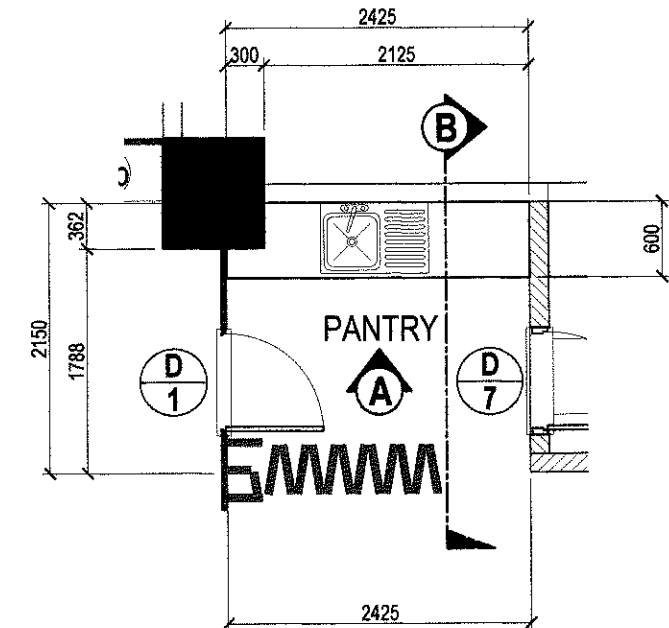


BLOW - UP PLAN

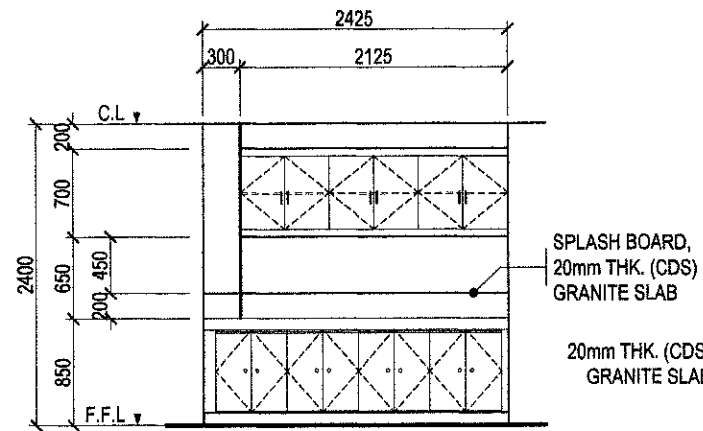

ELEVATION 'A'

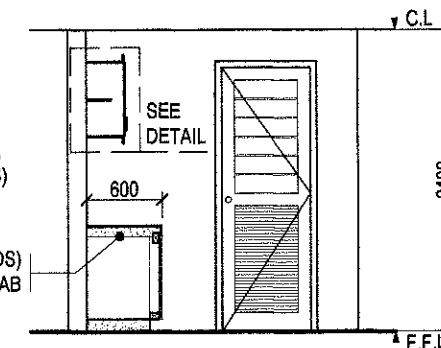

SECTION THRU 'B'

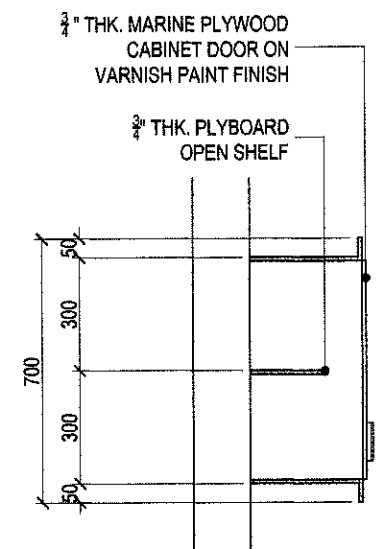

CABINET DETAIL

1

DETAIL OF PANTRY @ MEETING ROOM, 9TH FLOOR


SCALE 1:60 METERS

2

DETAIL OF PANTRY @ CONFERENCE ROOM, 9TH FLOOR

SCALE 1:60 METERS

Republika ng Pilipinas Lungsod ng Quezon CITY ARCHITECT DEPARTMENT OF CIVIC CENTER - D (Bldg. 348), QUEZON CITY HALL COMPOUND, ELLIPTICAL ROAD, DELMAN, QUEZON CITY	PROVISO: DRAWINGS AND SPECIFICATIONS ONLY SIGNED, STAMPED OR SEALED AS INSTRUMENTS OF SERVICE ARE THE INTELLECTUAL PROPERTY & DOCUMENTS OF THE CITY ARCHITECTS DEPARTMENT. WHETHER THE OBJECT FOR WHICH THEY ARE MADE IS EXECUTED OR NOT, IF BRAN BECAUSE OF ANY PERSON WITHOUT THE CONSENT OF THE AUTHOR OF SAID DOCUMENTS TO REPRODUCE OR TO MAKE COPIES OF SAID DOCUMENTS FOR USE IN THE REPRODUCTION OF ANY OTHER PROJECTS OR BUILDINGS, WHETHER EXECUTED PARTLY OR IN WHOLE.	RECOMMENDING APPROVAL <i>[Signature]</i> ARCH. LUCILLE L. GHUA, fuap, plep CITY ARCHITECT	APPROVED BY: <i>[Signature]</i> HON. MA. JOSEFINA G. BELMONTE MAYOR	PROJECT TITLE: SUPPLY AND INSTALLATION OF MODULAR PARTITIONS INCLUDING FURNITURE, AND OTHER WORKS FOR THE CITY GENERAL SERVICES DEPARTMENT @ 9TH FLOOR, O.C. HALL MAIN BUILDING LOCATION: QUEZON CITY HALL COMPOUND ELLIPTICAL ROAD BARANGAY CENTRAL QUEZON CITY	SHEET CONTENTS: DETAIL OF PANTRY @ MEETING ROOM, 9TH FLOOR DETAIL OF PANTRY @ CONFERENCE ROOM, 9TH FLOOR	PROJECT NO.: DATE: December 2021 DRAWN BY: K.C.M. DESIGNED BY: Ar. J.U. Cosa / Ar. R.I. Beltran CHECKED BY: Ar. R.G. Resurreccion	SHEET NO.: AR-17
---	---	--	--	--	--	---	---------------------------------------

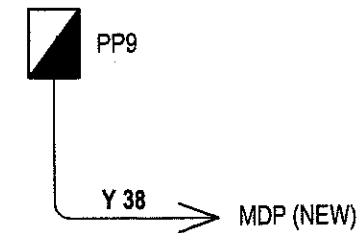


NTS

PANEL: PPG											
MAIN: 125AT, 200AF, 3P											
25KAIC, 240V, MCCB											
CKT NO.	VOLTS	OUTLET		OTHER LOAD SERVICE	AMPERE LOAD			3Ø	VOLT AMPERE	CIRCUIT BREAKER	SIZE OF WIRE
		LO	CO		AB	BC	CA				
1	230		10	1 - Emergency Light	8.61				1,980	20AT, 2P, Bolt-On	2 - 3.5mm ² THHN + 1 - 2.0mm ² THW(G) in 20mmØ PVC
2	230		12		9.39				2,160	20AT, 2P, Bolt-On	2 - 3.5mm ² THHN + 1 - 2.0mm ² THW(G) in 20mmØ PVC
3	230		8				6.26		1,440	20AT, 2P, Bolt-On	2 - 3.5mm ² THHN + 1 - 2.0mm ² THW(G) in 20mmØ PVC
4	230		7				5.48		1,260	20AT, 2P, Bolt-On	2 - 3.5mm ² THHN + 1 - 2.0mm ² THW(G) in 20mmØ PVC
5	230		8			6.26			1,440	20AT, 2P, Bolt-On	2 - 3.5mm ² THHN + 1 - 2.0mm ² THW(G) in 20mmØ PVC
6	230		11			8.61			1,980	20AT, 2P, Bolt-On	2 - 3.5mm ² THHN + 1 - 2.0mm ² THW(G) in 20mmØ PVC
7	230		8		6.26				1,440	20AT, 2P, Bolt-On	2 - 3.5mm ² THHN + 1 - 2.0mm ² THW(G) in 20mmØ PVC
8	230		7		5.48				1,260	20AT, 2P, Bolt-On	2 - 3.5mm ² THHN + 1 - 2.0mm ² THW(G) in 20mmØ PVC
9	230		12				9.39		2,160	20AT, 2P, Bolt-On	2 - 3.5mm ² THHN + 1 - 2.0mm ² THW(G) in 20mmØ PVC
10	230		8	1 - Emergency Light			7.04		1,620	20AT, 2P, Bolt-On	2 - 3.5mm ² THHN + 1 - 2.0mm ² THW(G) in 20mmØ PVC
11	230		7	4 - Emergency Light		8.61			1,980	20AT, 2P, Bolt-On	2 - 3.5mm ² THHN + 1 - 2.0mm ² THW(G) in 20mmØ PVC
12	230		9			7.04			1,620	20AT, 2P, Bolt-On	2 - 3.5mm ² THHN + 1 - 2.0mm ² THW(G) in 20mmØ PVC
13	230		12		9.39				2,160	20AT, 2P, Bolt-On	2 - 3.5mm ² THHN + 1 - 2.0mm ² THW(G) in 20mmØ PVC
14	230		11		8.61				1,980	20AT, 2P, Bolt-On	2 - 3.5mm ² THHN + 1 - 2.0mm ² THW(G) in 20mmØ PVC
15	230		12				9.39		2,160	20AT, 2P, Bolt-On	2 - 3.5mm ² THHN + 1 - 2.0mm ² THW(G) in 20mmØ PVC
16	230		9				7.04		1,620	20AT, 2P, Bolt-On	2 - 3.5mm ² THHN + 1 - 2.0mm ² THW(G) in 20mmØ PVC
17	230		8			6.26			1,440	20AT, 2P, Bolt-On	2 - 3.5mm ² THHN + 1 - 2.0mm ² THW(G) in 20mmØ PVC
18	230			Spare		6.52			1,600	20AT, 2P, Bolt-On	2 - 3.5mm ² THHN + 1 - 2.0mm ² THW(G) in 20mmØ PVC
19	230			Server Power Provision				32.00	12,733	40AT, 3P, Bolt-On	3 - 8.0mm ² THHN + 1 - 5.5mm ² THW(G) in 25mmØ PVC
20	230			Conference Room Power Provision		20.00			4,800	30AT, 2P, Bolt-On	2 - 5.5mm ² THHN + 1 - 3.5mm ² THW(G) in 20mmØ PVC
21	230			Space		-					
22	230			Space		-					
TOTAL					47.74	63.30	44.61	32.00	48,533		

$I_L = 63.30 \times \sqrt{3} + 32.00 \times 80\% \text{ D.F.} = 113.31 \text{ Amperes}$

Feeder Line:
 1line: 3 - 38mm² THHN + 1 - 8.0mm² THW(G) in 32mmØ IMC / Y3B

EL-01

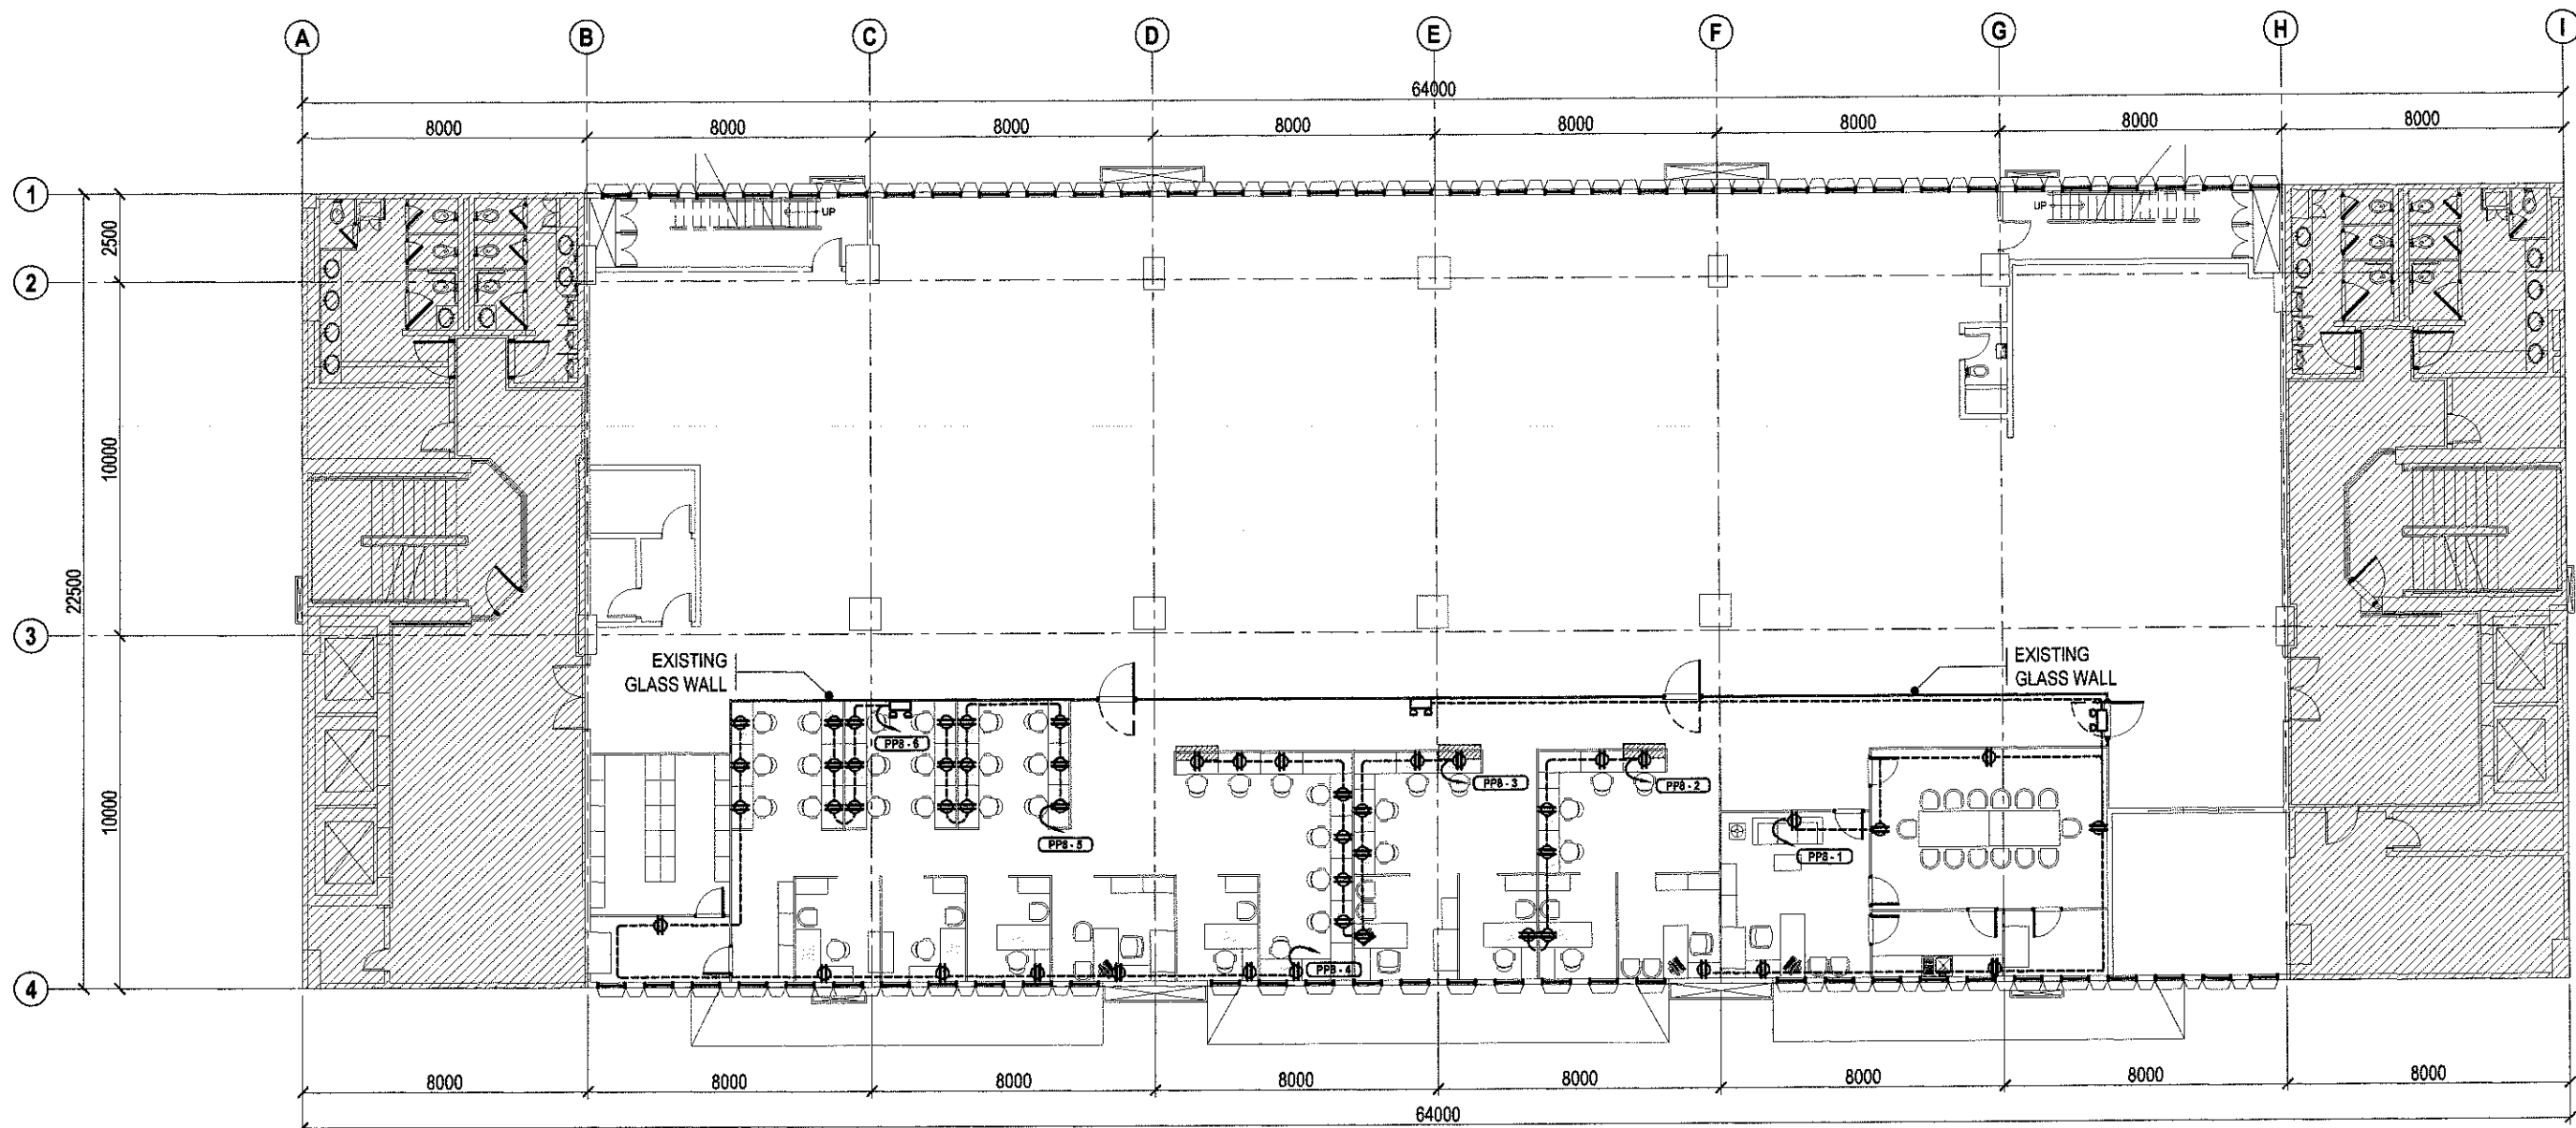

1 EIGHTH FLOOR POWER LAYOUT

SCALE 1:200 METERS



Republika ng Pilipinas
Lungsod ng Quezon
CITY ARCHITECT DEPARTMENT
5F CIVIC CENTER - D (BRO. SIG), QUEZON CITY HALL COMPOUND,
ELLIPTICAL ROAD, DELMAN, QUEZON CITY



PROVISO:

DRAWINGS AND SPECIFICATIONS ONLY
SIGNED, STAMPED OR SEALED AS
INSTRUMENTS OF SERVICE ARE THE
INTELLECTUAL PROPERTY & DOCUMENTS
OF THE CITY ARCHITECT DEPARTMENT.
WHETHER THE OBJECT FOR WHICH THEY
ARE MADE IS EXISTING OR NOT, IT SHALL
BE UNLAWFUL FOR ANY PERSON WITHOUT
THE CONSENT OF THE AUTHOR OF SAID
DOCUMENTS TO REPRODUCE OR TO MAKE
COPIES OF SAID DOCUMENTS FOR USE IN
THE EXECUTION OF AND FOR OTHER
PROJECTS OR BUILDINGS, WHETHER
EXECUTED PARTLY OR IN WHOLE.

RECOMMENDING APPROVAL

Arch. Lucille H. Chua
ARCH. LUCILLE H. CHUA, *lup, plep*
CITY ARCHITECT

APPROVED BY:

Hon. Ma. Josefina G. Belmonte
HON. MA. JOSEFINA G. BELMONTE
MAYOR

PROJECT TITLE:

**SUPPLY AND INSTALLATION OF MODULAR PARTITIONS
INCLUDING FURNITURE, AND OTHER WORKS FOR THE
CITY GENERAL SERVICES DEPARTMENT @ 8TH FLOOR,
Q.C. HALL MAIN BUILDING**

LOCATION: QUEZON CITY HALL COMPOUND ELLIPTICAL ROAD
BARANGAY CENTRAL QUEZON CITY

SHEET CONTENTS:


8TH FLOOR POWER LAYOUT

PROJECT NO.:

DATE: December 2021
DRAWN BY: K.C.M.
DESIGNED BY: Engr. T.B. Jr. / B.S. AR.G.
CHECKED BY: Engr. T.B. Infante Jr. / B.S. AR.G.

SHEET NO.:

EL-02

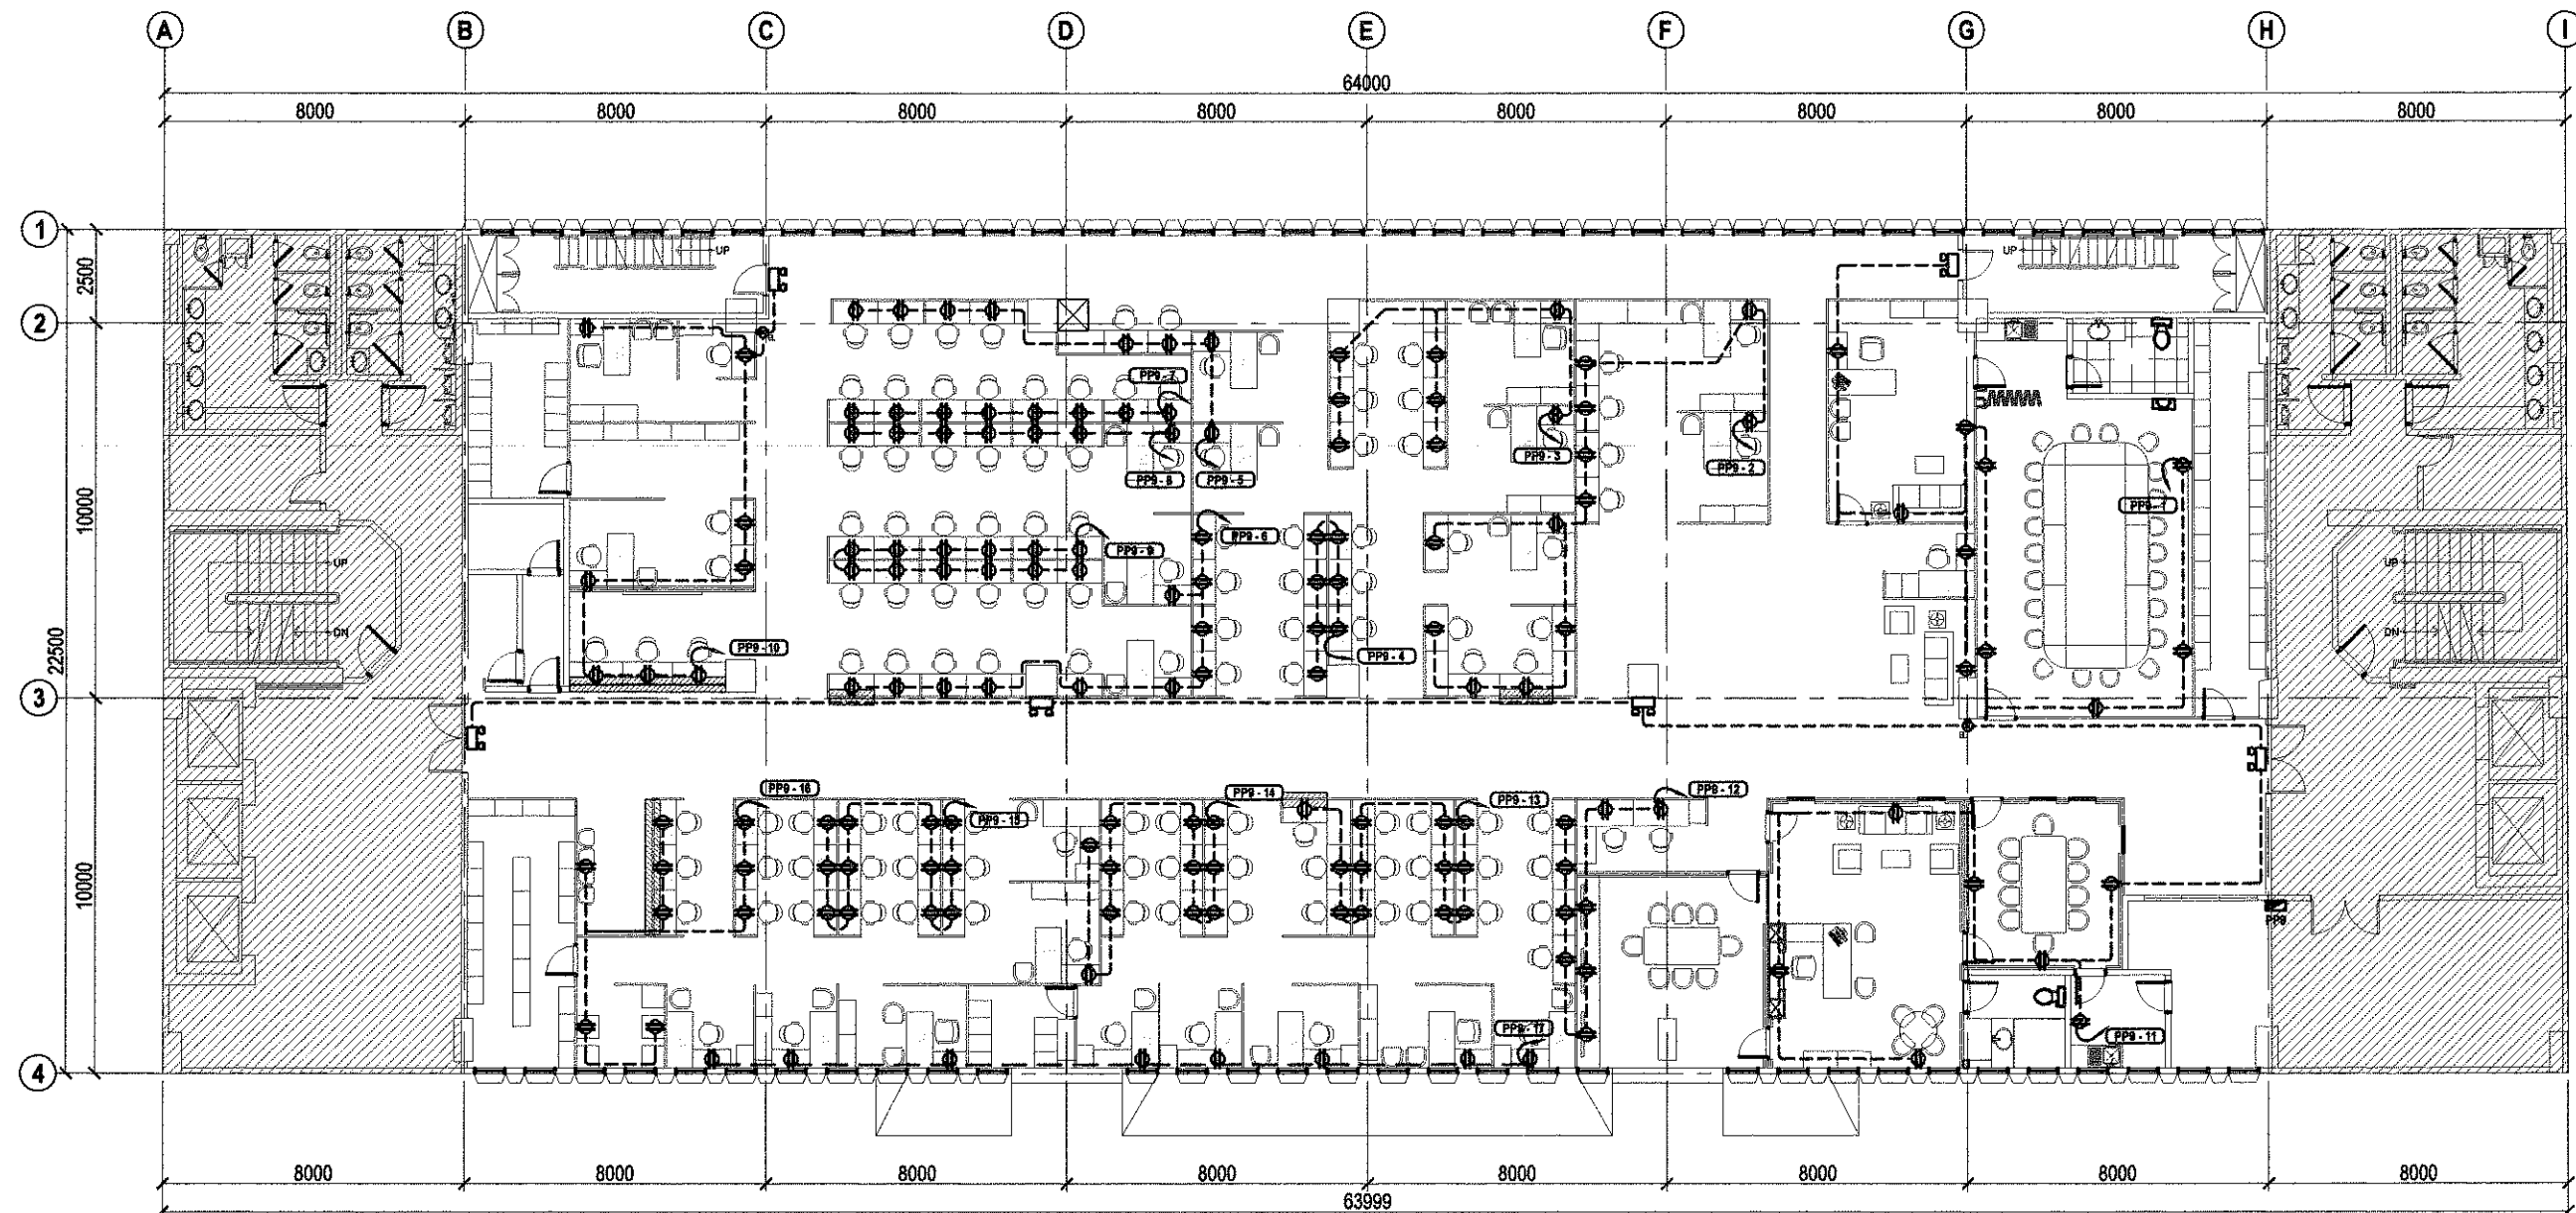

1 NINTH FLOOR POWER LAYOUT

SCALE 1:200 METERS



Republika ng Pilipinas
Lungsod ng Quezon
CITY ARCHITECT DEPARTMENT
88 CIVIC CENTER - D (PRO. Bldg.), QUEZON CITY HALL COMPOUND,
ELLIPTICAL ROAD, DILIMAN, QUEZON CITY



PROVISO:

Drawings and specifications duly
signed, stamped or sealed as
instruments of service are the
intellectual properties & documents
of the City Architect Department.
Whenever the subject for which they
are made is executed or not, it shall
be unlawful for any person, without
the consent of the author of said
documents to duplicate or to make
copies of said documents for use in
the repetition of and for other
projects or buildings, whether
executed partly or in whole.

RECOMMENDING APPROVAL

[Signature]
ARCH. VICENTE H. CHUA, fup, ptop
CITY ARCHITECT

APPROVED BY:

[Signature]
HON. MA. JOSEFINA G. BELMONTE
MAYOR

PROJECT TITLE:

**SUPPLY AND INSTALLATION OF MODULAR PARTITIONS
INCLUDING FURNITURE, AND OTHER WORKS FOR THE
CITY GENERAL SERVICES DEPARTMENT @ 9TH FLOOR,
Q.C. HALL MAIN BUILDING**

LOCATION: QUEZON CITY HALL COMPOUND ELLIPTICAL ROAD
BARANGAY CENTRAL QUEZON CITY

SHEET CONTENTS:

9TH FLOOR POWER LAYOUT

PROJECT NO.:


DATE December 2021
DRAWN BY K.C.M.
DESIGNED BY Engr. T.B.I. Jr. / Engr. A.R.G.
CHECKED BY Engr. T.B. Infante Jr.

SHEET NO.:


EL-03


	TELEPHONE TERMINAL CABINET		DUPLEX DATA OUTLET
	INTERMEDIATE DISTRIBUTION FRAME		SINGLE OUTLET FOR WIRELESS ACCESS DEVICE
	SINGLE DATA OUTLET		RISER UP
	VOICE AND DATA OUTLET		SINGLE CONVENIENCE OUTLET, CEILING MOUNTED TAPPED TO THE NEAREST LO

1 LEGENDS AND SYMBOLS

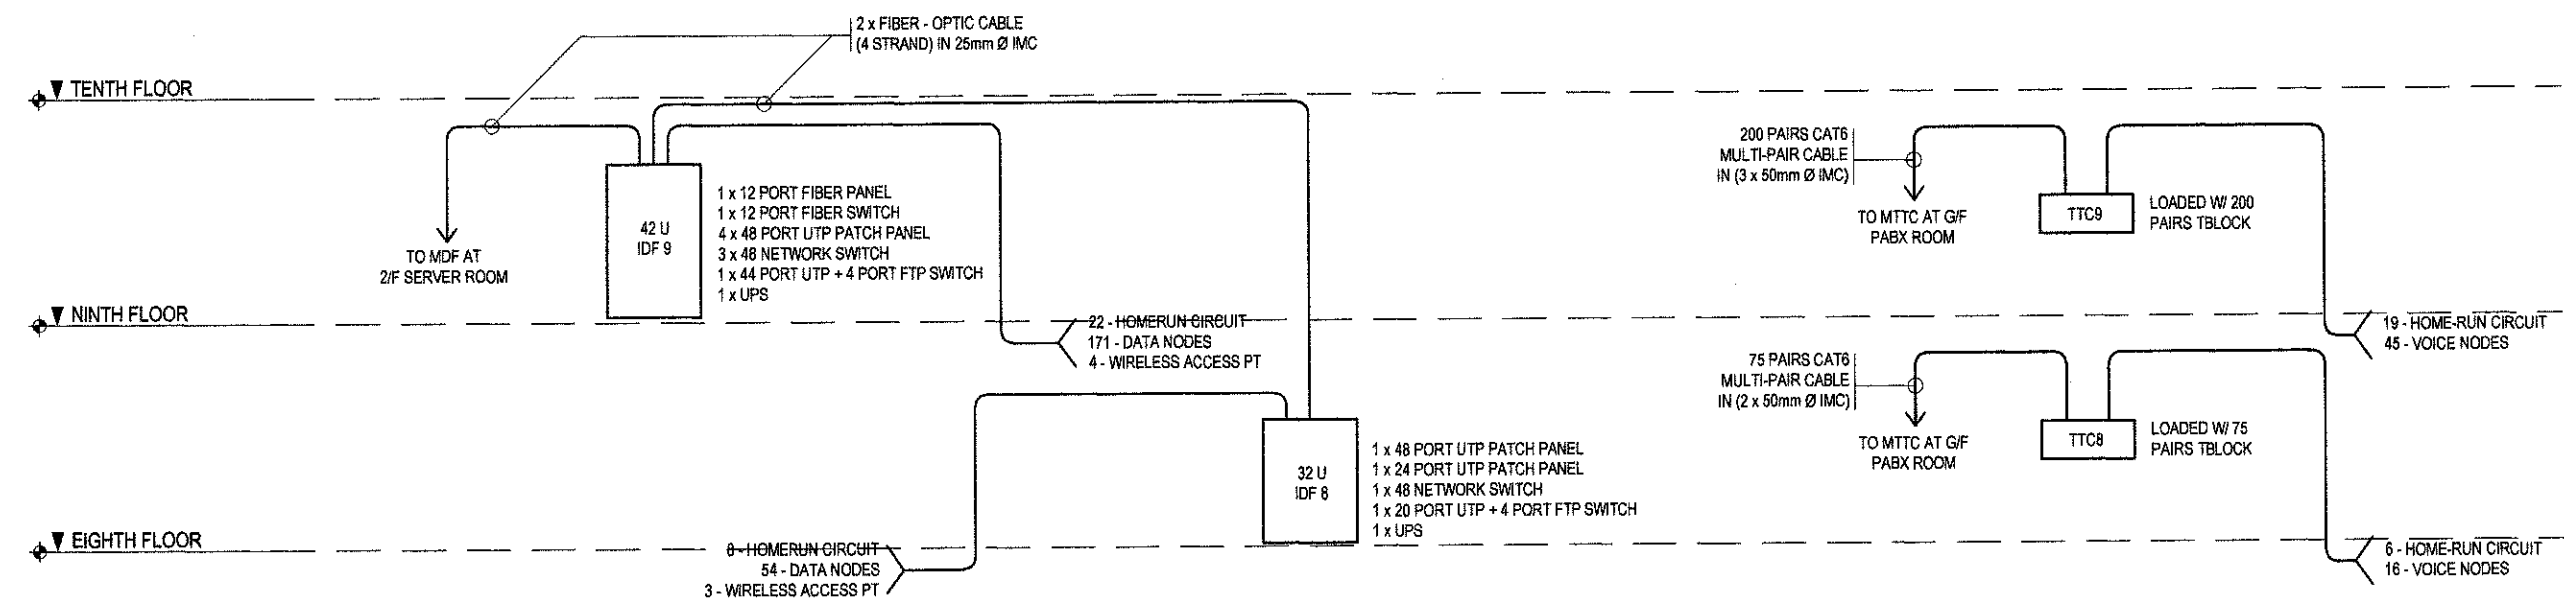

2 EIGHTH AND NINTH FLOOR VOICE AND DATA RISER DIAGRAM

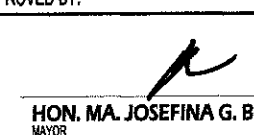 Republika ng Pilipinas Lungsod ng Quezon CITY ARCHITECT DEPARTMENT 5F CIVIC CENTER - D (BRO. Bldg), QUEZON CITY HALL COMPOUND, ELLIPTICAL ROAD, DILIMAN, QUEZON CITY		PROVISO: DRAWINGS AND SPECIFICATIONS ONLY SHOWN, STAMPED OR SEALED AS INSTRUMENTS OF SERVICE ARE THE PROPERTY OF THE CITY ARCHITECT DEPARTMENT. ANY REUSE OR REPRODUCTION OF THESE DRAWINGS WITHOUT THE CONSENT OF THE CITY ARCHITECT DEPARTMENT IS PROHIBITED.	RECOMMENDING APPROVAL  ARCH. MICHELLE H. CHUA, fupsp, plep CITY ARCHITECT	APPROVED BY:  HON. MA. JOSEFINA G. BELMONTE MAYOR	PROJECT TITLE: SUPPLY AND INSTALLATION OF MODULAR PARTITIONS INCLUDING FURNITURE, AND OTHER WORKS FOR THE GENERAL SERVICES DEPARTMENT @ 8TH FLOOR, Q.C. HALL MAIN BUILDING LOCATION: QUEZON CITY HALL COMPOUND ELLIPTICAL ROAD BARANGAY CENTRAL QUEZON CITY	SHEET CONTENTS: LEGENDS AND SYMBOLS 8TH & 9TH FLOOR VOICE AND DATA RISER DIAGRAM	PROJECT NO.: DATE: December 2021 DRAWN BY: J.S.M. DESIGNED BY: Engr. E.R. Silvestre CHECKED BY: Engr. E.R. Silvestre / Engr. T.B. Jr.	SHEET NO.: EL-04
---	--	---	---	---	---	--	---	---------------------------------------

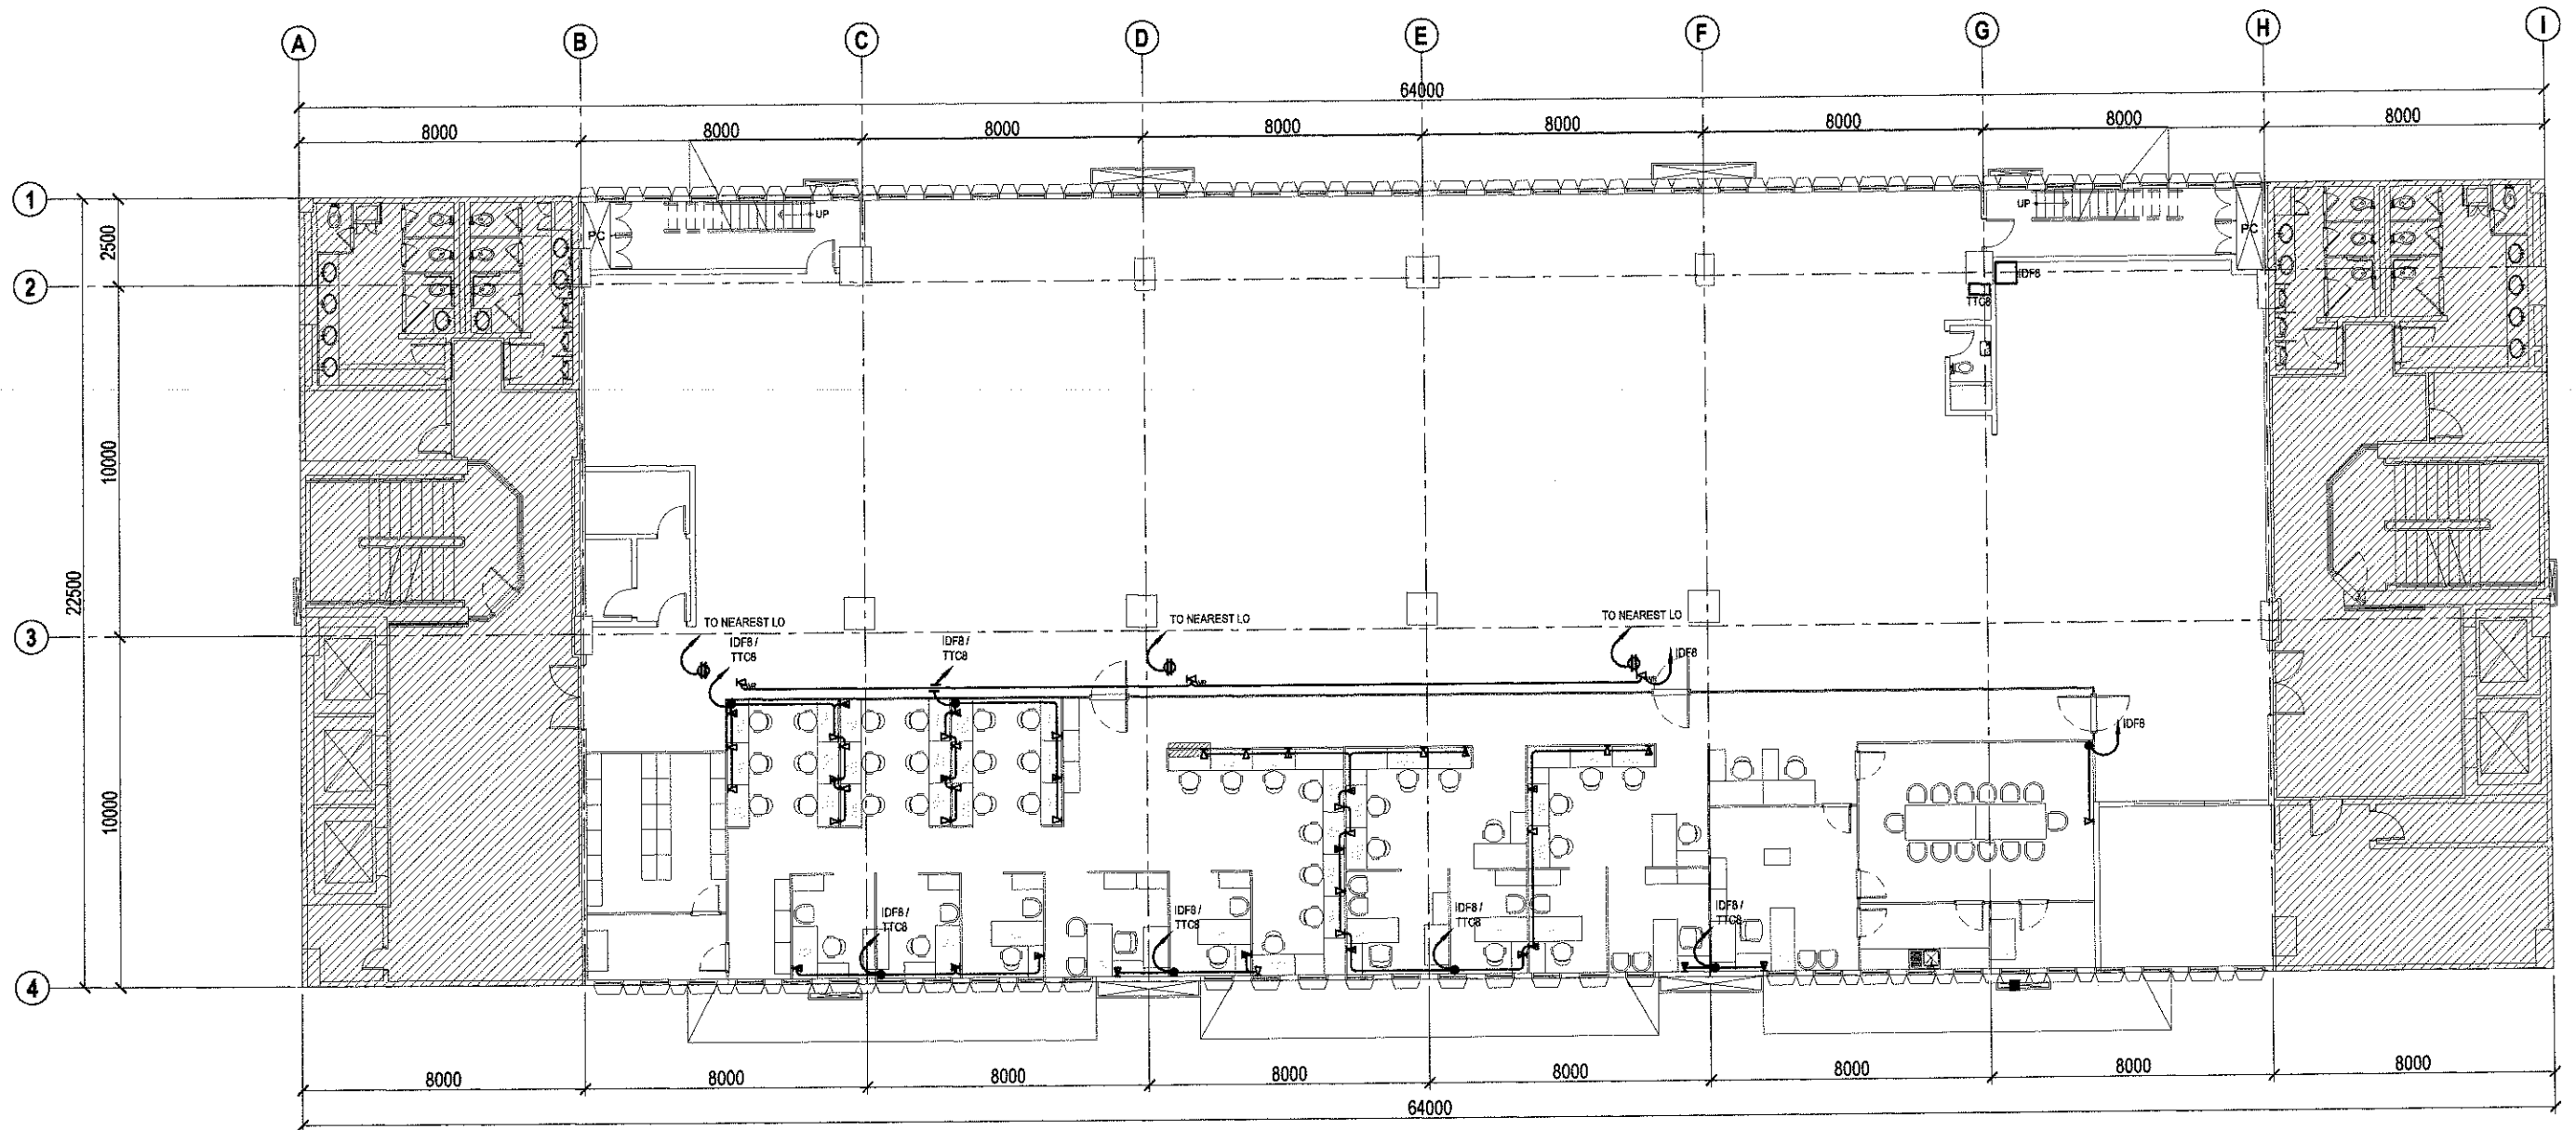

1 EIGHTH FLOOR VOICE AND DATA LAYOUT

SCALE 1:200 METERS



Republika ng Pilipinas
Lungsod ng Quezon
CITY ARCHITECT DEPARTMENT
5F CIVIC CENTER - D (BRO. RM), QUEZON CITY HALL COMPOUND,
ELLIPTICAL ROAD, DILIMAN, QUEZON CITY



PROVISO:

DRAWINGS AND SPECIFICATIONS ONLY
SIGNED, STAMPED OR SEALED AS
INSTRUMENTS OF SERVICE AND THE
INTELLECTUAL PROPERTY & COPYRIGHTS
OF THE CITY ARCHITECTS DEPARTMENT.
WHETHER THE SUBJECT FOR WHICH THEY
ARE MADE IS EXISTING OR NOT, IT SHALL
BE UNLAWFUL FOR ANY PERSON WITHOUT
THE CONSENT OF THE ARCHITECT OF SAID
DOCUMENTS TO REPRODUCE OR TO MAKE
COPIES OF SAID DOCUMENTS FOR USE IN
THE REPRODUCTION OF AND FOR OTHER
PROJECTS OR BUILDINGS, WHETHER
PRESENTED PARTLY OR IN WHOLE.

RECOMMENDING APPROVAL

ARCH. LUCILLE H. CHUA, fuaap, plep
CITY ARCHITECT

APPROVED BY:

HON. MA. JOSEFINA G. BELMONTE
MAYOR

PROJECT TITLE:

SUPPLY AND INSTALLATION OF MODULAR PARTITIONS
INCLUDING FURNITURE, AND OTHER WORKS FOR THE
GENERAL SERVICES DEPARTMENT @ 8TH FLOOR,
Q.C. HALL MAIN BUILDING

LOCATION: QUEZON CITY HALL COMPOUND ELLIPTICAL ROAD
BARRANGAY CENTRAL QUEZON CITY

SHEET CONTENTS:


8TH FLOOR VOICE AND DATA LAYOUT

PROJECT NO.:

DATE December 2021
DRAWN BY J.S.M.
DESIGNED BY Engr. E.R. Sibucan
CHECKED BY Engr. E.R.S. / Engr. T.B. Jr.

SHEET NO.:

EL-05

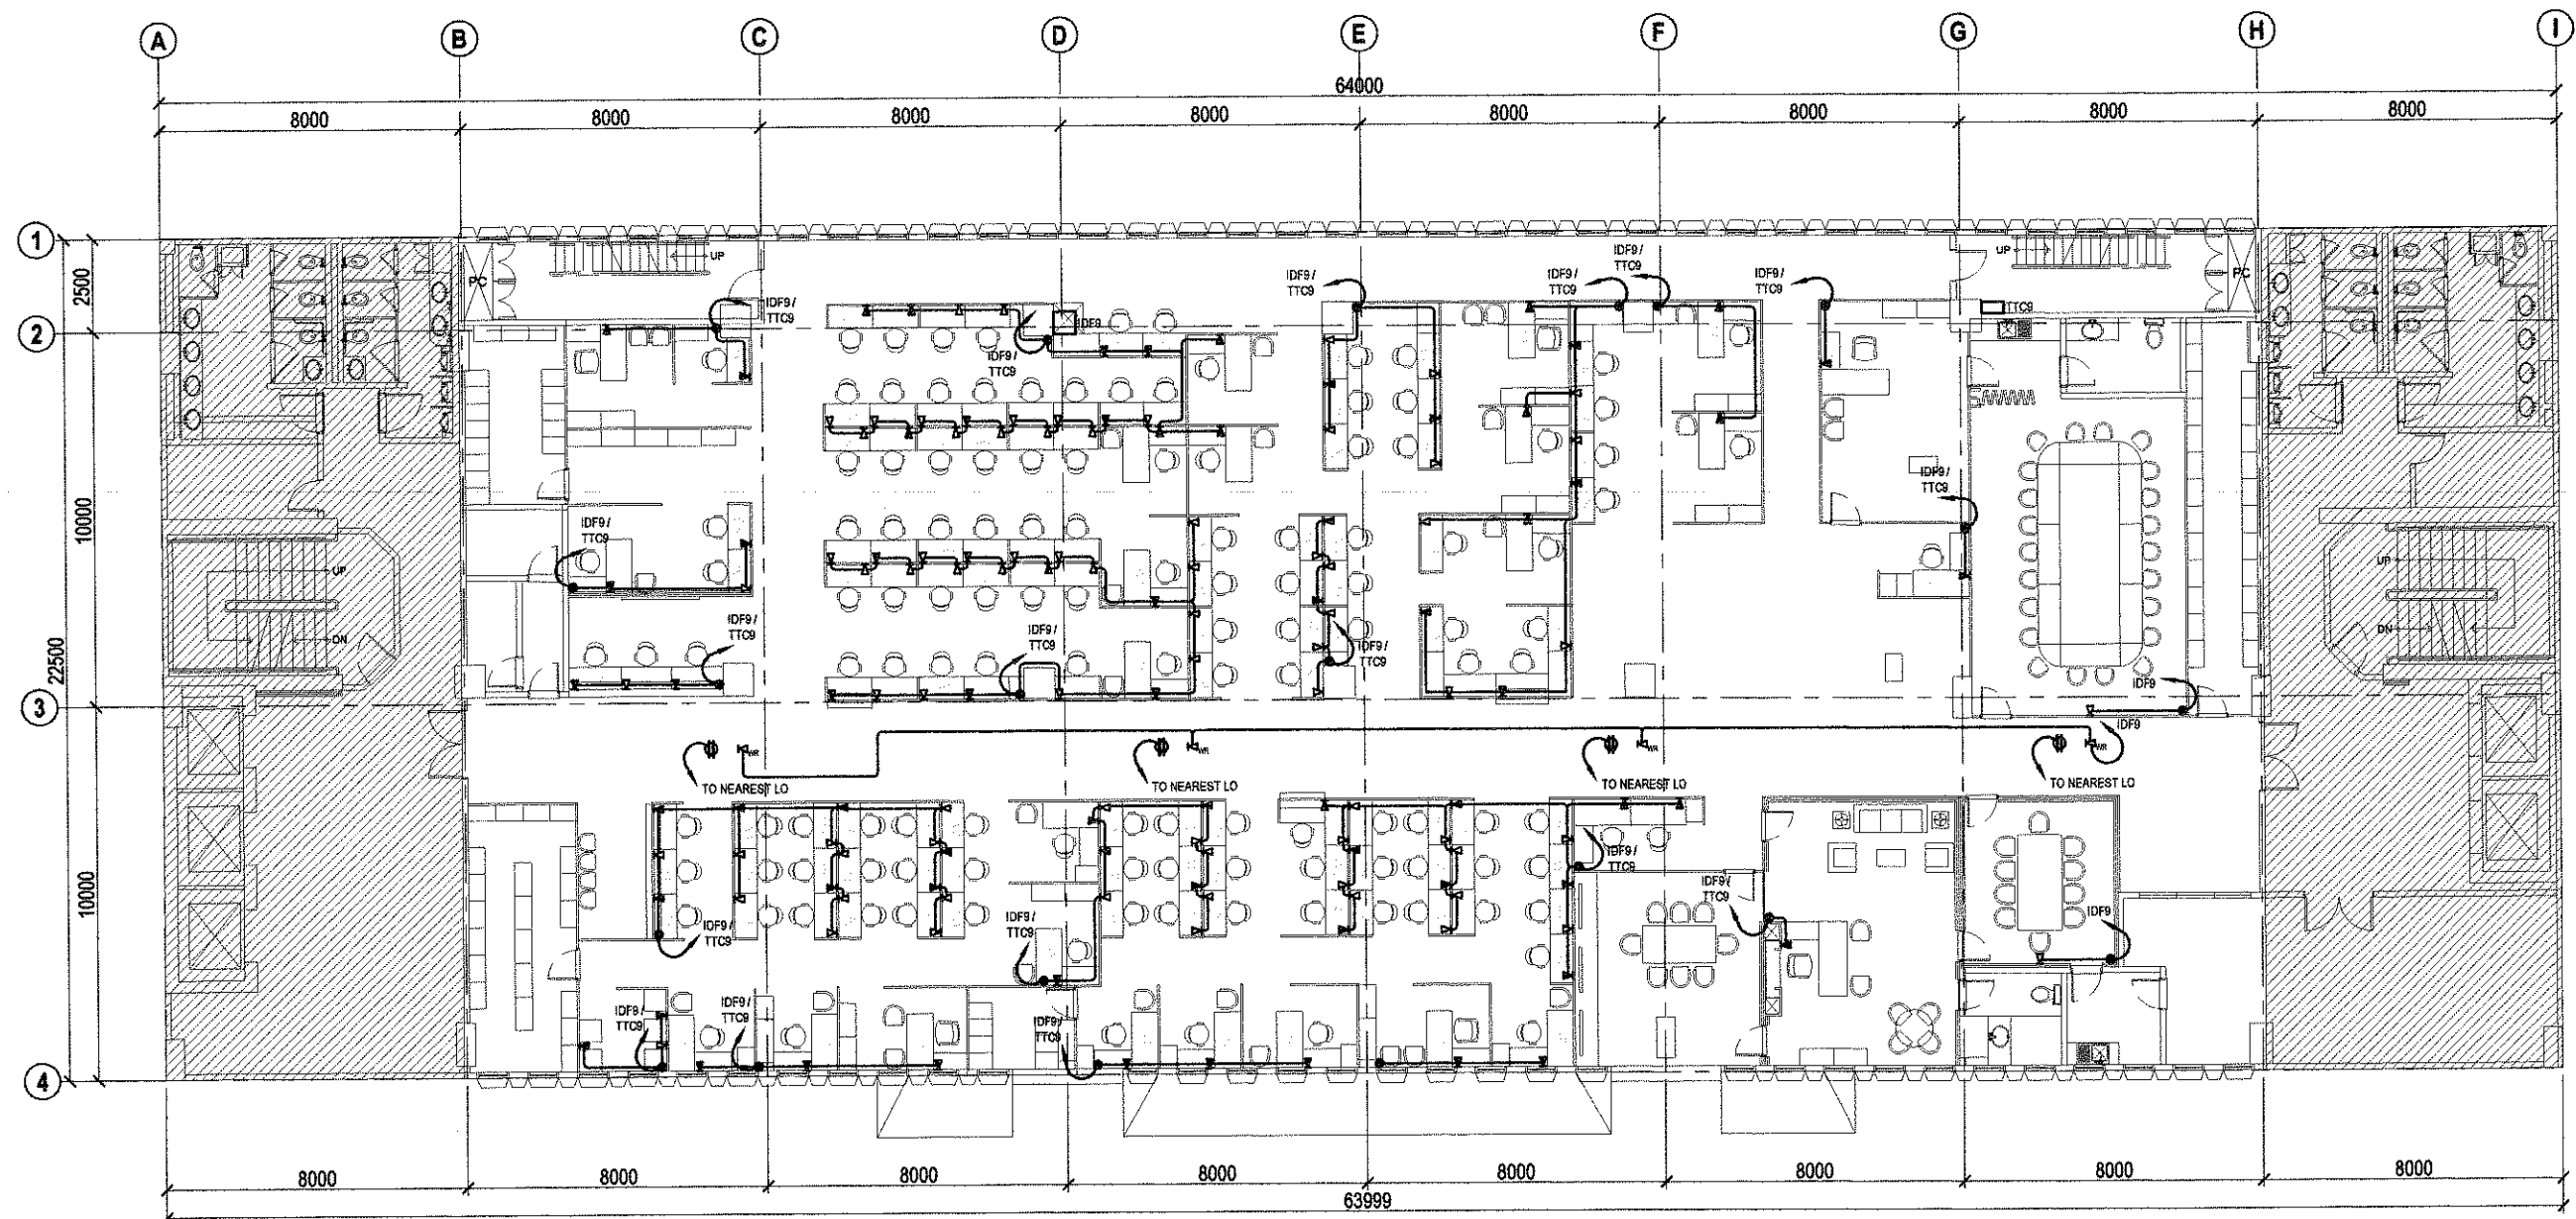

1 NINTH FLOOR VOICE AND DATA LAYOUT

SCALE 1:200 METERS



Republika ng Pilipinas
Lungsod ng Quezon
CITY ARCHITECT DEPARTMENT
5F CIVIC CENTER - D (BRO. BAY), QUEZON CITY HALL COMPOUND,
ELLIPTICAL ROAD, DUMAN, QUEZON CITY



PROVISO:

DRAWINGS AND SPECIFICATIONS DULY
SIGNED, STAMPED OR SEALED AS
INSTRUMENTS OF SERVICE ARE THE
INTELLECTUAL PROPERTY & DOCUMENTS
OF THE CITY ARCHITECT DEPARTMENT.
WHETHER THE OBJECT FOR WHICH THEY
ARE MADE IS SPECIFIED OR NOT, IT SHALL
BE UNLAWFUL FOR ANY PERSON WITHOUT
THE CONSENT OF THE AUTHOR OF SAID
DOCUMENTS TO DUPLICATE OR TO MAKE
COPIES OF SAID DOCUMENTS FOR USE IN
THE REPERITION OF AND FOR OTHER
PROJECTS OR BUILDINGS, WHETHER
EXECUTED, BUILT, OR IN PROGRESS.

RECOMMENDING APPROVAL

[Signature]
ARCH. NICILLE H. CHUA, tuap, plep
CITY ARCHITECT

APPROVED BY:

[Signature]
HON. MA. JOSEFINA G. BELMONTE
MAYOR

PROJECT TITLE :

**SUPPLY AND INSTALLATION OF MODULAR PARTITIONS
INCLUDING FURNITURE, AND OTHER WORKS FOR THE
CITY GENERAL SERVICES DEPARTMENT @ 9TH FLOOR,
Q.C. HALL MAIN BUILDING**

LOCATION: QUEZON CITY HALL COMPOUND ELLIPTICAL ROAD
BARANGAY CENTRAL QUEZON CITY

SHEET CONTENTS :

9TH FLOOR VOICE AND DATA LAYOUT

PROJECT NO.:

DATE December 2021
DRAWN BY J.S.M
DESIGNED BY Engr. E.R. Sibucso
CHECKED BY Engr. E.R.S./Engr. T.B.L.

SHEET NO.:


EL-06



SCALE 1:100 METERS



SCALE 1:100 METERS

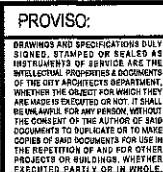

RECOMMENDING APPROVAL:

ARCH. JUCILLE H. CHUA, *tuap, plep*
CITY ARCHITECT

APPROVED BY:

HON. MA. JOSEFINA G. BELMONTE
MAYOR Q.C.

PROJECT TITLE:

**SUPPLY AND INSTALLATION OF MODULAR PARTITIONS
INCLUDING FURNITURE, AND OTHER WORKS FOR THE
CITY GENERAL SERVICES DEPARTMENT @ 8TH FLOOR,
O.C. HALL MAIN BUILDING**

LOCATION: QUEZON CITY HALL COMPOUND ELLIPTICAL ROAD
BARANGAY CENTRAL QUEZON CITY

SHEET CONTENTS :


8TH FLOOR SANITARY LINE LAYOUT
8TH FLOOR WATERLINE LAYOUT

PROJECT NO.:



DATE	December 2021
DRAWN BY	K.C.M
DESIGNED BY	Engr. E.R. Sibucan
CHECKED BY	Engr. E.R. Sibucan

SHEET NO.:

PL-01

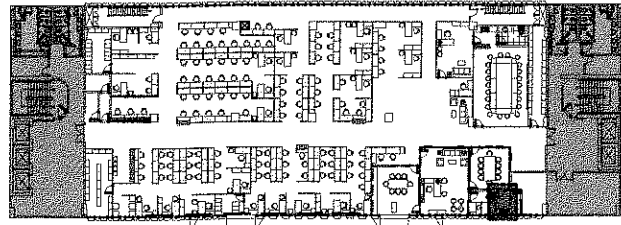

KEY PLAN

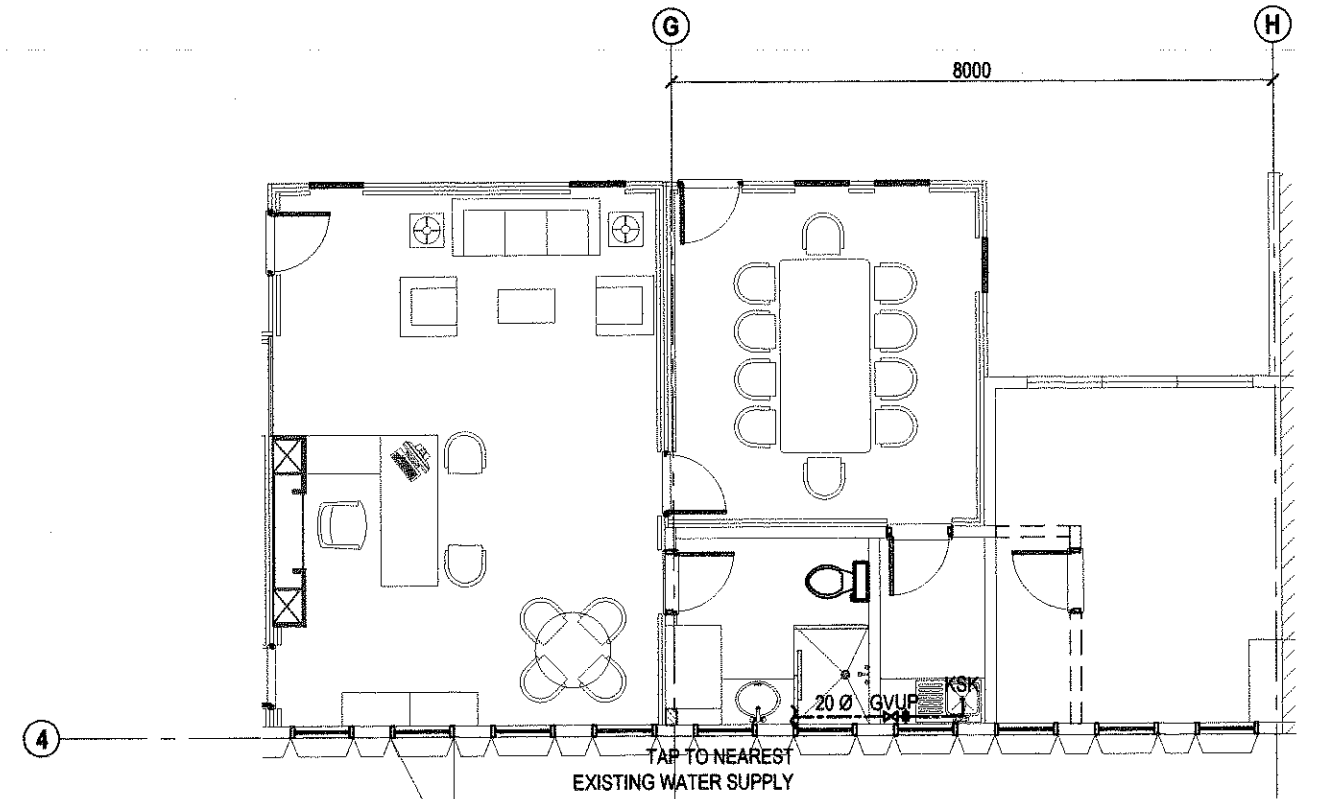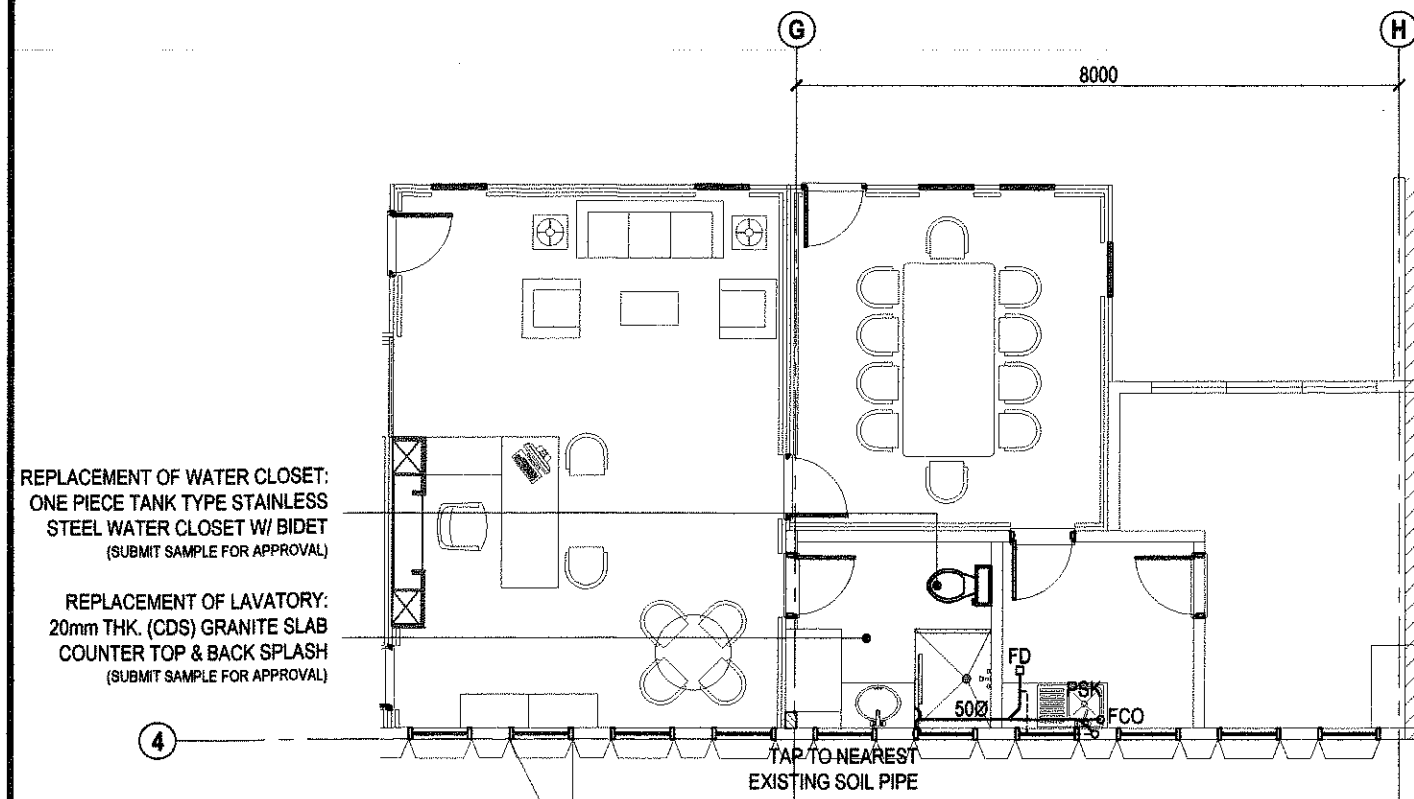

1 NINTH FLOOR SANITARY LINE LAYOUT

SCALE 1:100 METERS

2 NINTH FLOOR WATERLINE LAYOUT

SCALE 1:100 METERS



Republika ng Pilipinas
Lungsod ng Quezon
CITY ARCHITECT DEPARTMENT
5F CIVIC CENTER - D/BRO. 1844, QUEZON CITY HALL COMPOUND,
ELLIPTICAL ROAD, DILIMAN, QUEZON CITY



PROVISO:

DRAWINGS AND SPECIFICATIONS ONLY
SHOWN, STAMPED OR SEALED AS
INSTRUMENTS OF SERVICE ARE THE
INTELLECTUAL PROPERTY & DOCUMENTS
OF THE CITY ARCHITECTS DEPARTMENT.
WHETHER THE OBJECT FOR WHICH THEY
ARE MADE IS EXECUTED OR NOT IT SHALL
BE UNLAWFUL FOR ANY PERSON WITHOUT
THE CONSENT OF THE AUTHOR OF SAID
DOCUMENTS TO DUPLICATE OR TO MAKE
COPIES OF SAID DOCUMENTS FOR USE IN
THE REPRODUCTION OF AND FOR OTHER
PROJECTS OR BUILDINGS, WHETHER
EXECUTED PARTLY OR IN WHOLE.

RECOMMENDING APPROVAL

[Signature]
ARCH. DANIEL H. CHUA, fup, plep
CITY ARCHITECT

APPROVED BY:

[Signature]
HON. MA. JOSEFINA G. BELMONTE
MAYOR O.C.

PROJECT TITLE:

**SUPPLY AND INSTALLATION OF MODULAR PARTITIONS
INCLUDING FURNITURE, AND OTHER WORKS FOR THE
CITY GENERAL SERVICES DEPARTMENT @ 9TH FLOOR,
O.C. HALL MAIN BUILDING**

LOCATION: QUEZON CITY HALL COMPOUND ELLIPTICAL ROAD
BARANGAY CENTRAL QUEZON CITY

SHEET CONTENTS:

9TH FLOOR SANITARY LINE LAYOUT
9TH FLOOR WATERLINE LAYOUT

PROJECT NO.:

DATE December 2021
DRAWN BY K.C.M.
DESIGNED BY Engr. E.R. Sibucan / R.F.P.
CHECKED BY Engr. E.R. Sibucan

SHEET NO.:

PL-02