



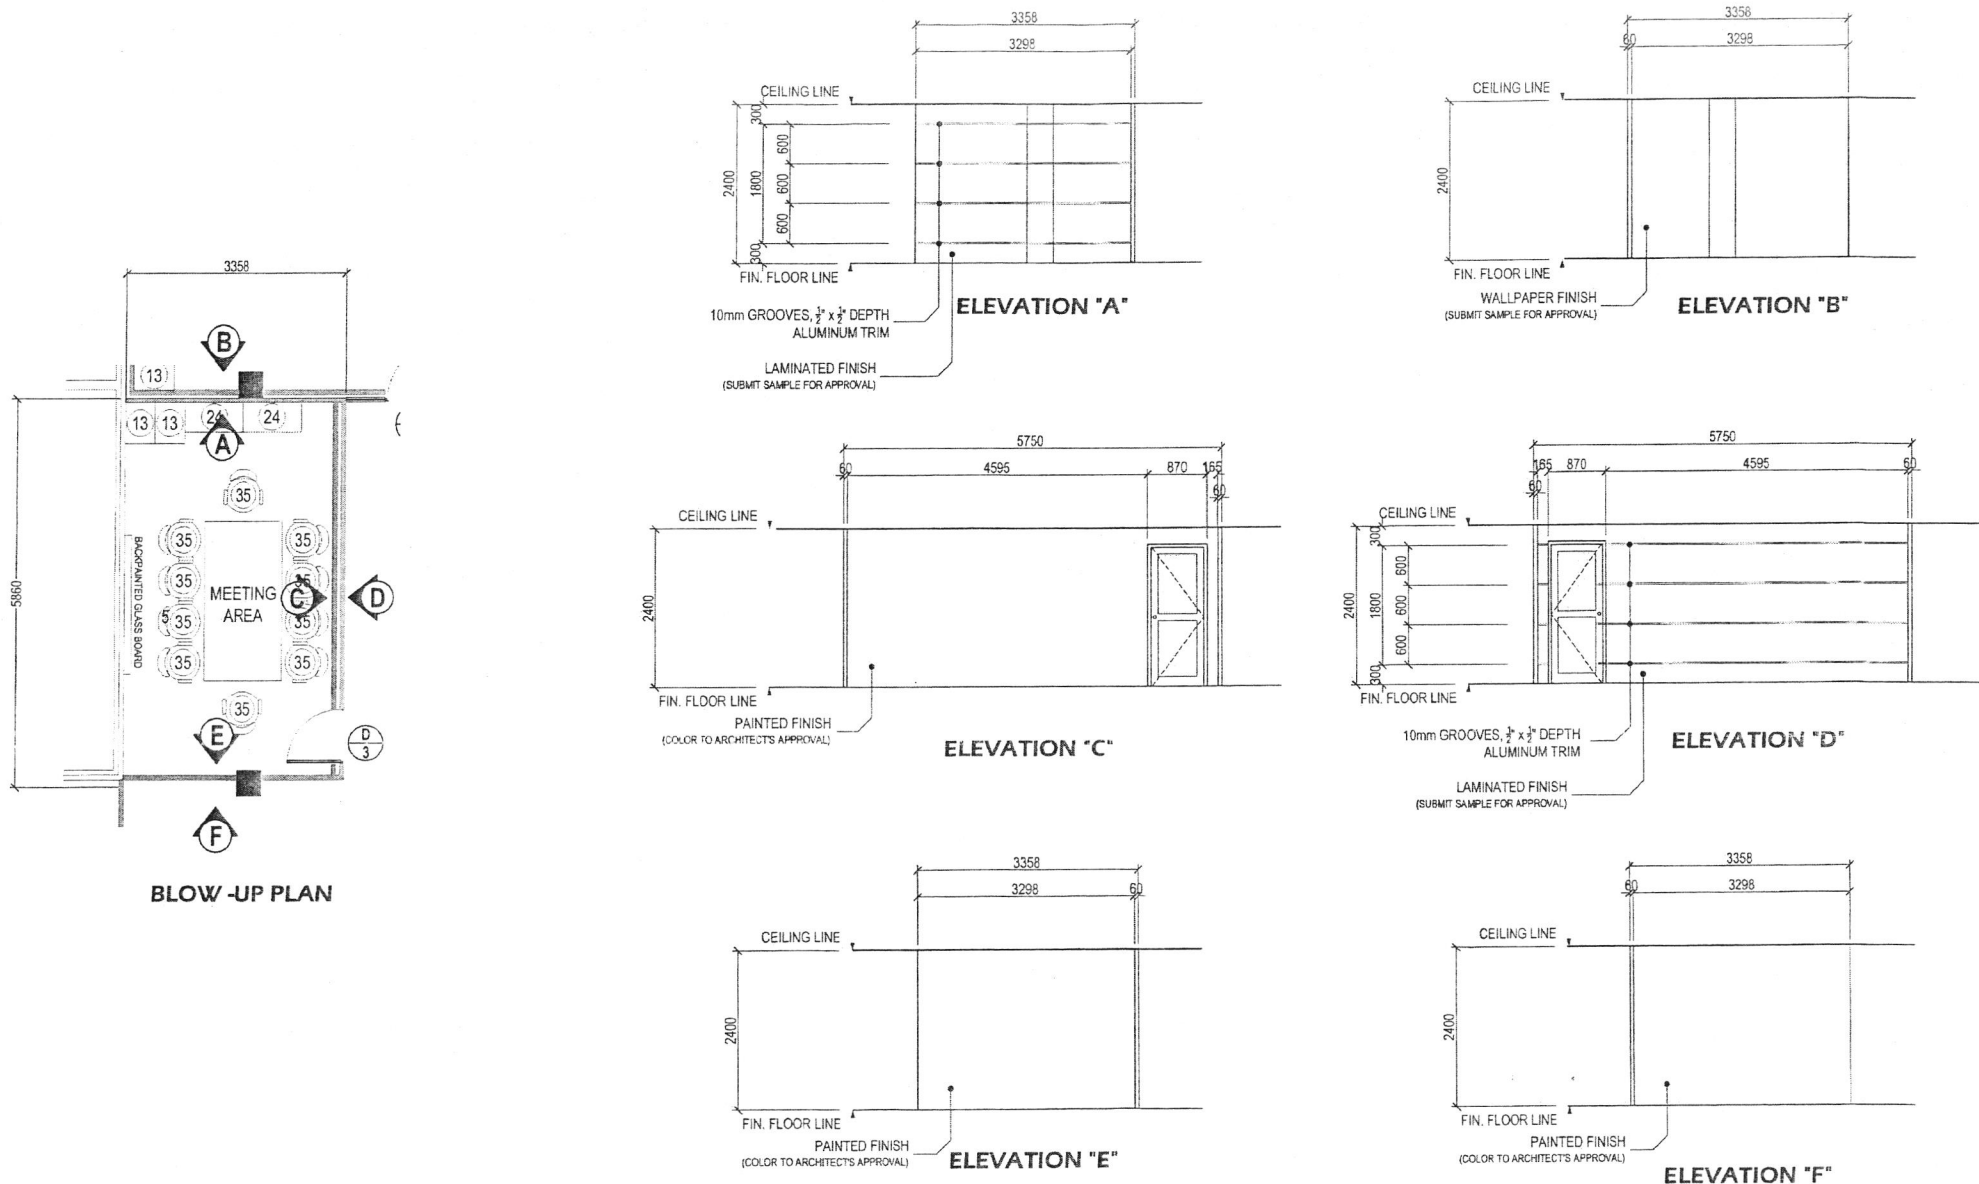

# 1 | DETAIL OF DEPARTMENT HEAD OFFICE - SECOND FLOOR CCRD

SCALE 1:80 METERS

|                                                                                                                                                                                                                                                                   |                                                                                                                                                                                                                                                                                                                                                                    |                                                                                                                 |                                                                                          |                                                                                                                                                                                                                                                                        |                                                                      |                                                                                                                                      |                                       |
|-------------------------------------------------------------------------------------------------------------------------------------------------------------------------------------------------------------------------------------------------------------------|--------------------------------------------------------------------------------------------------------------------------------------------------------------------------------------------------------------------------------------------------------------------------------------------------------------------------------------------------------------------|-----------------------------------------------------------------------------------------------------------------|------------------------------------------------------------------------------------------|------------------------------------------------------------------------------------------------------------------------------------------------------------------------------------------------------------------------------------------------------------------------|----------------------------------------------------------------------|--------------------------------------------------------------------------------------------------------------------------------------|---------------------------------------|
|  <p>Reynolds ng Piliplan<br/>Lungsod ng Quezon<br/><b>CITY ARCHITECT DEPARTMENT</b><br/>CIVIC CENTER - 3990 Esg. QUEZON CITY HALL COMPOUND<br/>ELLIPICAL ROAD, QUEZON CITY</p> | <p>PROVISO:</p> <p>REMARKS AND REVISIONS SHALL BE MADE, STAMPED OR SIGNED BY THE ARCHITECT OR HIS DELEGATE. THE ARCHITECT SHALL BE RESPONSIBLE FOR THE ACCURACY OF THE INFORMATION PROVIDED. THE ARCHITECT SHALL BE RESPONSIBLE FOR THE ACCURACY OF THE INFORMATION PROVIDED. THE ARCHITECT SHALL BE RESPONSIBLE FOR THE ACCURACY OF THE INFORMATION PROVIDED.</p> | <p>RECOMMENDING APPROVAL:</p> <p><i>[Signature]</i><br/>ARCH. LUCILE H. CHUA, fuap, piep<br/>CITY ARCHITECT</p> | <p>APPROVED BY:</p> <p><i>[Signature]</i><br/>HON. MA. JOSEFINA G. BELMONTE<br/>C.C.</p> | <p>PROJECT TITLE:</p> <p>SUPPLY AND INSTALLATION OF MODULAR PARTITIONS INCLUDING FURNITURE AND OTHER WORKS FOR CITY CIVIL REGISTRY DEPARTMENT (CCRD) AT 2ND FLOOR, CIVIC CENTER BUILDING C</p> <p>LOCATION: QUEZON CITY HALL COMPOUND, ELLIPICAL ROAD, QUEZON CITY</p> | <p>SHEET CONTENTS:</p> <p>DETAIL OF MEETING AREA - 2ND FLR. CCRD</p> | <p>PROJECT NO.:</p> <p>DATE: March 2023<br/>DRAWN BY: KCM/A/B/D/B<br/>DESIGNED BY: Ar. RLB<br/>CHECKED BY: Ar. R.G. Resurreccion</p> | <p>SHEET NO.:</p> <p><b>AR-02</b></p> |
|-------------------------------------------------------------------------------------------------------------------------------------------------------------------------------------------------------------------------------------------------------------------|--------------------------------------------------------------------------------------------------------------------------------------------------------------------------------------------------------------------------------------------------------------------------------------------------------------------------------------------------------------------|-----------------------------------------------------------------------------------------------------------------|------------------------------------------------------------------------------------------|------------------------------------------------------------------------------------------------------------------------------------------------------------------------------------------------------------------------------------------------------------------------|----------------------------------------------------------------------|--------------------------------------------------------------------------------------------------------------------------------------|---------------------------------------|

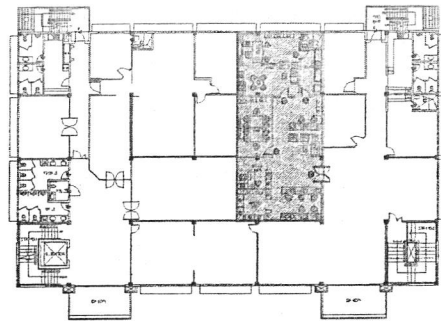

KEY PLAN

LEGEND:

- MODULAR LAMINATED PARTITION, WITH OR WITHOUT GLASS
- FABRIC WITH GLASS LOW PARTITION, 1.5m height
- MODULAR DESKS, 0.60m WIDTH
- DRYWALL PARTITION - LAMINATE ONE SIDE, WALL PAPER ONE SIDE
- DRYWALL PARTITION - LAMINATE ONE SIDE, PAINTED ONE SIDE
- DRYWALL PARTITION - PAINTED ONE SIDE, WALL PAPER ONE SIDE
- WALL PAPER


- DRYWALL PARTITION - PAINTED BOTH SIDES
- ROLLER SHADES (COMBI)
- CHROME LEG

DOORS:

- (D3) PANEL DOOR WITH HALF GLASS, WITH LAMINATE FINISH, 0.8m X 2.10mH
- (D4) FLUSH DOOR, PAINTED BOTH SIDES, 0.70M X 2.10mH
- (D10) DOUBLE ACTION DOUBLE LEAF FRAMELESS GLASS DOOR

FURNITURES:

- (1) GANG CHAIR - 3 SEATER
- (4) STAFF CHAIR
- (5) CABINET MOBILE PEDESTAL
- (5a) EXECUTIVE MOBILE PEDESTAL
- (8) CENTER TABLE - STAINLESS STEEL BASE
- (9) SIDE TABLE - STAINLESS STEEL BASE
- (11) MANAGERS HIGH BACK CHAIR
- (12a) EXECUTIVE VISITOR'S CHAIR
- (12c) MANAGER VISITOR'S CHAIR
- (13) VERTICAL FILING CABINET, 4 - DRAWERS
- (14) EXECUTIVE TABLE WITH SIDE TABLE, 2.00m X 1.0m
- (22a) LATERAL FILING CABINET WOODEN 4-LAYERS, 0.90mL X 0.45mW X 1.06mH
- (22b) LOW CABINET, 0.90mL X 0.45mW X 1.06 height
- (24) LATERAL FILING CABINET, 3 - DRAWERS
- (27) SOFA - 1 SEATER
- (30) FREE STANDING TABLE WITH SIDE TABLE 1.50mL X 0.70mW
- (35) CONFERENCE CHAIR
- (71a) ROUND TABLE, GLASS TOP, .90m Ø





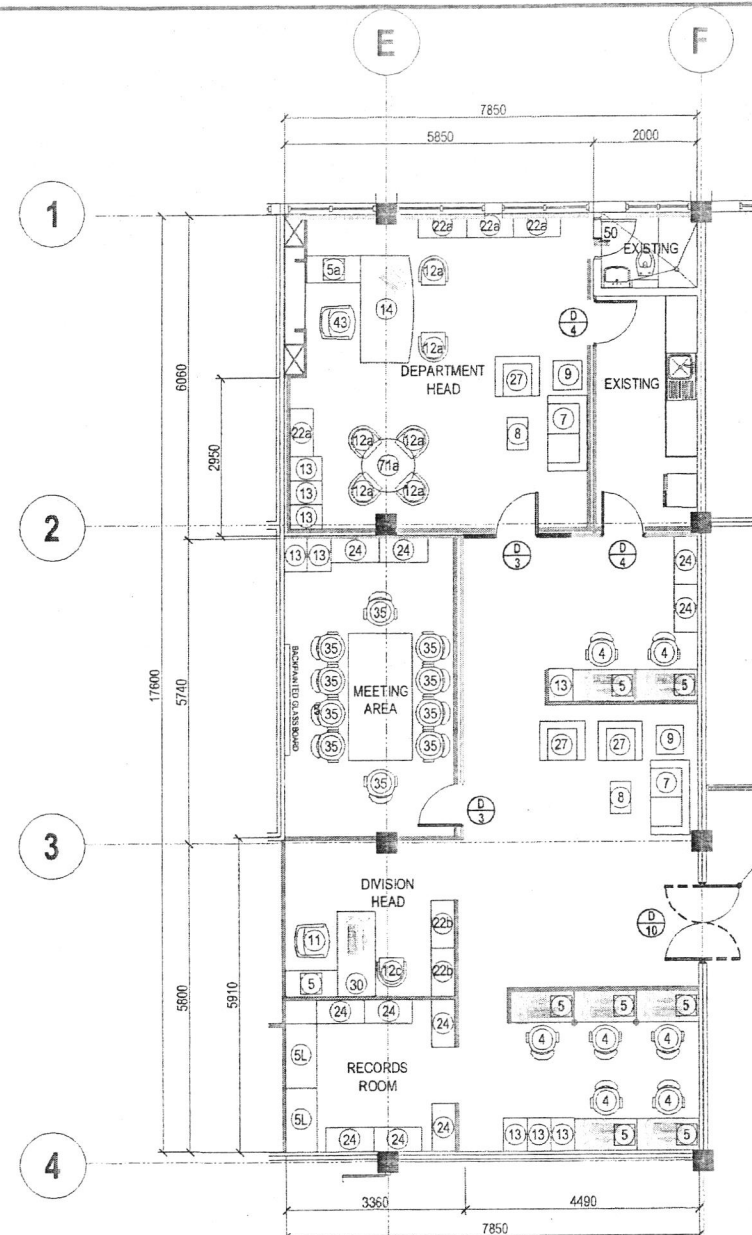


NEW DOOR  
(SEE DETAIL AR-04,  
BOX 1)

1 SECOND FLOOR FURNITURE LAYOUT - CCRD

SCALE 1:100 METERS


|                                                                                                                                                                                       |                                                                                                       |                                                                                          |                                                                    |                                                                                                                                                                                                                                                                      |                                                                    |                                                                                                                                                     |                                       |
|---------------------------------------------------------------------------------------------------------------------------------------------------------------------------------------|-------------------------------------------------------------------------------------------------------|------------------------------------------------------------------------------------------|--------------------------------------------------------------------|----------------------------------------------------------------------------------------------------------------------------------------------------------------------------------------------------------------------------------------------------------------------|--------------------------------------------------------------------|-----------------------------------------------------------------------------------------------------------------------------------------------------|---------------------------------------|
| <p>Republic of the Philippines<br/>Lungsod ng Quezon<br/><b>CITY ARCHITECT DEPARTMENT</b><br/>5F CIVIC CENTER - 6890 Blvd. QUEZON CITY, QUEZON CITY<br/>BULACAN ROAD, QUEZON CITY</p> | <p>PROVIDED:</p> <p>DESIGNED AND PROVIDED BY: ARCH. LUCILLE H. CHUA, fuap, iep<br/>CITY ARCHITECT</p> | <p>RECOMMENDING APPROVAL:</p> <p>ARCH. LUCILLE H. CHUA, fuap, iep<br/>CITY ARCHITECT</p> | <p>APPROVED BY:</p> <p>HON. MA. JOSEFINA G. BELMONTE<br/>MAYOR</p> | <p>PROJECT TITLE:</p> <p>SUPPLY AND INSTALLATION OF MODULAR PARTITIONS INCLUDING FURNITURE AND OTHER WORKS FOR CITY CIVIL REGISTRY DEPARTMENT (CCRD) AT 2ND FLOOR, CIVIC CENTER BUILDING C</p> <p>LOCATION: QUEZON CITY HALL COMPOUND, BULACAN ROAD, QUEZON CITY</p> | <p>SHEET CONTENTS:</p> <p>SECOND FLOOR FURNITURE LAYOUT - CCRD</p> | <p>PROJECT NO.:</p> <p>DATE: March 2023<br/>DRAWN BY: K.C.M / A.R.B.D.B<br/>DESIGNED BY: A.R.B. (J.H.P.)<br/>CHECKED BY: A.R.B. G. Resurreccion</p> | <p>SHEET NO.:</p> <p><b>AR-01</b></p> |
|---------------------------------------------------------------------------------------------------------------------------------------------------------------------------------------|-------------------------------------------------------------------------------------------------------|------------------------------------------------------------------------------------------|--------------------------------------------------------------------|----------------------------------------------------------------------------------------------------------------------------------------------------------------------------------------------------------------------------------------------------------------------|--------------------------------------------------------------------|-----------------------------------------------------------------------------------------------------------------------------------------------------|---------------------------------------|

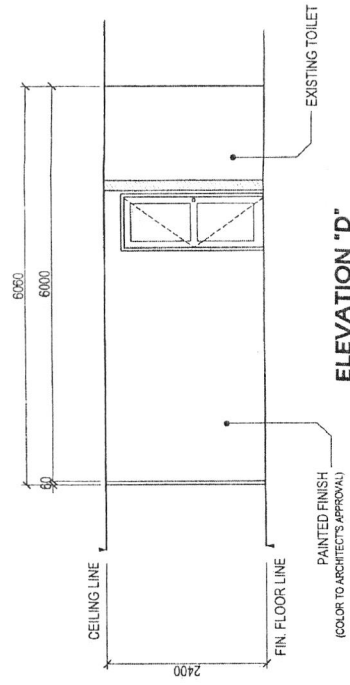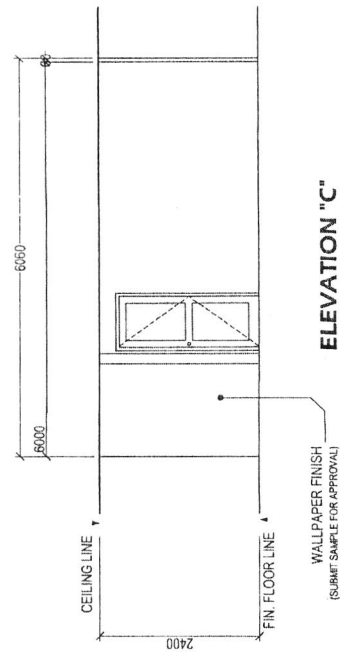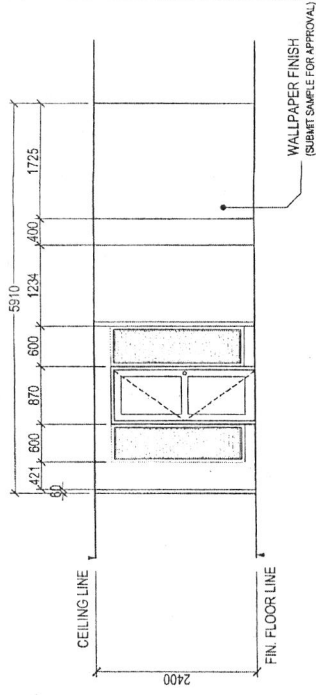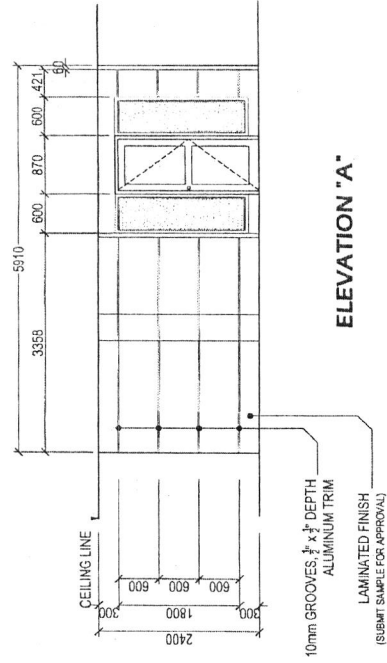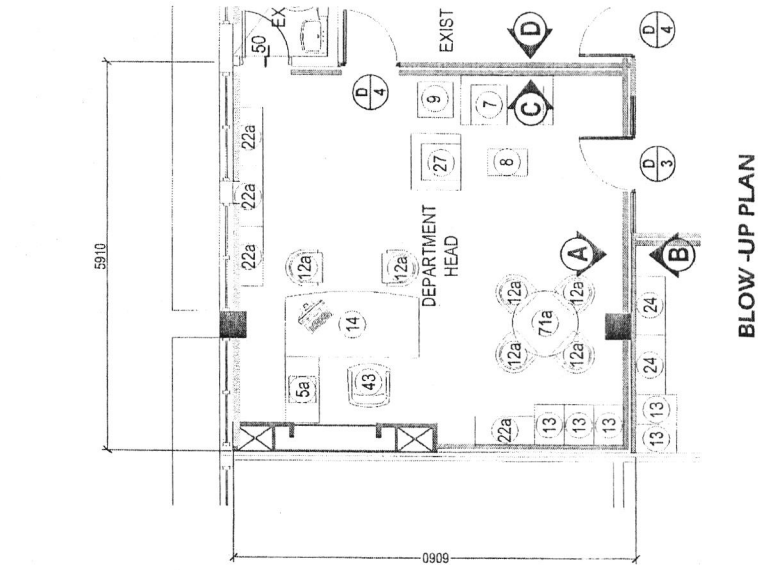


1 DETAIL OF CONFERENCE ROOM - SECOND FLOOR CCRD

SCALE 1:80 METERS

[illegible]

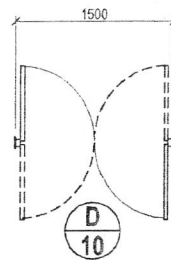


BLOW - UP PLAN

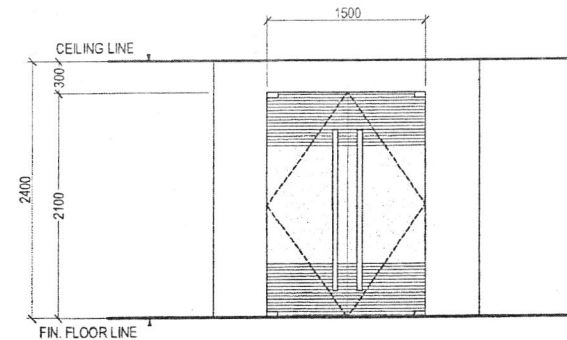


ELEVATION

## 1 TYPICAL DETAIL OF D10 DOOR


SCALE 1:50 METERS

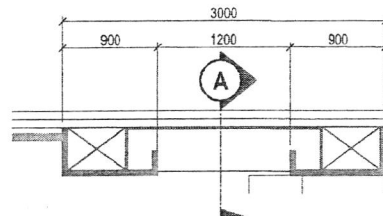

BLOW - UP PLAN

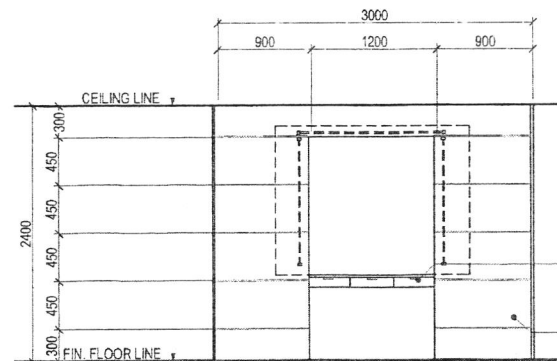

ELEVATION

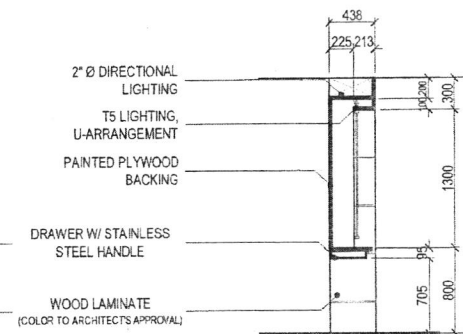


SECTION THRU "A"

## 2 TYPICAL DETAIL OF BACKWALL

SCALE 1:50 METERS

|                                                                                                                                                                                                                                                                          |                                                                                                                                                                                                                                                                                                                                                                                                                                                                                                     |                                                                                                                 |                                                                                            |                                                                                                                                                                                                                                                                                        |                                                                                                                                |                                                                                                                                       |                                       |
|--------------------------------------------------------------------------------------------------------------------------------------------------------------------------------------------------------------------------------------------------------------------------|-----------------------------------------------------------------------------------------------------------------------------------------------------------------------------------------------------------------------------------------------------------------------------------------------------------------------------------------------------------------------------------------------------------------------------------------------------------------------------------------------------|-----------------------------------------------------------------------------------------------------------------|--------------------------------------------------------------------------------------------|----------------------------------------------------------------------------------------------------------------------------------------------------------------------------------------------------------------------------------------------------------------------------------------|--------------------------------------------------------------------------------------------------------------------------------|---------------------------------------------------------------------------------------------------------------------------------------|---------------------------------------|
|  <p>Responsible Engineer<br/>Landscape Architect<br/><b>CITY ARCHITECT DEPARTMENT</b><br/>14 CIVIC CENTER - 6TH FLOOR, QUEZON CITY HALL COMPOUND<br/>ELLIPTICAL ROAD, QUEZON CITY</p> | <p>PROVIDE:</p> <p>THESE ARE THE SPECIFICATIONS FOR THE BACKWALL, STAFFED BY THE ARCHITECT, ENGINEER, AND LANDSCAPE ARCHITECT, AND THE CITY ARCHITECT DEPARTMENT. THE BACKWALL IS TO BE CONSTRUCTED IN ACCORDANCE WITH THE SPECIFICATIONS OF THE CITY ARCHITECT DEPARTMENT. THE BACKWALL IS TO BE CONSTRUCTED IN ACCORDANCE WITH THE SPECIFICATIONS OF THE CITY ARCHITECT DEPARTMENT. THE BACKWALL IS TO BE CONSTRUCTED IN ACCORDANCE WITH THE SPECIFICATIONS OF THE CITY ARCHITECT DEPARTMENT.</p> | <p>RECOMMENDING APPROVAL</p> <p><i>[Signature]</i><br/>ARCH. LUCILLE H. CHUA, Insp. piep<br/>CITY ARCHITECT</p> | <p>APPROVED BY:</p> <p><i>[Signature]</i><br/>HON. MA. JOSEFINA G. BELMONTE<br/>LAWYER</p> | <p>PROJECT TITLE:</p> <p>SUPPLY AND INSTALLATION OF MODULAR PARTITIONS INCLUDING FURNITURE AND OTHER WORKS FOR CITY CIVIL REGISTRY DEPARTMENT (CCRD) AT 2ND FLOOR, CIVIC CENTER BUILDING C</p> <p>LOCATION: QUEZON CITY HALL COMPOUND, ELLIPTICAL ROAD, ENCL. CENTRAL, QUEZON CITY</p> | <p>SHEET CONTENTS:</p> <p>TYPICAL DETAIL OF D10 DOOR - 2ND FLOOR, CCRD</p> <p>TYPICAL DETAIL OF BACKWALL - 2ND FLOOR, CCRD</p> | <p>PROJECT NO.:</p> <p>DATE: March 2023</p> <p>DRAWN BY: K.C.M./A.S.D.B.</p> <p>DESIGNED BY: A.T.R.B.</p> <p>CHECKED BY: A.T.R.B.</p> | <p>SHEET NO.:</p> <p><b>AR-04</b></p> |
|--------------------------------------------------------------------------------------------------------------------------------------------------------------------------------------------------------------------------------------------------------------------------|-----------------------------------------------------------------------------------------------------------------------------------------------------------------------------------------------------------------------------------------------------------------------------------------------------------------------------------------------------------------------------------------------------------------------------------------------------------------------------------------------------|-----------------------------------------------------------------------------------------------------------------|--------------------------------------------------------------------------------------------|----------------------------------------------------------------------------------------------------------------------------------------------------------------------------------------------------------------------------------------------------------------------------------------|--------------------------------------------------------------------------------------------------------------------------------|---------------------------------------------------------------------------------------------------------------------------------------|---------------------------------------|

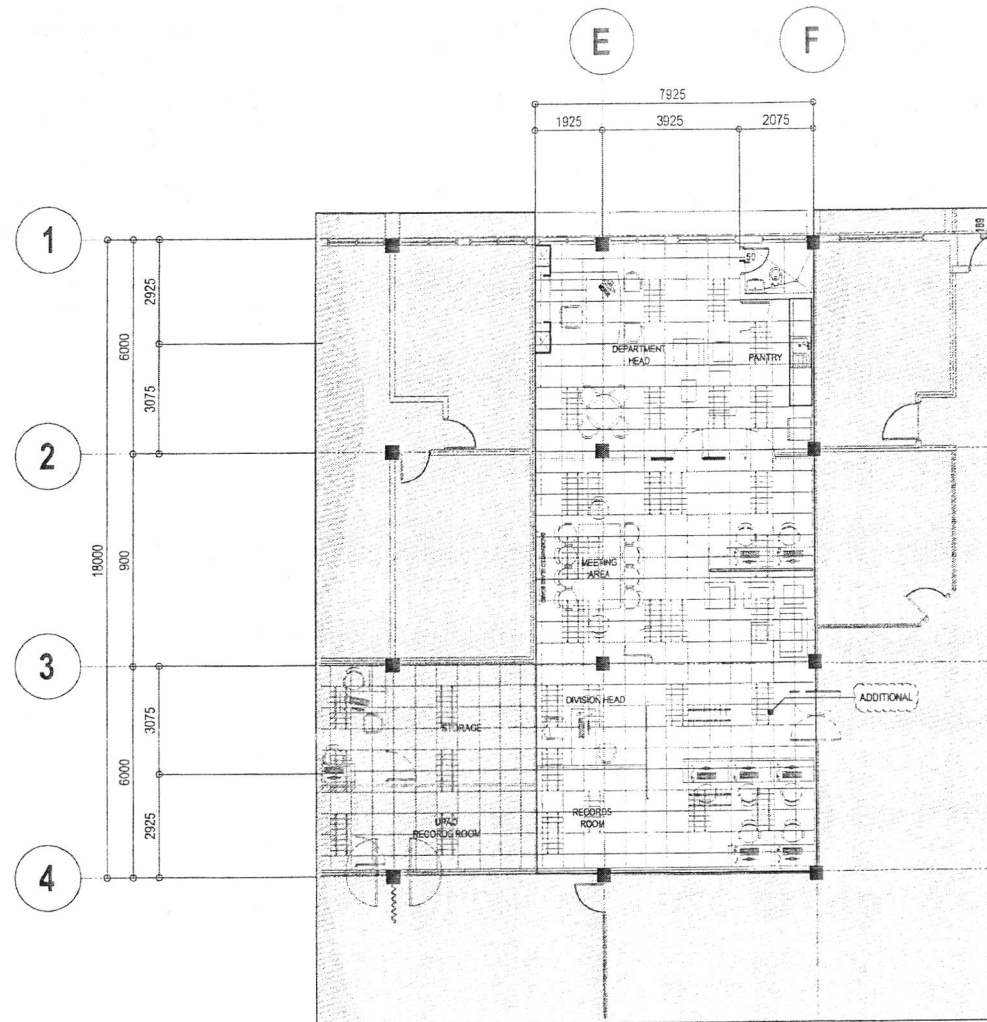

|                            |                                                                                                           |
|----------------------------|-----------------------------------------------------------------------------------------------------------|
|                            | 600mm x 1200mm SURFACE MOUNTED TROFFER TYPE LIGHTING FIXTURE WITH 2-18 Watts DAYLIGHT LED TUBE (NEW)      |
|                            | 600mm x 1200mm SURFACE MOUNTED TROFFER TYPE LIGHTING FIXTURE WITH 2-18 Watts DAYLIGHT LED TUBE (EXISTING) |
| <b>LEGENDS AND SYMBOLS</b> |                                                                                                           |

# 1 SECOND FLOOR EXISTING LIGHTING LAYOUT

SCALE 1:150 METERS

|                                                                                                                                                                                                 |                                                                                                                                                                                                                                                                                                                                                                                                         |                                                                                                     |                                                                               |                                                                                                                                                                                                                                                                                  |                                                                     |                                                                                                                                               |                                       |
|-------------------------------------------------------------------------------------------------------------------------------------------------------------------------------------------------|---------------------------------------------------------------------------------------------------------------------------------------------------------------------------------------------------------------------------------------------------------------------------------------------------------------------------------------------------------------------------------------------------------|-----------------------------------------------------------------------------------------------------|-------------------------------------------------------------------------------|----------------------------------------------------------------------------------------------------------------------------------------------------------------------------------------------------------------------------------------------------------------------------------|---------------------------------------------------------------------|-----------------------------------------------------------------------------------------------------------------------------------------------|---------------------------------------|
| <p>Republic of the Philippines<br/>Lungsod ng Quezon<br/><b>CITY ARCHITECT DEPARTMENT</b><br/>11 CIVIC CENTER, 3RD FLOOR, QUEZON CITY HALL COMPOUND,<br/>ELIPIDAL ROAD, DENZAN, QUEZON CITY</p> | <p>PROVISO</p> <p>THESE ARE THE EXISTING CONDITIONS OF THE BUILDING, AS SHOWN BY THE ATTACHED PHOTOGRAPHS AND MEASUREMENTS. ANY CHANGES TO THE EXISTING CONDITIONS SHALL BE INDICATED BY A DASHED LINE AND Labeled WITH A NUMBER IN THE MARGINS OF THE DRAWING. ANY CHANGES TO THE EXISTING CONDITIONS SHALL BE INDICATED BY A DASHED LINE AND Labeled WITH A NUMBER IN THE MARGINS OF THE DRAWING.</p> | <p>RECOMMENDING APPROVAL</p> <p></p> <p>ARCH. LUELLE H. CHUA, IUPAP, ILEP</p> <p>CITY ARCHITECT</p> | <p>APPROVED BY:</p> <p></p> <p>HON. MA. JOSEFINA G. BELMONTE</p> <p>MAYOR</p> | <p>PROJECT TITLE:</p> <p>SUPPLY AND INSTALLATION OF MODULAR PARTITIONS INCLUDING FURNITURE AND OTHER WORKS FOR CITY CIVIL REGISTRY DEPARTMENT (CCRD) AT 2ND FLOOR, CIVIC CENTER BUILDING C</p> <p>LOCATION: QUEZON CITY HALL COMPOUND, ELIPIDAL ROAD, 3RD FLOOR, QUEZON CITY</p> | <p>SHEET CONTENTS:</p> <p>SECOND FLOOR EXISTING LIGHTING LAYOUT</p> | <p>PROJECT NO.:</p> <p>DATE: March 2023</p> <p>DRAWN BY: A.R.D.B.</p> <p>DESIGNED BY: Engr. R.O.T. Jr.</p> <p>CHECKED BY: T.B. Tugade Jr.</p> | <p>SHEET NO.:</p> <p><b>EL-01</b></p> |
|-------------------------------------------------------------------------------------------------------------------------------------------------------------------------------------------------|---------------------------------------------------------------------------------------------------------------------------------------------------------------------------------------------------------------------------------------------------------------------------------------------------------------------------------------------------------------------------------------------------------|-----------------------------------------------------------------------------------------------------|-------------------------------------------------------------------------------|----------------------------------------------------------------------------------------------------------------------------------------------------------------------------------------------------------------------------------------------------------------------------------|---------------------------------------------------------------------|-----------------------------------------------------------------------------------------------------------------------------------------------|---------------------------------------|





