



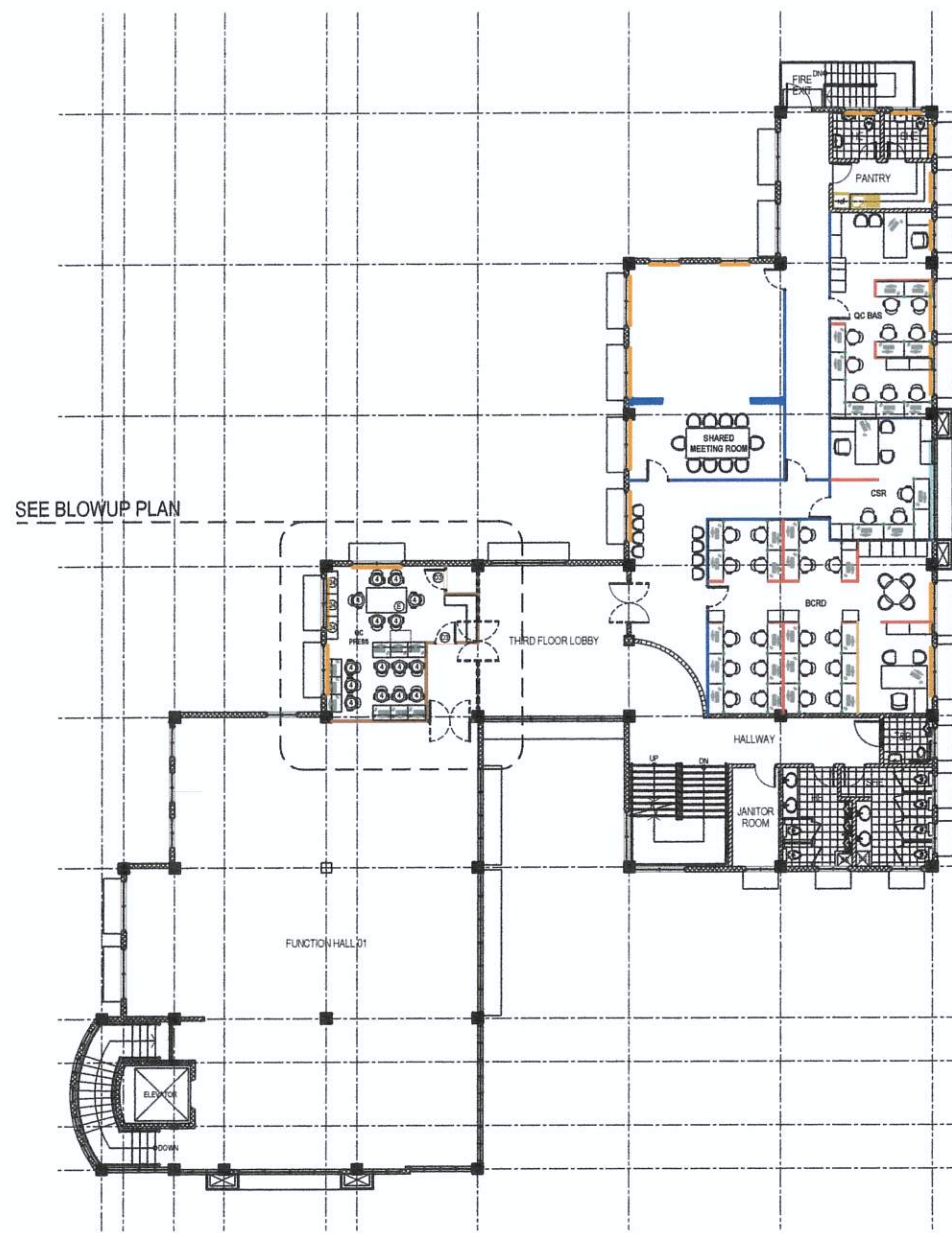

KEY PLAN
(3RD FLOOR COMMUNITY CENTER BLDG.)

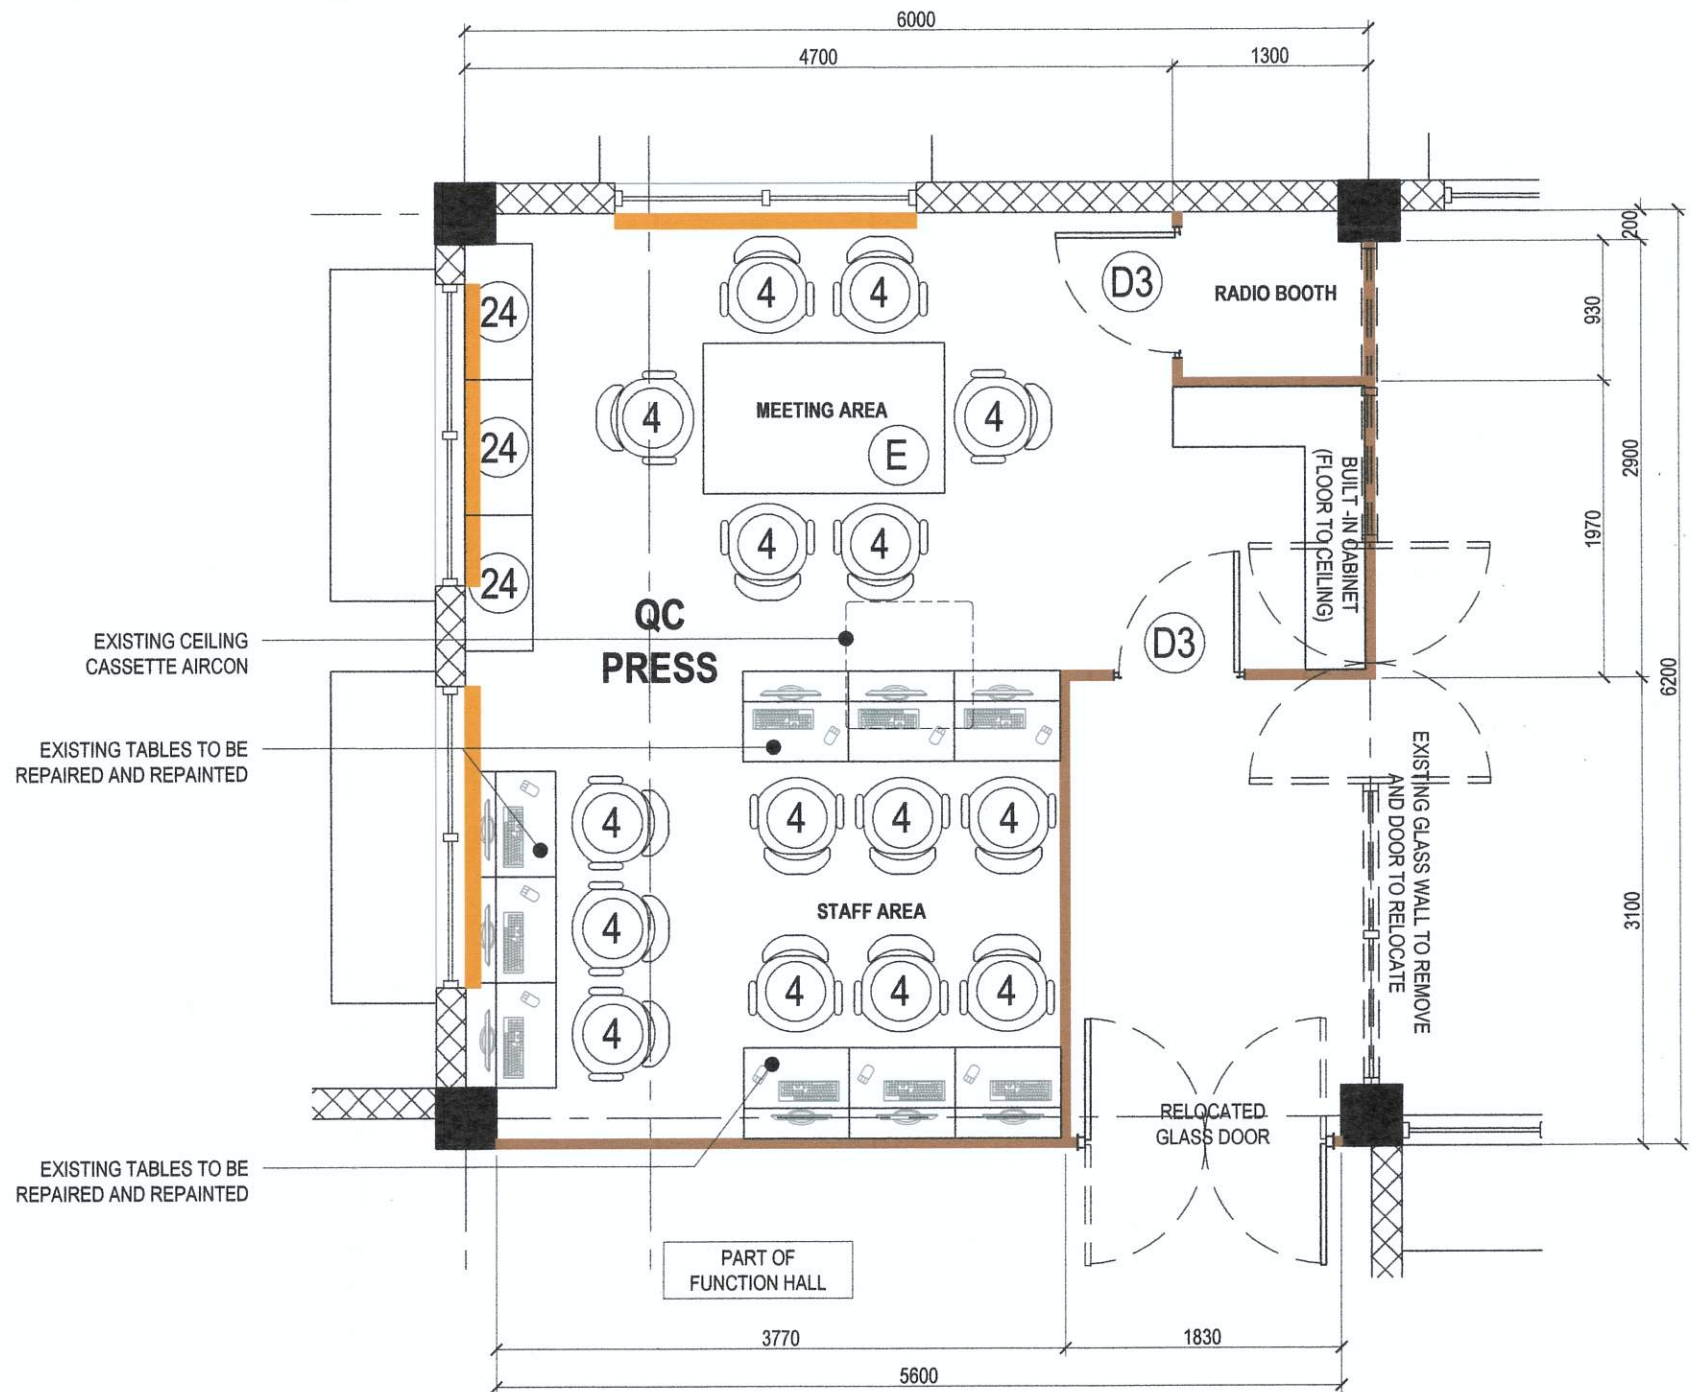


APPROVED BY :	DATE :	LEGEND:	FURNITURE:
 MS. ROWENA T. MACATAO CHIEF OF STAFF - OCM		ROLLER SHADES (SUNSCREEN) DRY WALL PARTITION, PAINTED (BOTH SIDES)	(D3) PANEL DOOR WITH HALF GLASS, WITH LAMINATE FINISH , 0.8m X 2.10mH (4) STAFF CHAIR
			(24) STEEL LATERAL FILING CABINET - 3 DRAWERS (E) EXISTING TABLE (TO BE REPAIRED / REPAINTED)


1 QC PRESS BLOW-UP PLAN

SCALE 1:50 METERS

	Republika ng Pilipinas Lungsod ng Quezon CITY ARCHITECT DEPARTMENT SF CIVIC CENTER - D (BRO. BANG), QUEZON CITY HALL COMPOUND, ELLIPTICAL ROAD, DILIMAN, QUEZON CITY		PROVISO:	RECOMMENDING APPROVAL	APPROVED BY:	PROJECT TITLE:	SHEET CONTENTS :	PROJECT NO.:	SHEET NO.:
			DRAWINGS AND SPECIFICATIONS DULY SIGNED, STAMPED OR SEALED AS INSTRUMENTS OF SERVICE ARE THE INTELLECTUAL PROPERTIES & DOCUMENTS OF THE CITY ARCHITECTS DEPARTMENT. WHETHER THE OBJECT FOR WHICH THEY ARE MADE IS EXECUTED OR NOT, IT SHALL BE UNLAWFUL FOR ANY PERSON, WITHOUT THE CONSENT OF THE AUTHOR OF SAID DOCUMENTS TO DUPLICATE OR TO MAKE COPIES OF SAID DOCUMENTS FOR USE IN THE REPRODUCTION OF AND FOR OTHER PROJECTS OR BUILDINGS, WHETHER EXECUTED PARTLY OR IN WHOLE.	 AR. LUCILLE H. CHUA, fuap, piep CITY ARCHITECT	 HON. MA. JOSEFINA G. BELMONTE MAYOR	PROPOSED QC PRESS OFFICE AT THIRD FLOOR COMMUNITY CENTER BUILDING	QC PRESS BLOW-UP PLAN		
						LOCATION : CITY HALL COMPOUND, BROY. CENTRAL, DILIMAN, QUEZON CITY		DATE : May 2022 DRAWN BY : Ar. J.U.C DESIGNED BY : Ar. J.U.C CHECKED BY : Ar. R. G. Resurreccion	AR

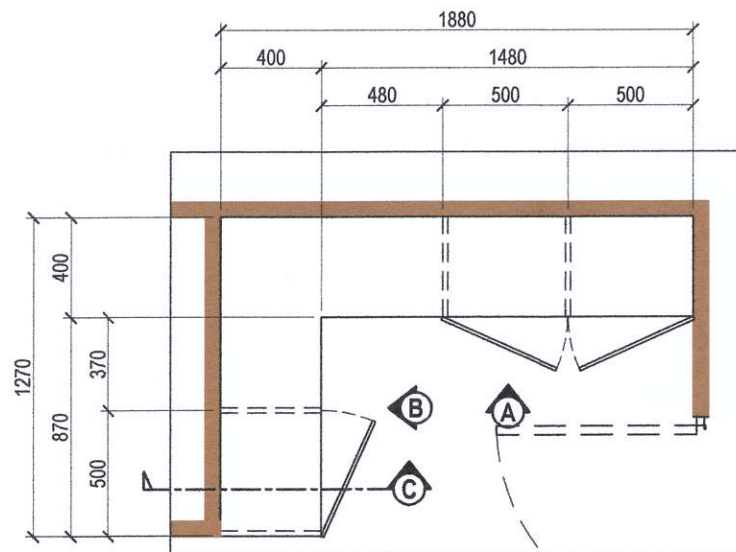

PLAN

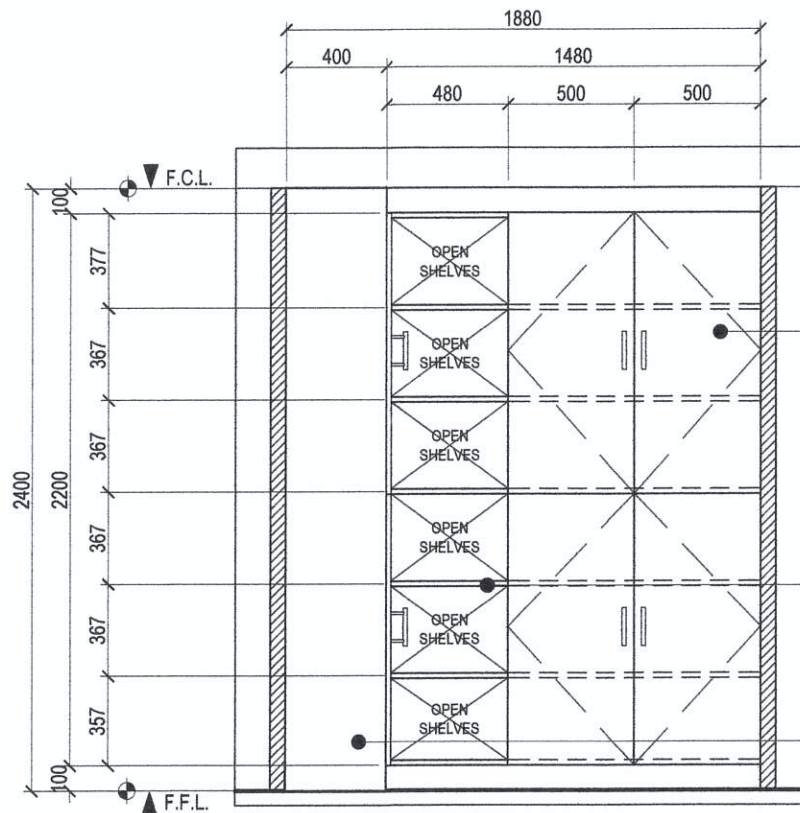


ELEVATION 'A'

20mm THICK PLYBOARD
CABINET DOOR WITH SOLID
WOOD EDGING, PAINTED FINISH
(color for architect's approval)

20mm THICK PLYBOARD FIXED
SHELF WITH 2" X 2" SOLID WOOD
EDGING, PAINTED FINISH
(color for architect's approval)

20mm THICK PLYBOARD,
PAINTED FINISH
(color for architect's approval)

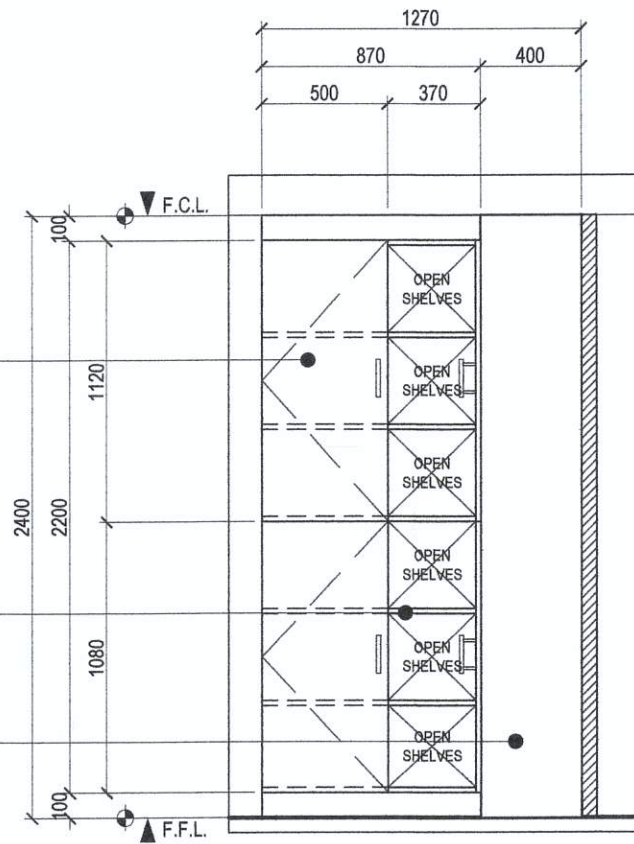

ELEVATION 'B'


2" X 4" SOLID WOOD VERTICAL
FRAMES, PAINTED FINISH (color for
architect's approval)

20mm THICK PLYBOARD CABINET
DOOR WITH SOLID WOOD EDGING,
PAINTED FINISH (color for architect's
approval)

2" X 3" SOLID WOOD VERTICAL
FRAMES, PAINTED FINISH (color for
architect's approval)

20mm THICK PLYBOARD FIXED SHELF
WITH 2" X 2" SOLID WOOD EDGING,
PAINTED FINISH (color for architect's
approval)

2" X 4" SOLID WOOD VERTICAL
FRAMES, PAINTED FINISH (color for
architect's approval)

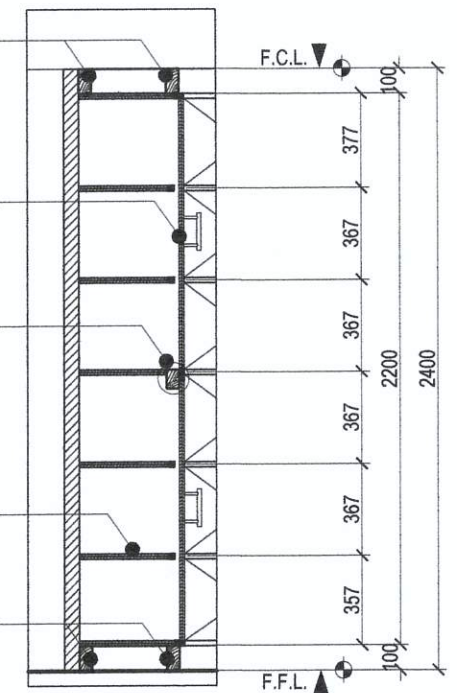


SECTION 'C'

1 BUILT-IN CABINET DETAIL

SCALE 1:50 METERS

 Republika ng Pilipinas Lungsod ng Quezon CITY ARCHITECT DEPARTMENT 5F CIVIC CENTER - D Bldg., QUEZON CITY HALL COMPOUND, ELLIPTICAL ROAD, DILIMAN, QUEZON CITY 	PROVISO: DRAWINGS AND SPECIFICATIONS DULY SIGNED, STAMPED OR SEALED AS INSTRUMENTS OF SERVICE ARE THE INTELLECTUAL PROPERTIES & DOCUMENTS OF THE CITY ARCHITECTS DEPARTMENT. WHETHER THE OBJECT FOR WHICH THEY ARE MADE IS EXISTING OR NOT, IT SHALL BE BINDING FOR ANY PERSON, WITHOUT THE CONSENT OF THE AUTHOR OF SAID DOCUMENTS TO DUPLICATE OR TO MAKE COPIES OF SAID DOCUMENTS FOR USE IN THE REDEMPTION OF LANDS FOR OTHER PROJECTS OR BUILDINGS, WHETHER EXECUTED PARTLY OR IN WHOLE.	RECOMMENDING APPROVAL  AR. LUCILLE H. CHUA, fuap, piep CITY ARCHITECT	APPROVED BY:  HON.MA. JOSEFINA G. BELMONTE MAYOR C.C.	PROJECT TITLE : PROPOSED QC PRESS OFFICE AT THIRD FLOOR COMMUNITY CENTER BUILDING LOCATION : CITY HALL COMPOUND, Bldg. CENTRAL, DILIMAN, QUEZON CITY	SHEET CONTENTS :	PROJECT NO. : <table><tr><td>DATE</td><td>May 2022</td></tr><tr><td>DRAWN BY</td><td>Ar. J.U.C</td></tr><tr><td>DESIGNED BY</td><td>Ar. J.U.C</td></tr><tr><td>CHECKED BY</td><td>Ar. R. G. Resurreccion</td></tr></table>	DATE	May 2022	DRAWN BY	Ar. J.U.C	DESIGNED BY	Ar. J.U.C	CHECKED BY	Ar. R. G. Resurreccion	SHEET NO. : AR
	DATE	May 2022													
DRAWN BY	Ar. J.U.C														
DESIGNED BY	Ar. J.U.C														
CHECKED BY	Ar. R. G. Resurreccion														

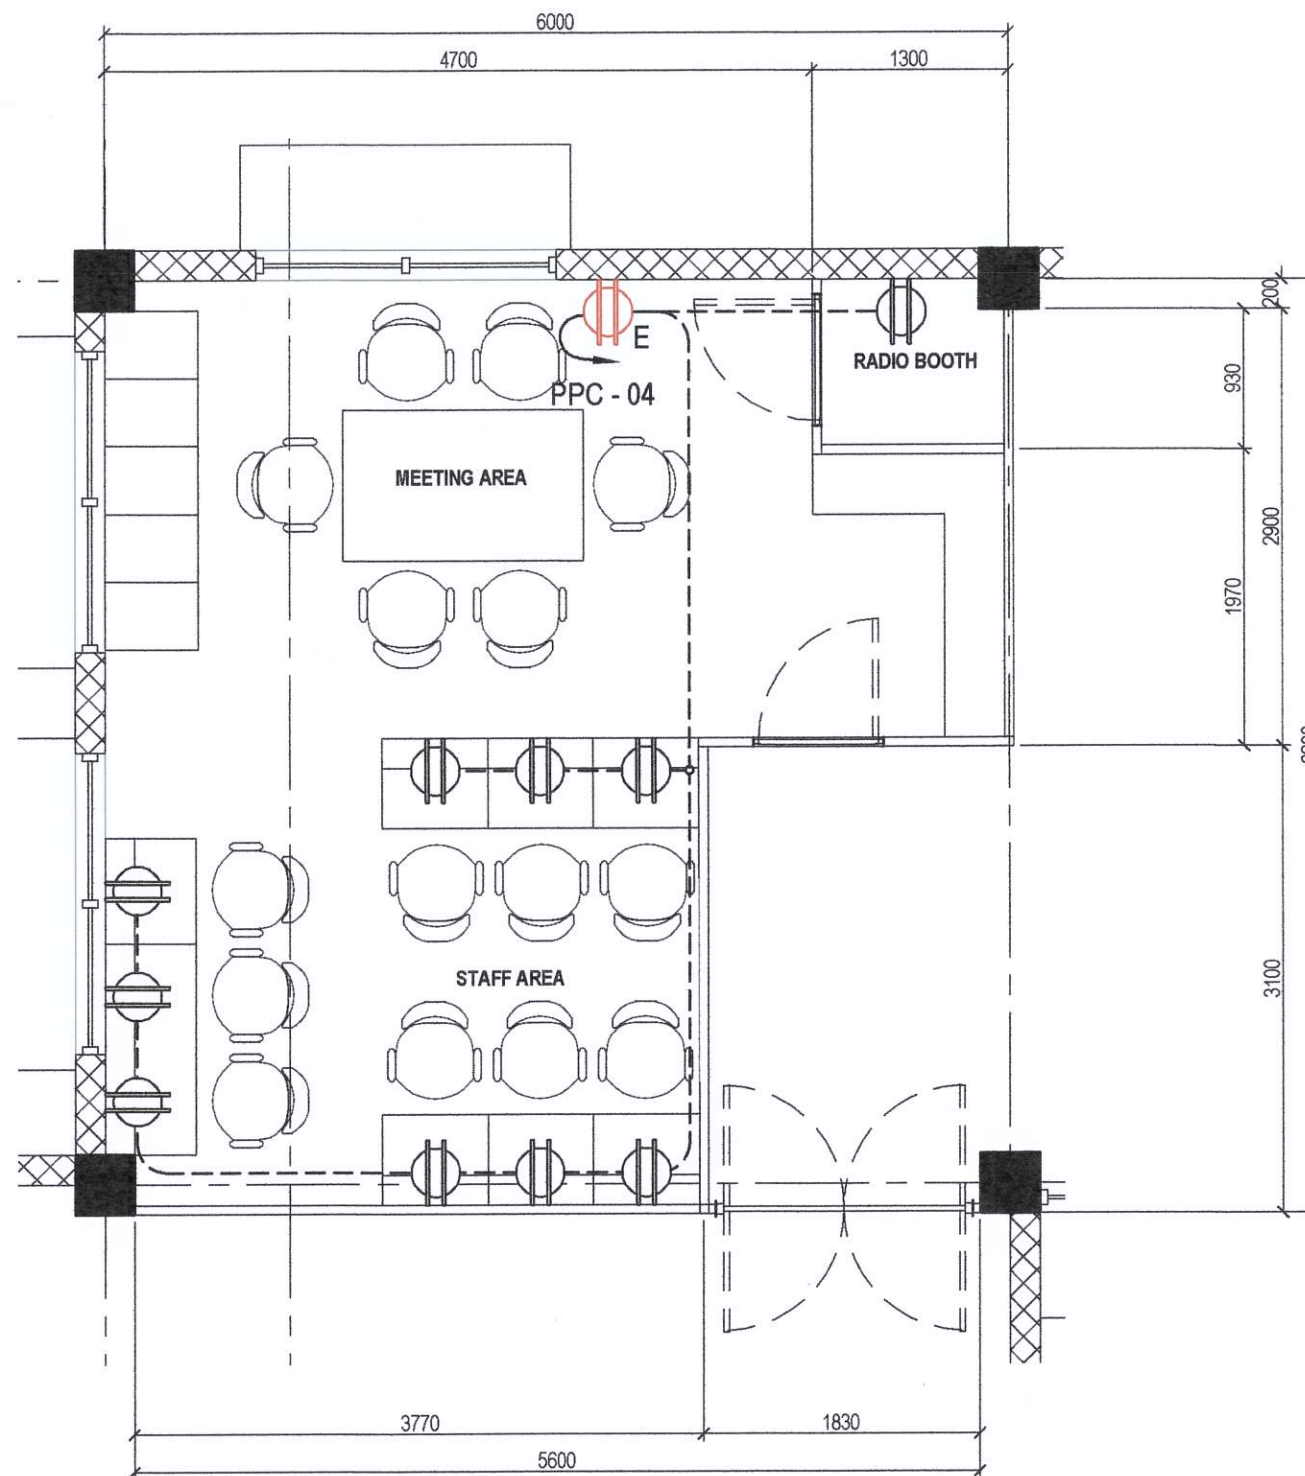



LEGENDS AND SYMBOLS:

- 2-GANG CONVENIENCE OUTLET (EXISTING)
- 2-GANG CONVENIENCE OUTLET (UNIVERSAL TYPE)
- POWER CIRCUIT LINE
- CIRCUIT HOME RUN

1 POWER LAYOUT

 SCALE 1:50 METERS

 Republika ng Pilipinas Lungsod ng Quezon CITY ARCHITECT DEPARTMENT 6F CIVIC CENTER - D (PRO. Bldg.), QUEZON CITY HALL COMPOUND, ELLIPTICAL ROAD, DILIMAN, QUEZON CITY	PROVISO: DRAWINGS AND SPECIFICATIONS DULY SIGNED, STAMPED OR SEALED AS INSTRUMENTS OF SERVICE ARE THE INTELLECTUAL PROPERTY AND DOCUMENTS OF THE CITY ARCHITECT'S DEPARTMENT. WHETHER THE OBJECT FOR WHICH THEY ARE MADE IS EXECUTED OR NOT, IT SHALL BE UNLAWFUL FOR ANY PERSON, WITHOUT THE CONSENT OF THE AUTHOR OF SAID DOCUMENTS TO DUPLICATE OR TO MAKE COPIES OF SAID DOCUMENTS FOR USE IN THE REPRODUCTION OF AND FOR OTHER PROJECTS OR BUILDINGS, WHETHER EXECUTED PARTLY OR IN WHOLE.	RECOMMENDING APPROVAL  AR. LUCILLE H. CHUA, fuap, piep CITY ARCHITECT	APPROVED BY:  HON. MA. JOSEFINA G. BELMONTE MAYOR	PROJECT TITLE: PROPOSED QC PRESS OFFICE AT THIRD FLOOR COMMUNITY CENTER BUILDING LOCATION: CITY HALL COMPOUND, DIST. CENTRAL, DILIMAN, QUEZON CITY	SHEET CONTENTS: QC PRESS POWER LAYOUT	PROJECT NO.: SHEET NO.: EL-01 DATE: May 2022 DRAWN BY: Ar. J.U.C. DESIGNED BY: Engr. ERS CHECKED BY: Engr. T.B. Infante Jr.
---	---	---	---	--	---	--

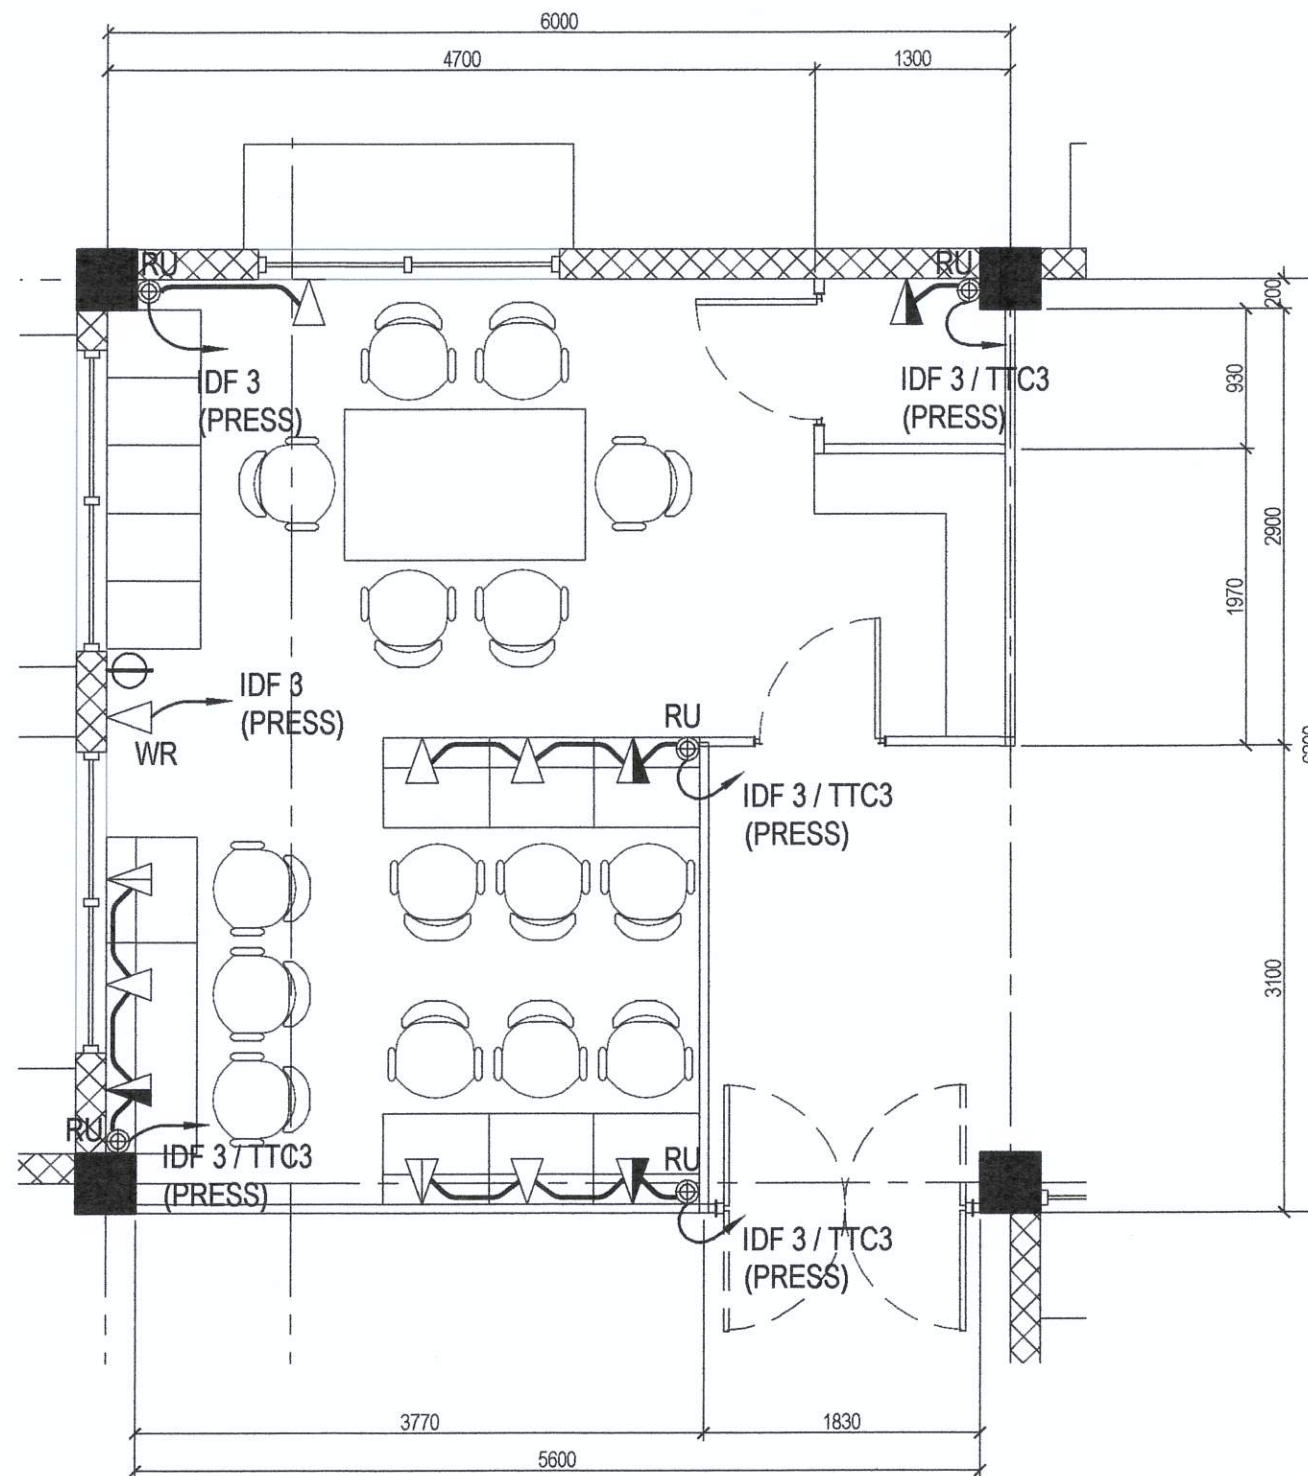

LEGENDS AND SYMBOLS:

- LIGHTING CIRCUIT LINE
- RU RISER UP
- WR SIMPLEX OUTLET FOR WIRELESS ACCESS DEVICE
- ▽ SIMPLEX DATA OUTLET, 1-DEVICE
- ▽ DUPLEX DATA OUTLET, 2-DEVICE
- ▽ DUPLEX VOICE & DATA OUTLET, 2-DEVICE
- Φ SINGLE C.O. (TAPPED TO NEAREST L.O.)

1 VOICE AND DATA LAYOUT

SCALE 1:50 METERS

Republika ng Pilipinas Lungsod ng Quezon CITY ARCHITECT DEPARTMENT 6F CHC CENTER - D (RND. Bldg.) QUEZON CITY HALL COMPOUND, ELLIPTICAL ROAD, DILIMAN, QUEZON CITY	PROVISO: DRAWINGS AND SPECIFICATIONS DULY SIGNED, STAMPED OR SEALED AS INSTRUMENTS OF SERVICE ARE THE INTELLECTUAL PROPERTY & DOCUMENTS OF THE CITY ARCHITECT'S DEPARTMENT. WHETHER THE OBJECT FOR WHICH THEY ARE MADE IS EXECUTED OR NOT, IT SHALL BE UNLAWFUL FOR ANY PERSON WITHOUT THE CONSENT OF THE AUTHOR OF SAID DOCUMENTS TO DUPLICATE OR TO MAKE COPIES OF SAID DOCUMENTS FOR USE IN THE REPRODUCTION OF AND FOR OTHER PROJECTS OR BUILDINGS, WHETHER EXECUTED PARTLY OR IN WHOLE.	RECOMMENDING APPROVAL <i>[Signature]</i> AR. LUCILLE H. CHUA, fuap, piep CITY ARCHITECT	APPROVED BY: <i>[Signature]</i> HON. MA. JOSEFINA G. BELMONTE MAYOR	PROJECT TITLE: PROPOSED QC PRESS OFFICE AT THIRD FLOOR COMMUNITY CENTER BUILDING LOCATION: CITY HALL COMPOUND, BRGY. CENTRAL, DILIMAN, QUEZON CITY	SHEET CONTENTS: QC PRESS VOICE AND DATA LAYOUT	PROJECT NO.: DATE: May 2022 DRAWN BY: Ar. J.U.C. DESIGNED BY: Engr. ARG-I. Engr. ERS CHECKED BY: Engr. T.B. Infante Jr.	SHEET NO.: EL-02