



1 PERSPECTIVES

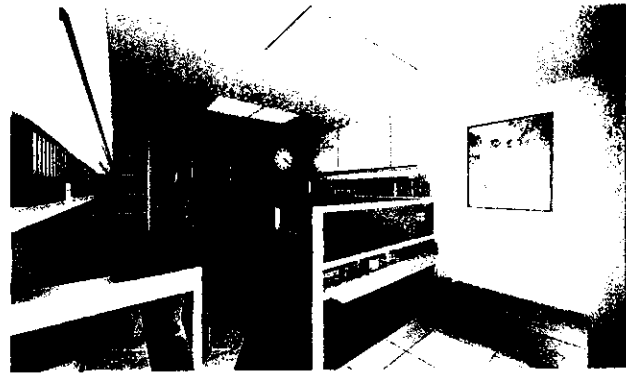

Republic of the Philippines
 City Architect Department
 3F ONE CENTER - 3 Bldg. 188, QUEZON CITY MALL COMPOUND,
 ELIPSAZ ROAD, QUEZON CITY

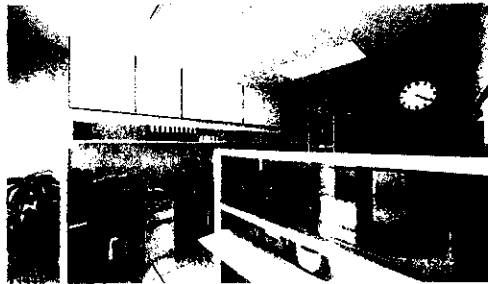

PROVISION:
 The City Architect shall be responsible for the design and construction of all buildings and structures within the City of Quezon City, and shall be responsible for the design and construction of all buildings and structures within the City of Quezon City, and shall be responsible for the design and construction of all buildings and structures within the City of Quezon City.

RECOMMENDING APPROVAL
 AR. LOUISE H. CHUA, Aisp. plep
 CITY ARCHITECT


APPROVED BY:
 HON. GIAN CARLO G. SOTTO
 VICE MAYOR

PROJECT TITLE:
 SUPPLY AND INSTALLATION OF LOW PARTITIONS
 INCLUDING FURNITURE AND OTHER WORKS FOR
 QC SPORTS DEVELOPMENT OFFICE
 AT LEGISLATIVE BUILDING
 LOCATION: ROOM 201, 2ND FLOOR, LEGISLATIVE BUILDING, QUEZON CITY

SHEET CONTENTS:
 PERSPECTIVES

PROJECT NO.:
 DATE: March 2024
 DRAWN BY: J. S. SOTTO, AIA, C.A.M.
 DESIGNED BY: J. S. SOTTO, AIA, C.A.M.
 CHECKED BY: J. S. SOTTO, AIA, C.A.M.

SHEET NO.:
 AR-01

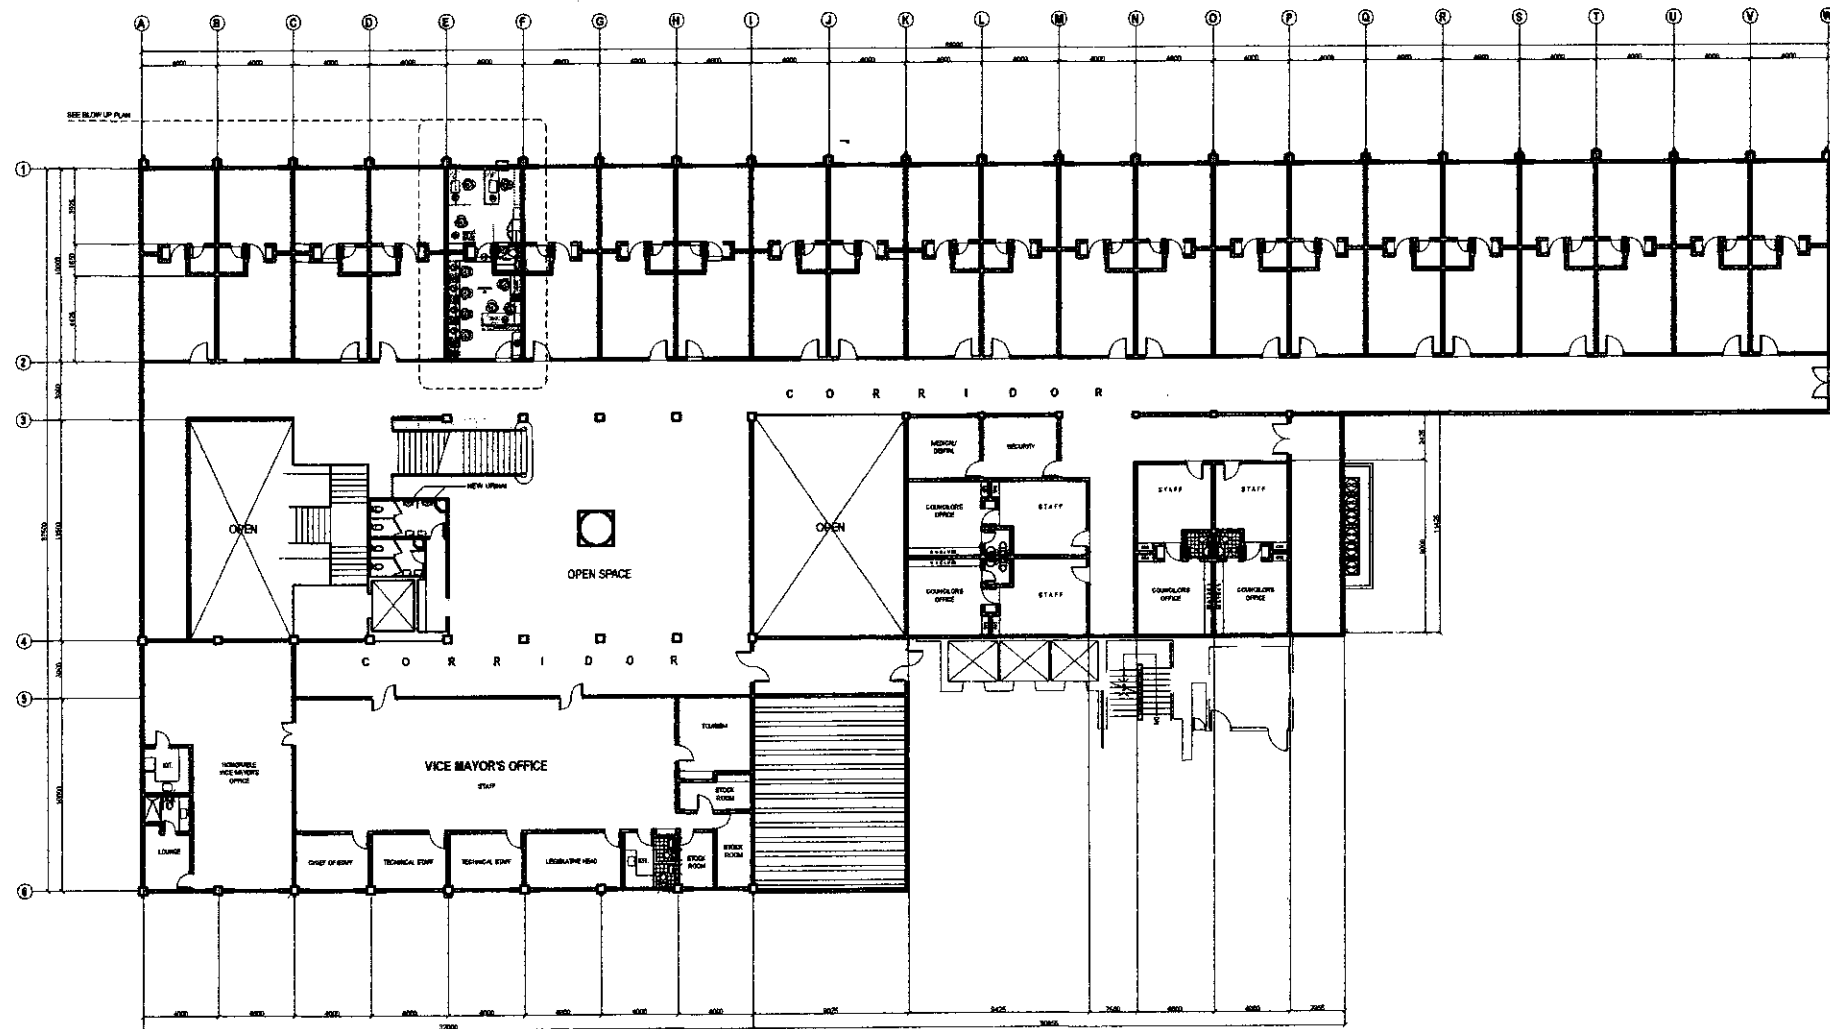

1 SECOND FLOOR PLAN (LEGISLATIVE)


SCALE 1:150 METERS (20 x 30)
SCALE 1:300 METERS(A3)

Republic of the Philippines Lungsod ng Quezon CITY ARCHITECT DEPARTMENT OF QUEZON CITY - 9 (P.O. BOX 100) QUEZON CITY HALL COMPOUND, BULACAN RD., QUEZON CITY	PROVISO: DESIGNER'S RESPONSIBILITY: The Designer shall be responsible for the accuracy of the design and for the proper use of the design. The Designer shall not be responsible for the construction of the design.	RECOMMENDING APPROVAL <i>[Signature]</i> AR. LUCILLE H. CHUA, RUP, PLP CITY ARCHITECT	APPROVED BY: <i>[Signature]</i> HON. GIAN CARLO G. SOTTO VICE MAYOR	PROJECT TITLE: SUPPLY AND INSTALLATION OF LOW PARTITIONS INCLUDING FURNITURE AND OTHER WORKS FOR OC SPORTS DEVELOPMENT OFFICE AT LEGISLATIVE BUILDING	SHEET CONTENTS: SECOND FLOOR PLAN (LEGISLATIVE)	PROJECT NO.:		SHEET NO.: AR-02
						DATE: DESIGNED BY: AN. ELMER AN. KCM CHECKED BY: AN. R.G. De Jesus	DATE: DESIGNED BY: AN. ELMER AN. KCM CHECKED BY: AN. R.G. De Jesus	

[illegible]

1. ALL ELECTRICAL INSTALLATION WORKS HEREIN SHALL BE DONE IN ACCORDANCE WITH THESE PLANS AND SPECIFICATIONS. THE APPLICABLE PROVISIONS OF THE LATEST EDITION OF THE PHILIPPINE ELECTRICAL CODE, THE RULES AND REGULATIONS OF THE LOCAL ENFORCING AUTHORITY, AND THE REQUIREMENTS OF THE LOCAL POWER AND TELEPHONE COMPANIES.
2. THE ELECTRICAL WORKS SHALL BE UNDER THE IMMEDIATE SUPERVISION OF A DULY LICENSED ELECTRICAL ENGINEER DEDICATED SOLELY TO THE PROJECT.
3. THE ELECTRIC SERVICE ENTRANCE SHALL BE THREE (3) PHASE SYSTEM WITH 3 WIRES AND GROUND, 220 VOLTS, 60HZ. THE CONTRACTOR SHALL VERIFY AND ORIENT THE ACTUAL LOCATION OF SERVICE ENTRANCE POWER SUPPLY WITH COORDINATION WITH THE UTILITY COMPANY.
4. THE ELECTRICAL WIRING INSTALLATION SHALL BE DONE IN INTERMEDIATE METALLIC CONDUIT (IMC) AND ELECTRICAL METALLIC TUBING (EMT) FOR ALL EXPOSED INSTALLATIONS. POLYVINYL CHLORIDE (PVC) SHALL BE USED FOR ALL EMBEDDED INSTALLATIONS. FLEXIBLE METALLIC CONDUIT SHALL BE USED WHERE REQUIRED.
5. THE MINIMUM SIZE FOR ALL CONDUIT SHALL BE 15MM NOMINAL INSIDE DIAMETER ELECTRICAL TRADE SIZE, FOR PVC CONDUIT USED, IT SHALL BE SCHEDULE 40.
6. ALL WIRES SHALL BE COPPER, TYPE 'THW', 'THHN' OR 'THWN' SHALL BE USED. THE MINIMUM SIZE OF WIRE FOR LIGHTING AND POWER SHALL BE 3.5MM², THERMOPLASTIC TYPE @ 600V INSULATION WITH 98% CONDUCTIVITY.
7. ALL EQUIPMENT, LIGHTING FIXTURES, WIRING DEVICES, PANELBOARDS, AND ALL NON-CURRENT CARRYING METAL PARTS SHALL BE PROPERLY GROUNDED IN ACCORDANCE WITH THE LATEST EDITION OF THE PHILIPPINE ELECTRICAL CODE.
8. ALL PIPE SLEEVES SHALL BE PROVIDED WITH PROPER SUPPORT OR ANCHORAGE NECESSARY FOR PERMANENT CONNECTION WITH CONCRETE WALL OR BEAM. PROVIDE PULL WIRES IN ALL SPARE DUCT AND EMPTY CONDUIT. PROVIDE PULLBOXES WHENEVER NECESSARY EVEN NOT INDICATED IN PLANS.
9. UTILIZED RECESSED LIGHTING FIXTURES FOR SPACES WITH CEILINGS, AND USE SURFACE MOUNTED FIXTURE WHEN THERE IS NO CEILING OR IN SLAB INSTALLATIONS. ALL LIGHTING FIXTURES AND WIRING DEVICES SHALL BE FOR ENGINEERS / ARCHITECTS APPROVAL. SUBMIT SAMPLES.



 
10. ALL CIRCUIT BREAKERS SHALL BE BOLT-ON TYPE WITH INTERRUPTING CAPACITY AS INDICATED IN THE PLANS. PANELBOARDS AND WIREWAYS SHALL BE GALVANIZED SHEET POWDER COATED GAUGE 16 MINIMUM.
11. FEEDER AND BRANCH CIRCUIT CONDUCTORS IN CABLE TRAYS SHALL BE GROUPED, BONDED AND TAGGED TO INDICATE CLEARLY THE ELECTRICAL CHARACTERISTICS, SUCH AS CIRCUIT NUMBER AND PANEL DESIGNATION.
12. ANY DISCREPANCY IN LOCATION AND RATINGS OF EQUIPMENT AND OTHERS SHALL BE VERIFIED WITH THE OWNER OR ANY OF HIS REPRESENTATIVES, CHANGES SHALL BE MADE ACCORDINGLY. FOR EXACT LOCATION AND RATINGS OF MECHANICAL EQUIPMENT, REFER TO MECHANICAL DRAWINGS.
13. ALL MATERIALS TO BE USED AND EQUIPMENT TO BE INSTALLED SHALL BE BRAND NEW, MUST BE OF THE APPROVED TYPE FOR THE PARTICULAR LOCATION AND PURPOSE INTENDED. ALL EQUIPMENT SHALL BE PROPERLY GROUNDED. SUBMIT SAMPLES FOR ENGINEERS/ARCHITECTS APPROVAL.
14. MOUNTING HEIGHTS HERE UNDER SHALL AS FOLLOWS:
1.40M CENTER OF PANELBOARD ABOVE FLOOR FINISH
0.30M CONVENIENCE OUTLET ABOVE FLOOR FINISH
0.30M TELEPHONE/TV CABLE OUTLET ABOVE FLOOR FINISH
0.15M COUNTERTOP OUTLET ABOVE THE SINK / TABLE
1.20M CENTER OF SWITCH ABOVE FLOOR FINISH
0.15M WATER HEATER OUTLET BELOW CEILING LINE
15. THE GENERATOR SET SHALL ENCOMPASS ALL ACCESSORIES, SUCH AS THE MUFFLER, ALTERNATOR, BATTERY, RUBBER DAMPER, ETC. IT SHALL BE INSTALLED ON A CONCRETE PAD AND SECURELY BOLTED. THE CONTRACTOR IS REQUIRED TO SUBMIT DRAWINGS FOR APPROVAL.



S / S1

Sub / S2

   Sabc / S3



LIGHTING AND POWER PANEL BOARD

COVE LIGHT (YELLOW and/or WHITE)

600mm x 1200mm SURFACE MOUNTED TROFFER TYPE LIGHTING FIXTURE WITH 2 - 18 Watts DAYLIGHT LED TUBE

6" Ø PINLIGHT LIGHTING FIXTURE

CEILING MOUNTED EXHAUST FAN

SWITCH LOCATION

SINGLE POLE SWITCH

TWO GANG SWITCH (2-Single Switch in 1 Switch Plate)

THREE GANG SWITCH (3-Single Switch in 1 Switch Plate)

ENCLOSED CIRCUIT BREAKER

CIRCUIT HOME RUN

LIGHTING CIRCUIT LINE

SWITCH LINE

EXISTING POWER CIRCUIT LINE

NEW POWER CIRCUIT LINE

EXISTING CONVENIENCE OUTLET

NEW CONVENIENCE OUTLET, COUNTER HEIGHT

SPECIAL OUTLET FOR AIR-CONDITIONING UNIT

1 GENERAL NOTES

PANEL: LPP (Existing)

MAIN: 40AT, 50AF, 3P

18KAIC, 240V, MCCB


CKT NO.	VOLTS	OUTLET		OTHER LOAD SERVICE	AMPERE LOAD 1Ø	VOLT AMPERE	CIRCUIT BREAKER			SIZE OF WIRE			
		LO	CO				AT	P	AF	L	G	CONDUIT	CODE
1	220	15			6.82	1,500	20	2	50	2 - 3.5mm ² THHN	1 - 3.5mm ² THW	1/2" Ø PVC	X3.5
2	220		11		9.00	1,980	20	2	50	2 - 3.5mm ² THHN	1 - 3.5mm ² THW	1/2" Ø PVC	X3.5
3	220			1.5Hp Aircon	10.00	2,300	30	2	50	2 - 5.5mm ² THHN	1 - 3.5mm ² THW	1/2" Ø PVC	X5.5
4	220			1.5Hp Aircon	10.00	2,300	30	2	50	2 - 5.5mm ² THHN	1 - 3.5mm ² THW	1/2" Ø PVC	X5.5
TOTAL					35.82	8,080							

$$I_L = 35.82 + (10.00 \times 0.25) = 38.32 \text{ Amperes}$$

Feeder Line:

Use: 3 - 14mm² THHN + 1 - 5.5mm² THW (G) in 3/4" Ø IMC / Y14

2 LEGENDS & SYMBOLS

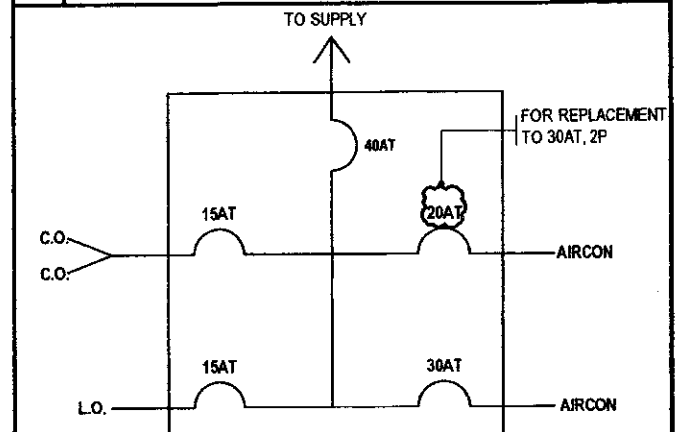

3 SCHEDULE OF LOADS



Republic of the Philippines
Largest City in the World
CITY ARCHITECT DEPARTMENT
OF QUEZON CITY
OF QUEZON CITY, PHILIPPINES
QUEZON CITY, PHILIPPINES



PROVIDE:

Architect and engineering firm shall be responsible for the design and construction of the building and its systems. The architect shall be responsible for the design and construction of the building and its systems. The engineer shall be responsible for the design and construction of the building and its systems.

RECOMMENDING APPROVAL

AR. LUCILLE H. CHUA, fuap, plep
CITY ARCHITECT

APPROVED BY:

HON. GIAN CARLO G. SOTTO
C.C.

PROJECT TITLE:

SUPPLY AND INSTALLATION OF MODULAR PARTITIONS INCLUDING FURNITURES AND OTHER WORKS FOR THE QUEZON CITY SPORTS DEVELOPMENT OFFICE AT ROOM 201, 2ND FLOOR, LEGISLATIVE BUILDING

SHEET CONTENTS:


GENERAL NOTES
LEGENDS & SYMBOLS
SCHEDULE OF LOADS
PANEL DETAILS

PROJECT NO.:

DATE: March 2024
DRAWN BY: Ar. G.D.B.
DESIGNED BY: Engr. A.G.T.B.
CHECKED BY: Engr. A.G.T.B.


SHEET NO.:

EL-01

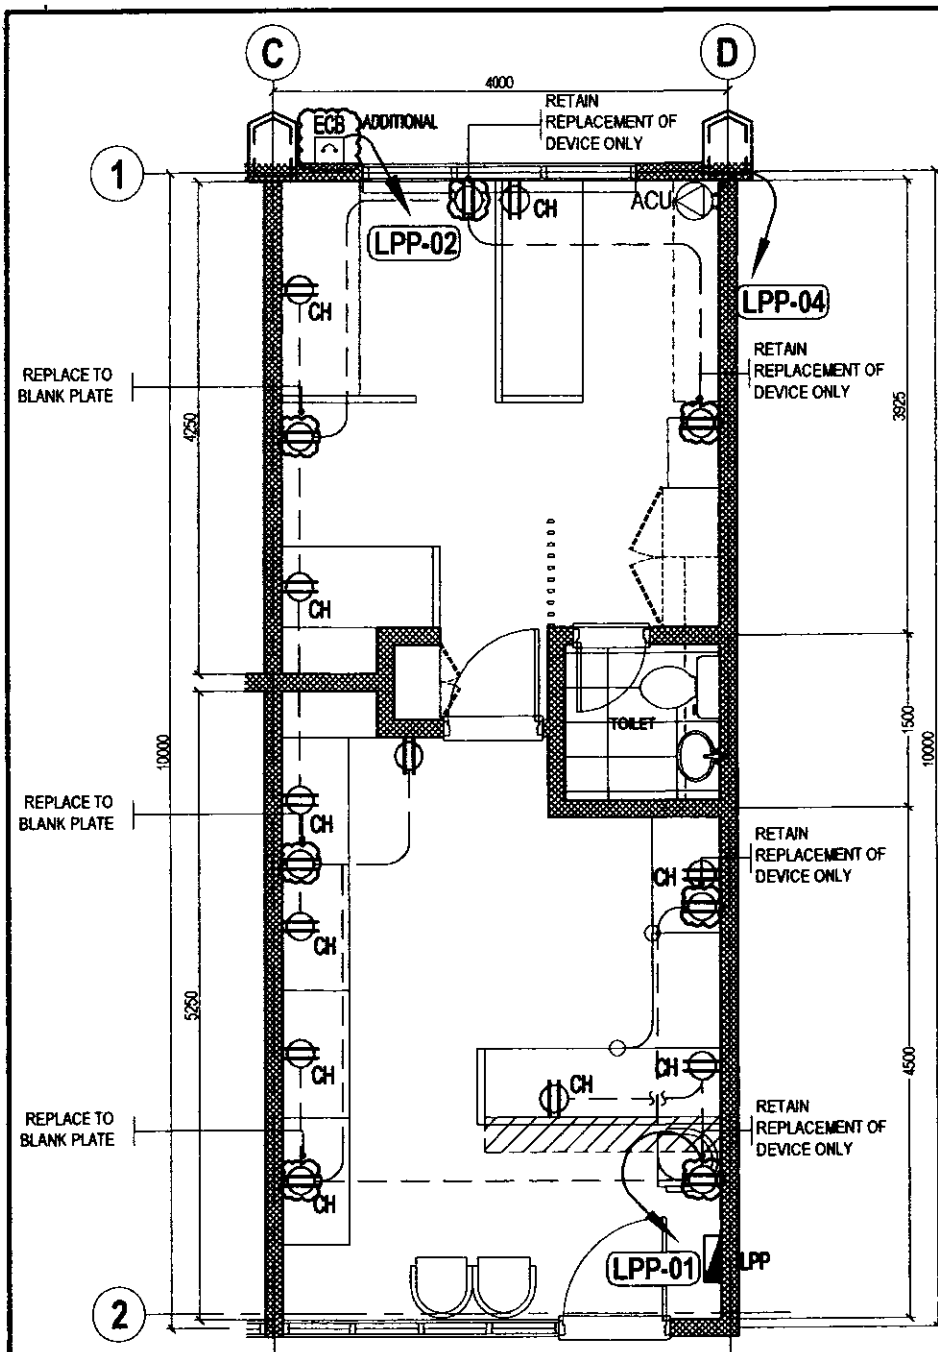

NOTE:

1. CLOUDED OUTLET (EXISTING) WILL SERVE AS THE SPLICING OF NEW OUTLETS (COUNTER HEIGHT). USE BLANK COVER.
2. VERIFY CIRCUITS OF EXISTING OUTLETS.
3. COMBINE TWO CIRCUITS OF OUTLET (LPP-01 AND LPP-02) INTO ONE CIRCUIT.
4. REPLACE 20AT, 2P TO 30AT, 2P FOR THE ADDITIONAL AIRCON.

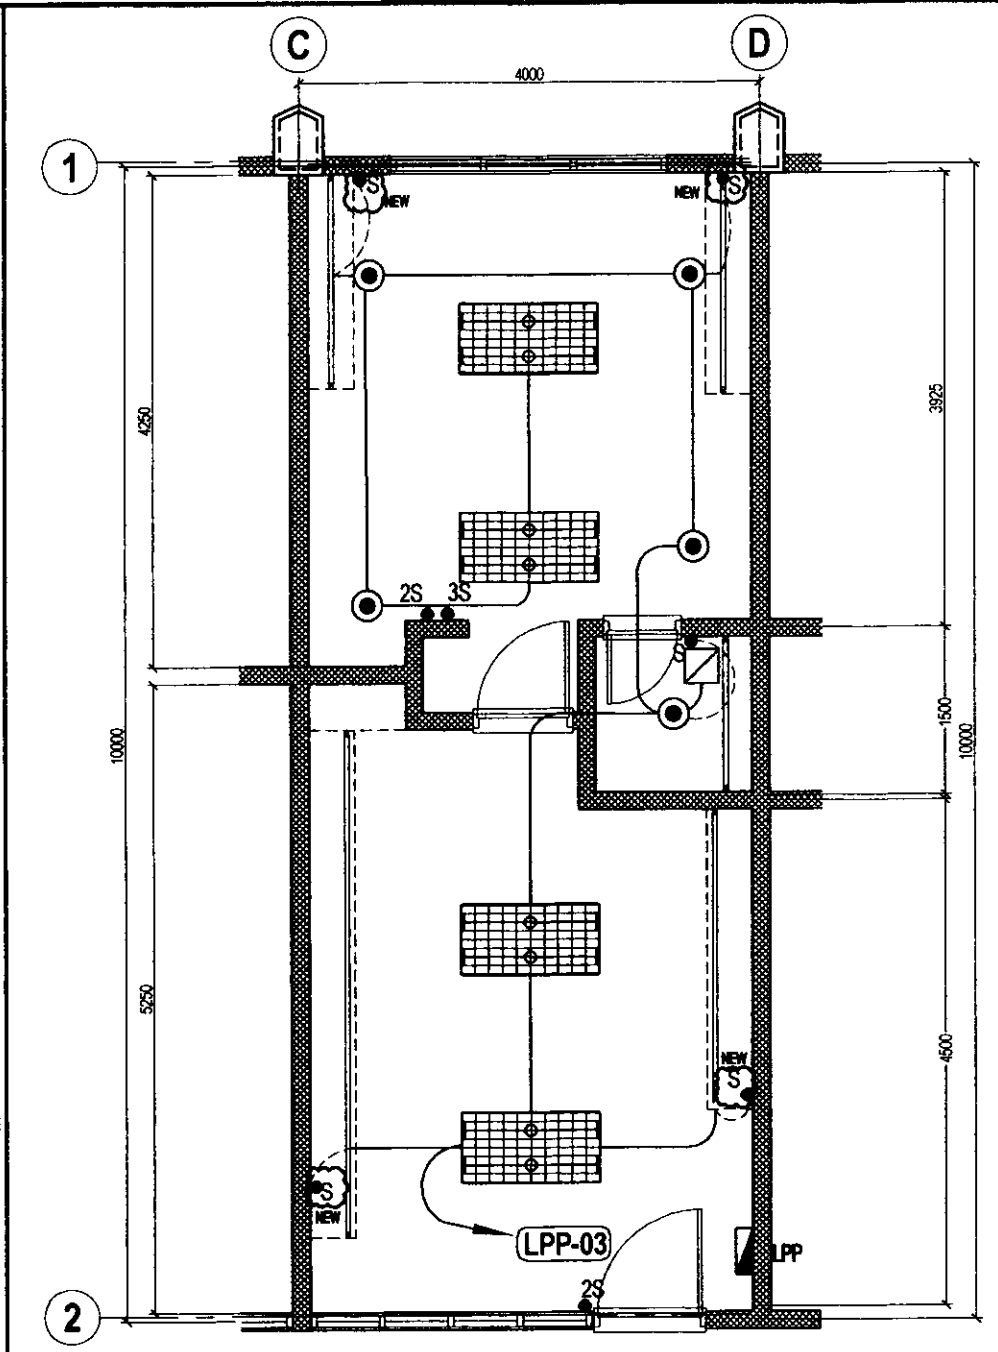

1 POWER LAYOUT

SCALE 1:50 METERS

2 LIGHTING LAYOUT

SCALE 1:50 METERS



Republic of the Philippines
Lungsod ng Quezon
CITY ARCHITECT DEPARTMENT
OF QUEZON CITY
BAYAN, QUEZON CITY



PROVISO

ALL WORKS SHALL BE DONE IN ACCORDANCE WITH THE LATEST EDITIONS OF THE NATIONAL ELECTRICAL CODE (NEC) AND THE NATIONAL MECHANICAL CODE (NMC). THE ARCHITECT SHALL BE RESPONSIBLE FOR THE DESIGN AND SPECIFICATIONS OF THE WORKS. THE CONTRACTOR SHALL BE RESPONSIBLE FOR THE INSTALLATION AND MAINTENANCE OF THE WORKS.

RECOMMENDING APPROVAL

AR. LUIS H. CHUA, RUP, PLEP
CITY ARCHITECT

APPROVED BY:

HON. GIAN CARLO G. SOTTO
CITY ARCHITECT

PROJECT TITLE:

SUPPLY AND INSTALLATION OF MODULAR PARTITIONS INCLUDING FURNITURES AND OTHER WORKS FOR THE QUEZON CITY SPORTS DEVELOPMENT OFFICE AT ROOM 201, 2ND FLOOR, LEGISLATIVE BUILDING

SHEET CONTENTS:

RISE DIAGRAM
LEGENDS & SYMBOLS
POWER LAYOUT

PROJECT NO.:

DATE: March 2024
DRAWN BY: A.B.D.B.
DESIGNED BY: E.A.M.T.B.I.
CHECKED BY: T.B.P.A.

SHEET NO.:

EL-02



- ## 2 LEGENDS AND SYMBOLS



Republika ng Pilipinas
Lungsod ng Cebu
CITY ARCHITECT DEPARTMENT
5F CMC CORP. Bldg. 800, CMC CITY, Cebu City,
6000 Cebu, Philippines

[illegible]

AR. LUCILLE H. CHUA, Resp, plep


HON. GIAN CARLO G. SOTTO

**SUPPLY AND INSTALLATION OF MODULAR PARTITIONS
INCLUDING FURNITURES AND OTHER WORKS
FOR THE QUEZON CITY SPORTS DEVELOPMENT OFFICE
AT ROOM 201, 2ND FLOOR, LEGISLATIVE BUILDING**

WNS	RISER DIAGRAM
	LEGENDS AND SYMBOLS
VOICE	VOICE DATA & WAP LAYOUT


DATE	March 2024
DRAWN BY	Ar. B.D.B.
DESIGNED BY	Eng. E.R.S.
CHECKED BY	Eng. F.M. / T.B.

EL-03

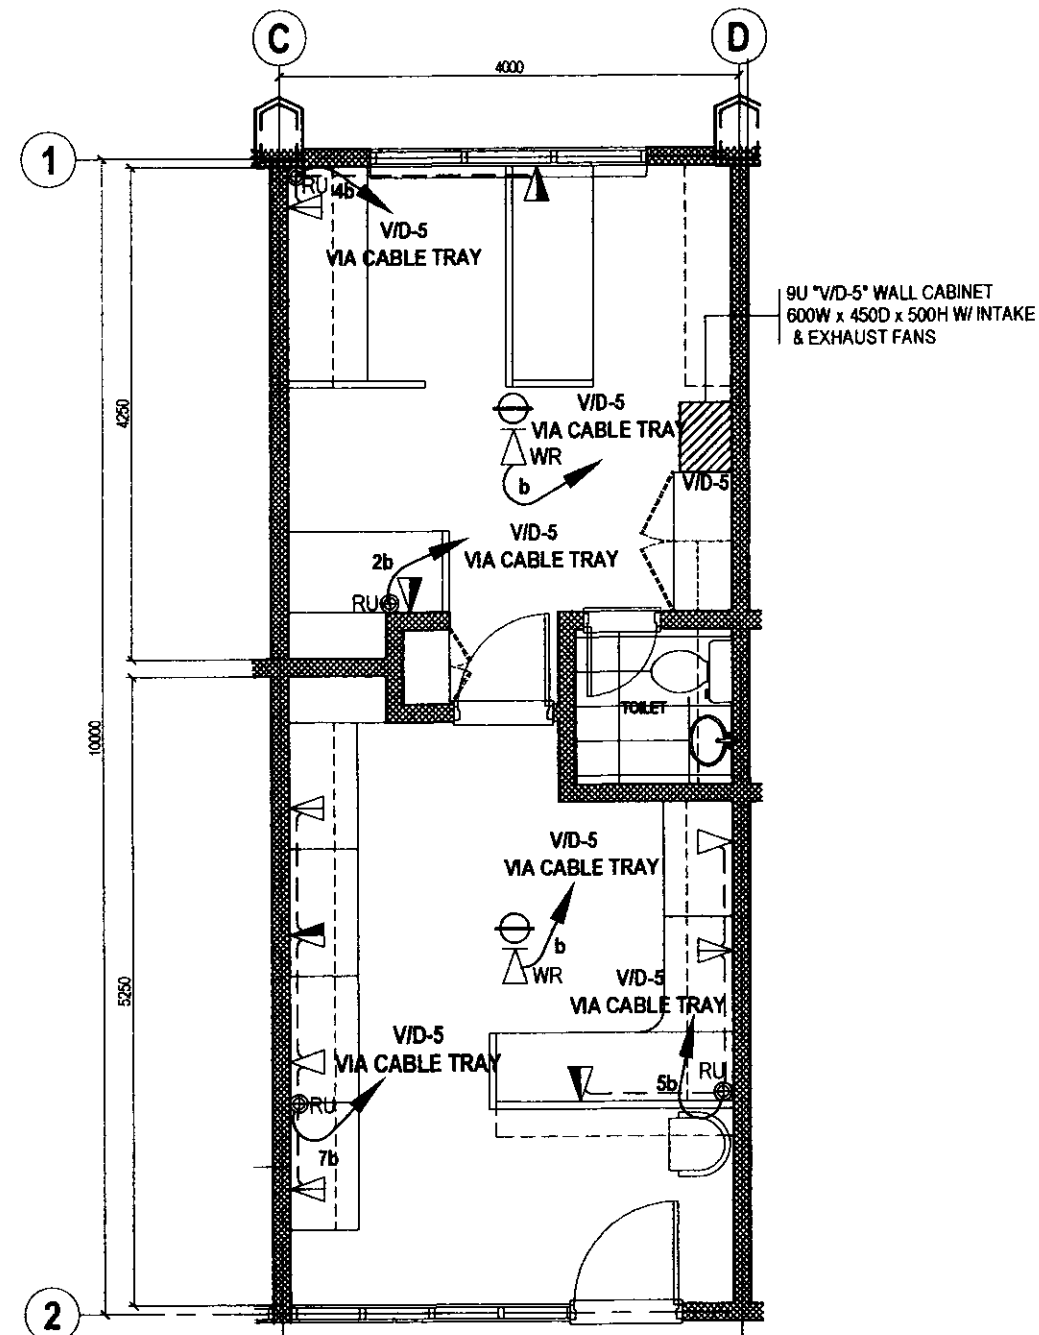

3 SPORTS DEVELOPMENT OFFICE VOICE , DATA & WAP LAYOUT

SCALE 1:50 METERS

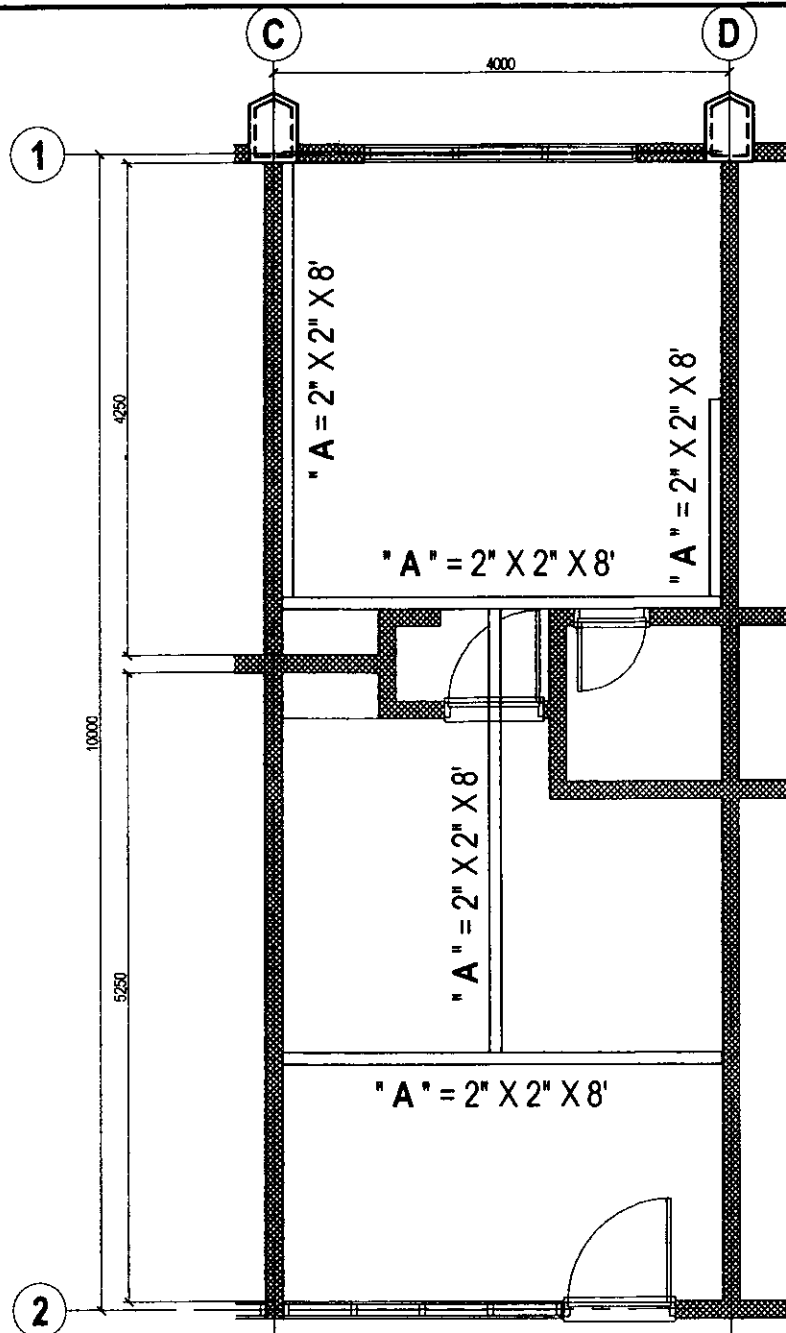

CABLE TRAY / WIREWAY DESIGNATION AND SCHEDULE

DESIGNATION	DIMENSION	MATERIAL	REQUIREMENTS
"A"	2' x 2' x 8'	HOT DIPPED GALVANIZED (HDG) W/ SOLID BOTTOM	1. CABLE TRAY / WIREWAY SUPPORTING FRAME AND BRACKET FOR EVERY 5'-8" SPAN AS REQUIRED 2. INCLUSION OF CLAMPING, SUPPORTING AND SPLICING ACCESSORIES (ELBOWS, TEES AND CROSSES) 3. EARTH BONDING CONNECTION TO MAIN GROUNDING GRID.

1 SPORTS DEVELOPMENT OFFICE CABLE TRAY LAYOUT

SCALE 1:50 METERS



Regulated by Philippine
Landscape Architecture
CITY ARCHITECT DEPARTMENT
OF QUEZON CITY
1000, 1000, 1000, 1000



PROVISION

PROVISION OF CABLE TRAY LAYOUT
FOR THE QUEZON CITY SPORTS DEVELOPMENT OFFICE
AT ROOM 201, 2ND FLOOR, LEGISLATIVE BUILDING

RECOMMENDING APPROVAL

AR. LUCILLE H. CHUA, RUP, PLEP
CITY ARCHITECT

APPROVED BY:

HON. GIAN CARLO G. SOTTO
CITY ARCHITECT

PROJECT TITLE:

SUPPLY AND INSTALLATION OF MODULAR PARTITIONS
INCLUDING FURNITURES AND OTHER WORKS
FOR THE QUEZON CITY SPORTS DEVELOPMENT OFFICE
AT ROOM 201, 2ND FLOOR, LEGISLATIVE BUILDING

SHEET CONTENTS:

CABLE TRAY LAYOUT
CABLE TRAY / WIREWAY
DESIGNATION & SCHEDULE

PROJECT NO.:

DATE: March 2024
DRAWN BY: Ar. B.D.B.
DESIGNED BY: Engr. E.A.M.
CHECKED BY: Engr. E.A.M.

SHEET NO.:

EL-04



1. ALL MATERIALS AND FURNITURE ARE SUBJECT FOR APPROVAL OF DESIGNER AND/OR END USER.



1	STAFF AREA DETAILS
---	--------------------



SCALE 1:50 METERS (20 x 30)
SCALE 1:100 METERS (A3)

2 DOOR DETAILS

SCALE 1:30 METERS (20 x 30)
SCALE 1:30 METERS (A3)

3 CABINET DETAILS



RECOMMENDING APPROVAL

 R. LELLE H. CHUA, Assoc. plep
 CITY ARCHITECT

APPROVED BY :

HON.
OF MAYOR

PROJECT TITLE :

**SUPPLY AND INSTALLATION OF LOW PARTITIONS
INCLUDING FURNITURE AND OTHER WORKS FOR
OC SPORTS DEVELOPMENT OFFICE
AT LEGISLATIVE BUILDING**

LOCATION ROOM 201, 2ND FLR LEGISLATIVE BUILDING, QUEZON C

SHEET CONTENTS

STAFF AREA DETAILS
DOOR DETAILS
CABINET DETAILS

PROJECT NO.:

DATE	June 2024
DRAWN BY	Ar. B. G. / Ar. K. G. J.
DESIGNED BY	Ar. B. G. / Ar. B. G. J.
CHECKED BY	Ar. B. G. / Ar. B. G. J.

SHEET NO.

AR-05

- ALL MECHANICAL WORKS SHALL BE DONE IN ACCORDANCE WITH THE LATEST REQUIREMENTS OF THE NATIONAL BUILDING CODE, PSME CODE AND THE RULES AND REGULATIONS OF THE PHILIPPINES.
- THE SCOPE OF WORK SHALL INCLUDE ALL WORKS DESCRIBED IN PLANS.
- THE WORKS SHALL BE EXECUTED IN CLOSE COORDINATION WITH ALL OTHER TRADES.
- ALL AIRCONDITIONED SPACES SHALL BE MAINTAINED AT 24°C DB AND 50% RH.
- CONTRACTOR SHALL SUBMIT SHOP DRAWINGS, MANUFACTURERS CATALOGUE, SPECIFICATIONS, SAMPLES, INCLUDING VIBRATION ISOLATORS BEFORE EXECUTION OF WORK.
- ALL FLOOR SLAB MOUNTED VIBRATING EQUIPMENT SHALL BE PROVIDED WITH VIBRATION ISOLATORS TO PREVENT VIBRATIONS AND NOISE TRANSMISSION.
- EXHAUST FAN SHALL BE PROVIDED WITH SUITABLE FLEXIBLE CONNECTIONS TO DISCHARGE DUCT.
- THE CONTRACTOR SHALL BE RESPONSIBLE FOR ALL TESTING AND COMMISSIONING OF THE WHOLE VENTILATION AND AIRCONDITIONING SYSTEM AND INSTALLATION.
- ALL POWER WIRING SHALL BE ELECTRICAL AND TERMINATION TO EQUIPMENT SHALL BE MECHANICAL.
- PROVIDE CONTROL WIRING FOR AIRCONDITIONING EQUIPMENT.
- PROVIDE THERMOSTAT FOR ALL INDOOR UNITS / FAN COIL UNITS.
- VERIFY LOCATION OF CONTROLLERS AND SWITCHES ON ELECTRICAL PLANS.
- ALL PIPE EQUIPMENT CONDENSATE DRAIN SHALL BE CONNECTED TO THE NEAREST FLOOR DRAIN / AD/ACB.
- PROVIDE GUIDES, HANGERS, AND SUPPLEMENTAL STEEL SUPPORT FOR ALL PIPING, DUCTING AND EQUIPMENTS.
- PROVIDE PIPE SLEEVES FOR ALL PIPING PASSING THRU BUILDING STRUCTURE.
- ALL PIPE DIMENSIONS ARE IN MILLIMETER UNLESS OTHERWISE NOTED.

1 GENERAL NOTES

RP	REFRIGERANT PIPING		OUTDOOR UNIT (HORIZONTAL BLOW)	Ø	PHASE
▽	REFRIGERANT Y-BRANCH		EXISTING INDOOR UNIT	V	VOLTS
PIPE DIA.	CONDENSATE DRAIN PIPE		EXHAUST FAN	H	HERTZ
	EQUIPMENT DESIGNATION	ACCU	AIR-COOLED CONDENSING UNIT	W	WATTS
	WALL MOUNTED INDOOR UNIT	FCU	FAN COIL UNIT		

2 LEGENDS & SYMBOLS

SPLIT TYPE AIR-CONDITIONERS

DESIGNATION		LOCATION	QUANTITY	COOLING CAPACITY BTUH	AIR CIRCULATION		KW MOTOR OUTPUT	ELECTRICAL SUPPLY			REFRIGERANT PIPE		REMARKS
OUTDOOR	INDOOR				INDOOR, cfm	OUTDOOR, cfm		VOLTS	PHASE	HERTZ	GAS, mm	LIQUID, mm	
		AS SHOWN	1 SET	12,000	7.0-11.0	30.0	1.03	220.0	1Ø	60.0	9.52	6.35	FAN COIL UNIT SHALL BE WALL MOUNTED TYPE W/ REMOTE CONTROL DRAIN DEVICE, & HIGH PURITY FILTER INVERTER MOTOR.

3 EQUIPMENT SCHEDULE

4 AIR-CONDITIONING & VENTILATION LAYOUT SCALE 1:50 MTS



Supervised by:
Lupang B. Banaag
CITY ARCHITECT DEPARTMENT
OF QUEZON CITY
1000 P. DEL ROSARIO ST., QUEZON CITY, PHILIPPINES



 
PROVISO:

ALL WORKS SHALL BE DONE IN ACCORDANCE WITH THE LATEST REQUIREMENTS OF THE NATIONAL BUILDING CODE, PSME CODE AND THE RULES AND REGULATIONS OF THE PHILIPPINES.

RECOMMENDING APPROVAL:


AR. LUCILLE H. CHUA, RUPAP, PLEP
CITY ARCHITECT

APPROVED BY:


HON. GIAN CARLO G. SOTTO
CITY ARCHITECT

PROJECT TITLE:

SUPPLY AND INSTALLATION OF MODULAR PARTITIONS INCLUDING FURNITURES AND OTHER WORKS FOR THE QUEZON CITY SPORTS DEVELOPMENT OFFICE AT ROOM 201, 2ND FLOOR, LEGISLATIVE BUILDING

SHEET CONTENTS:


GENERAL NOTES
LEGENDS & SYMBOLS
EQUIPMENT SCHEDULE
AIR-CONDITIONING & VENTILATION LAYOUT

PROJECT NO.:


DATE: June 2024
DRAWN BY: Ar. B.D.B.
DESIGNED BY: Engr. A.J. Bello

SHEET NO.:


MP-01

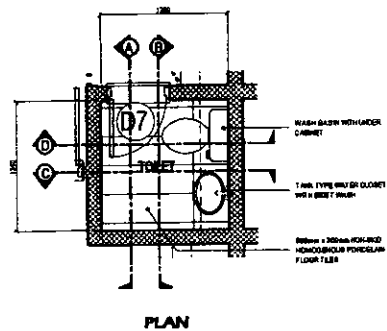


PLAN

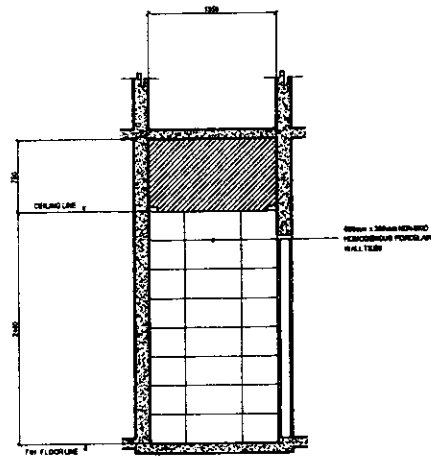


SECTION THRU 'A'

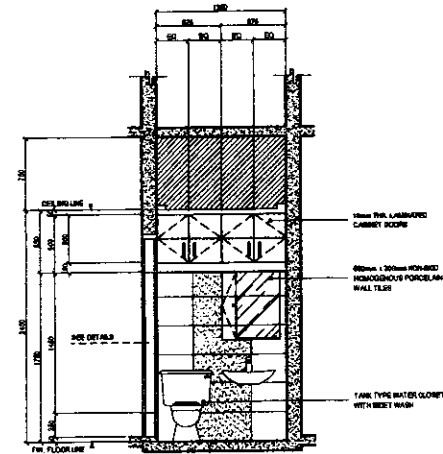

SECTION THRU 'B'

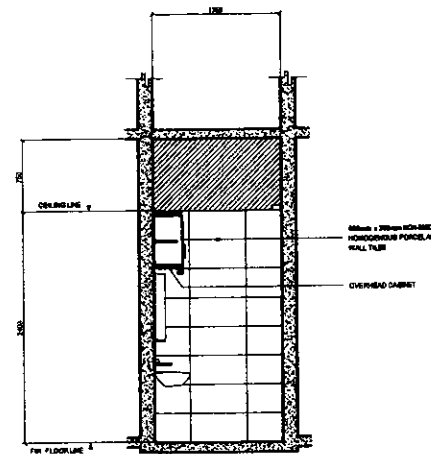

SECTION THRU 'C'

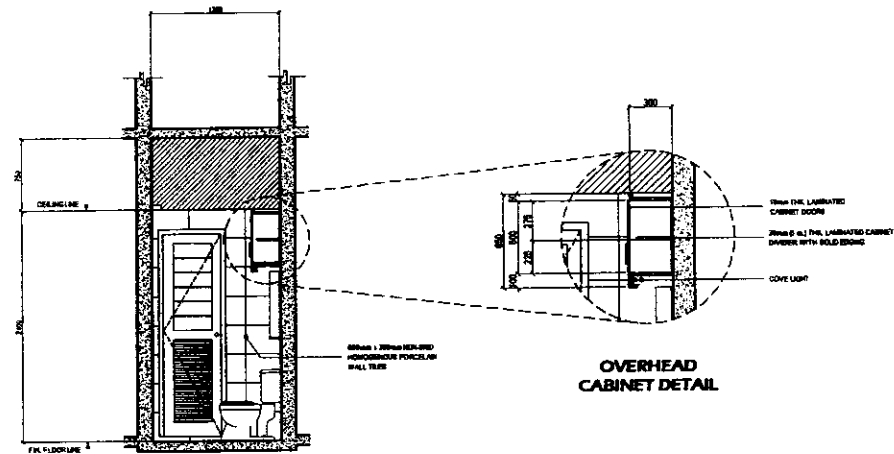

SECTION THRU 'D'


NOTE:

1. ALL MATERIALS AND FURNITURE ARE SUBJECT FOR APPROVAL OF DESIGNER AND/OR END USER

SCALE 1:20 METERS (20 x 30)
SCALE 1:50 METERS (A3)

1 TOILET DETAILS									
 Republic of Philippines Largest City Government CITY ARCHITECT DEPARTMENT OF CAGAYAN - ANNOYING CAGAYAN CITY, CAGAYAN NARVAJ, BANG, BANG, BANG	 PROVIDO: The City Architect shall be responsible for the design and construction of the building and its fixtures, and shall be responsible for the supervision of the construction of the building and its fixtures.	RECOMMENDING APPROVAL		APPROVED BY:		PROJECT TITLE:		SHEET CONTENTS:	
		 A. D. L. H. CHUA, RUPP, pcep CITY ARCHITECT		 HON. GIAN CARLO G. SOTTO VICE MAYOR C.C.		SUPPLY AND INSTALLATION OF LOW PARTITIONS INCLUDING FURNITURE AND OTHER WORKS FOR QC SPORTS DEVELOPMENT OFFICE AT LEGISLATIVE BUILDING LOCATION: ROOM 301, 2ND FLOOR, LEGISLATIVE BUILDING, CAGAYAN CITY		TOILET DETAILS PROJECT NO.: SHEET NO.:	
								DATE: June 2024 DRAWN BY: A. D. L. H. CHUA CHECKED BY: A. D. L. H. CHUA APPROVED BY: A. D. L. H. CHUA	

AR-06

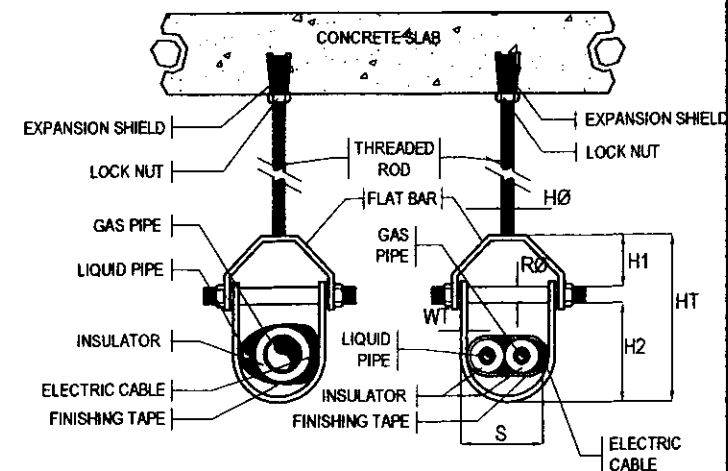

MP-02